

©2014 DESIGN DELMARVA / S.E. WAGNER, ARCHITECT EXPRESSLY RESERVES ITS COMMON LAW COPYRIGHT AND OTHER PROPERTY RIGHTS IN THESE PLANS. THESE PLANS ARE NOT TO BE REPRODUCED, CHANGED OR COPIED IN ANY FORM OR MANNER WHATSOEVER. NONE ARE THEY TO BE ASSIGNED TO ANY THIRD PARTY WITHOUT FIRST OBTAINING THE EXPRESS WRITTEN PERMISSION AND CONSENT OF DESIGN DELMARVA / S.E. WAGNER, ARCHITECT.



Church Road Animal Hospital

45441 RURITAN CIRCLE
STERLING, VIRGINIA 20164

TAX MAP /80/////////76/
PIN 032-45-4037-000

DESIGN TEAM

OWNER:
Church Road Animal Hospital
c/o Sharma, Navdeep Kumar & Ritu Kanwar
43470 Rockforest Court
Sterling, Virginia 20166
Phone: (757) 288-0503

ARCHITECTURAL:
S. E. WAGNER, ARCHITECT
4252 Manor Drive
Marshall, Virginia 20115
Phone: (540) 364-6399

STRUCTURAL:
BEI STRUCTURAL ENGINEERS
3930 Pender Drive, Suite 175
Fairfax, Virginia 22030
Phone: (703) 890-5000

MEP DRAWINGS:
MEI ENGINEERING INC.
Mechanical Electrical Industrial Consultants
276 South Liberty Street
Harrisonburg, Virginia 22801
Phone: (540) 432-6272

SITE PLAN & RELATED SUBMISSIONS:
Sitech Consulting Group
Nasser S. Alkhalani
12146 Paper Birch Ln
Gainesville, Virginia 20155
Phone: (703) 927-2300

DRAWING INDEX

CVR	COVER SHEET
CP	CODE PLAN
A1	FIRST FLOOR PLAN
A2	SECOND FLOOR PLAN
A3	FRONT & REAR ELEVATIONS, WALL SECTION
A4	LEFT & RIGHT ELEVATIONS
A5	FIRST FLOOR REFLECTED CEILING PLAN
A6	SECOND FLOOR REFLECTED CEILING PLAN
A7	ROOF PLAN
A8	BUILDING CROSS SECTIONS A & B
A9	BUILDING CROSS SECTIONS C & D, WALL SECTION 1
A10	WALL SECTIONS 2-5
A11	DOOR SCHEDULE, FINISH SCHEDULE, DETAILS
A12	STOREFRONT ELEVATIONS
A13	TOILET ROOM DETAILS & ELEVATIONS
S0	STRUCTURAL NOTES
S1	FOUNDATION & FIRST FLOOR PLAN
S2	SECOND FLOOR FRAMING PLAN
S3	ROOF FRAMING PLAN
S4	FOUNDATION DETAILS
S5	FRAMING DETAILS
M0.1	HVAC SPECIFICATIONS
M0.2	HVAC SCHEDULES
M0.3	HVAC DIAGRAMS
M1.0	HVAC PLAN & DETAILS
E0.1	ELECTRICAL SPECIFICATIONS
E0.2	ELECTRICAL LEGEND, RISER, AND DIAGRAMS
E0.3	ELECTRICAL SCHEDULES
E1.1	POWER PLANS
E2.1	LIGHTING PLANS
E3.1	SITE LIGHTING PLANS, POLE DIAGRAM AND SCHEDULE
P0.1	PLUMBING SCHEDULES, DETAILS & SPECS
P1.1	SANITARY PLANS & DETAILS
P2.1	WATER/GAS PLANS & RISERS
P3.1	PLUMBING RISERS

SEAL

REVISIONS	
DATE	REMARKS
6-06-17	OWNER CHANGES

ISSUED FOR
PERMIT
3-10-17

THIS DRAWING IS THE PROPERTY OF
S.E. Wagner, Architect
1304 SAVANNAH RD
LEWES, DE 19958
p.540.364.6399
f.540.364.6885
design@delmarva.com
sewain@delmarva.com
© 2014 S.E. WAGNER, ARCHITECT

CHURCH ROAD ANIMAL HOSPITAL
45441 RURITAN CIRCLE


VIRGINIA

STERLING

COVER SHEET

DATE 1-17-17	SHEET NO. C ☐ R
FILE -	

©2014 DESIGN DELMARVA / S.E. WAGNER, ARCHITECT EXPRESSLY RESERVES ITS COMMON LAW COPYRIGHT AND OTHER PROPERTY RIGHTS IN THESE PLANS. THESE PLANS ARE NOT TO BE REPRODUCED, CHANGED OR COPIED IN ANY FORM OR MANNER WHATSOEVER. NONE ARE THEY TO BE ASSIGNED TO ANY THIRD PARTY WITHOUT FIRST OBTAINING THE EXPRESS WRITTEN PERMISSION AND CONSENT OF DESIGN DELMARVA / S.E. WAGNER, ARCHITECT.

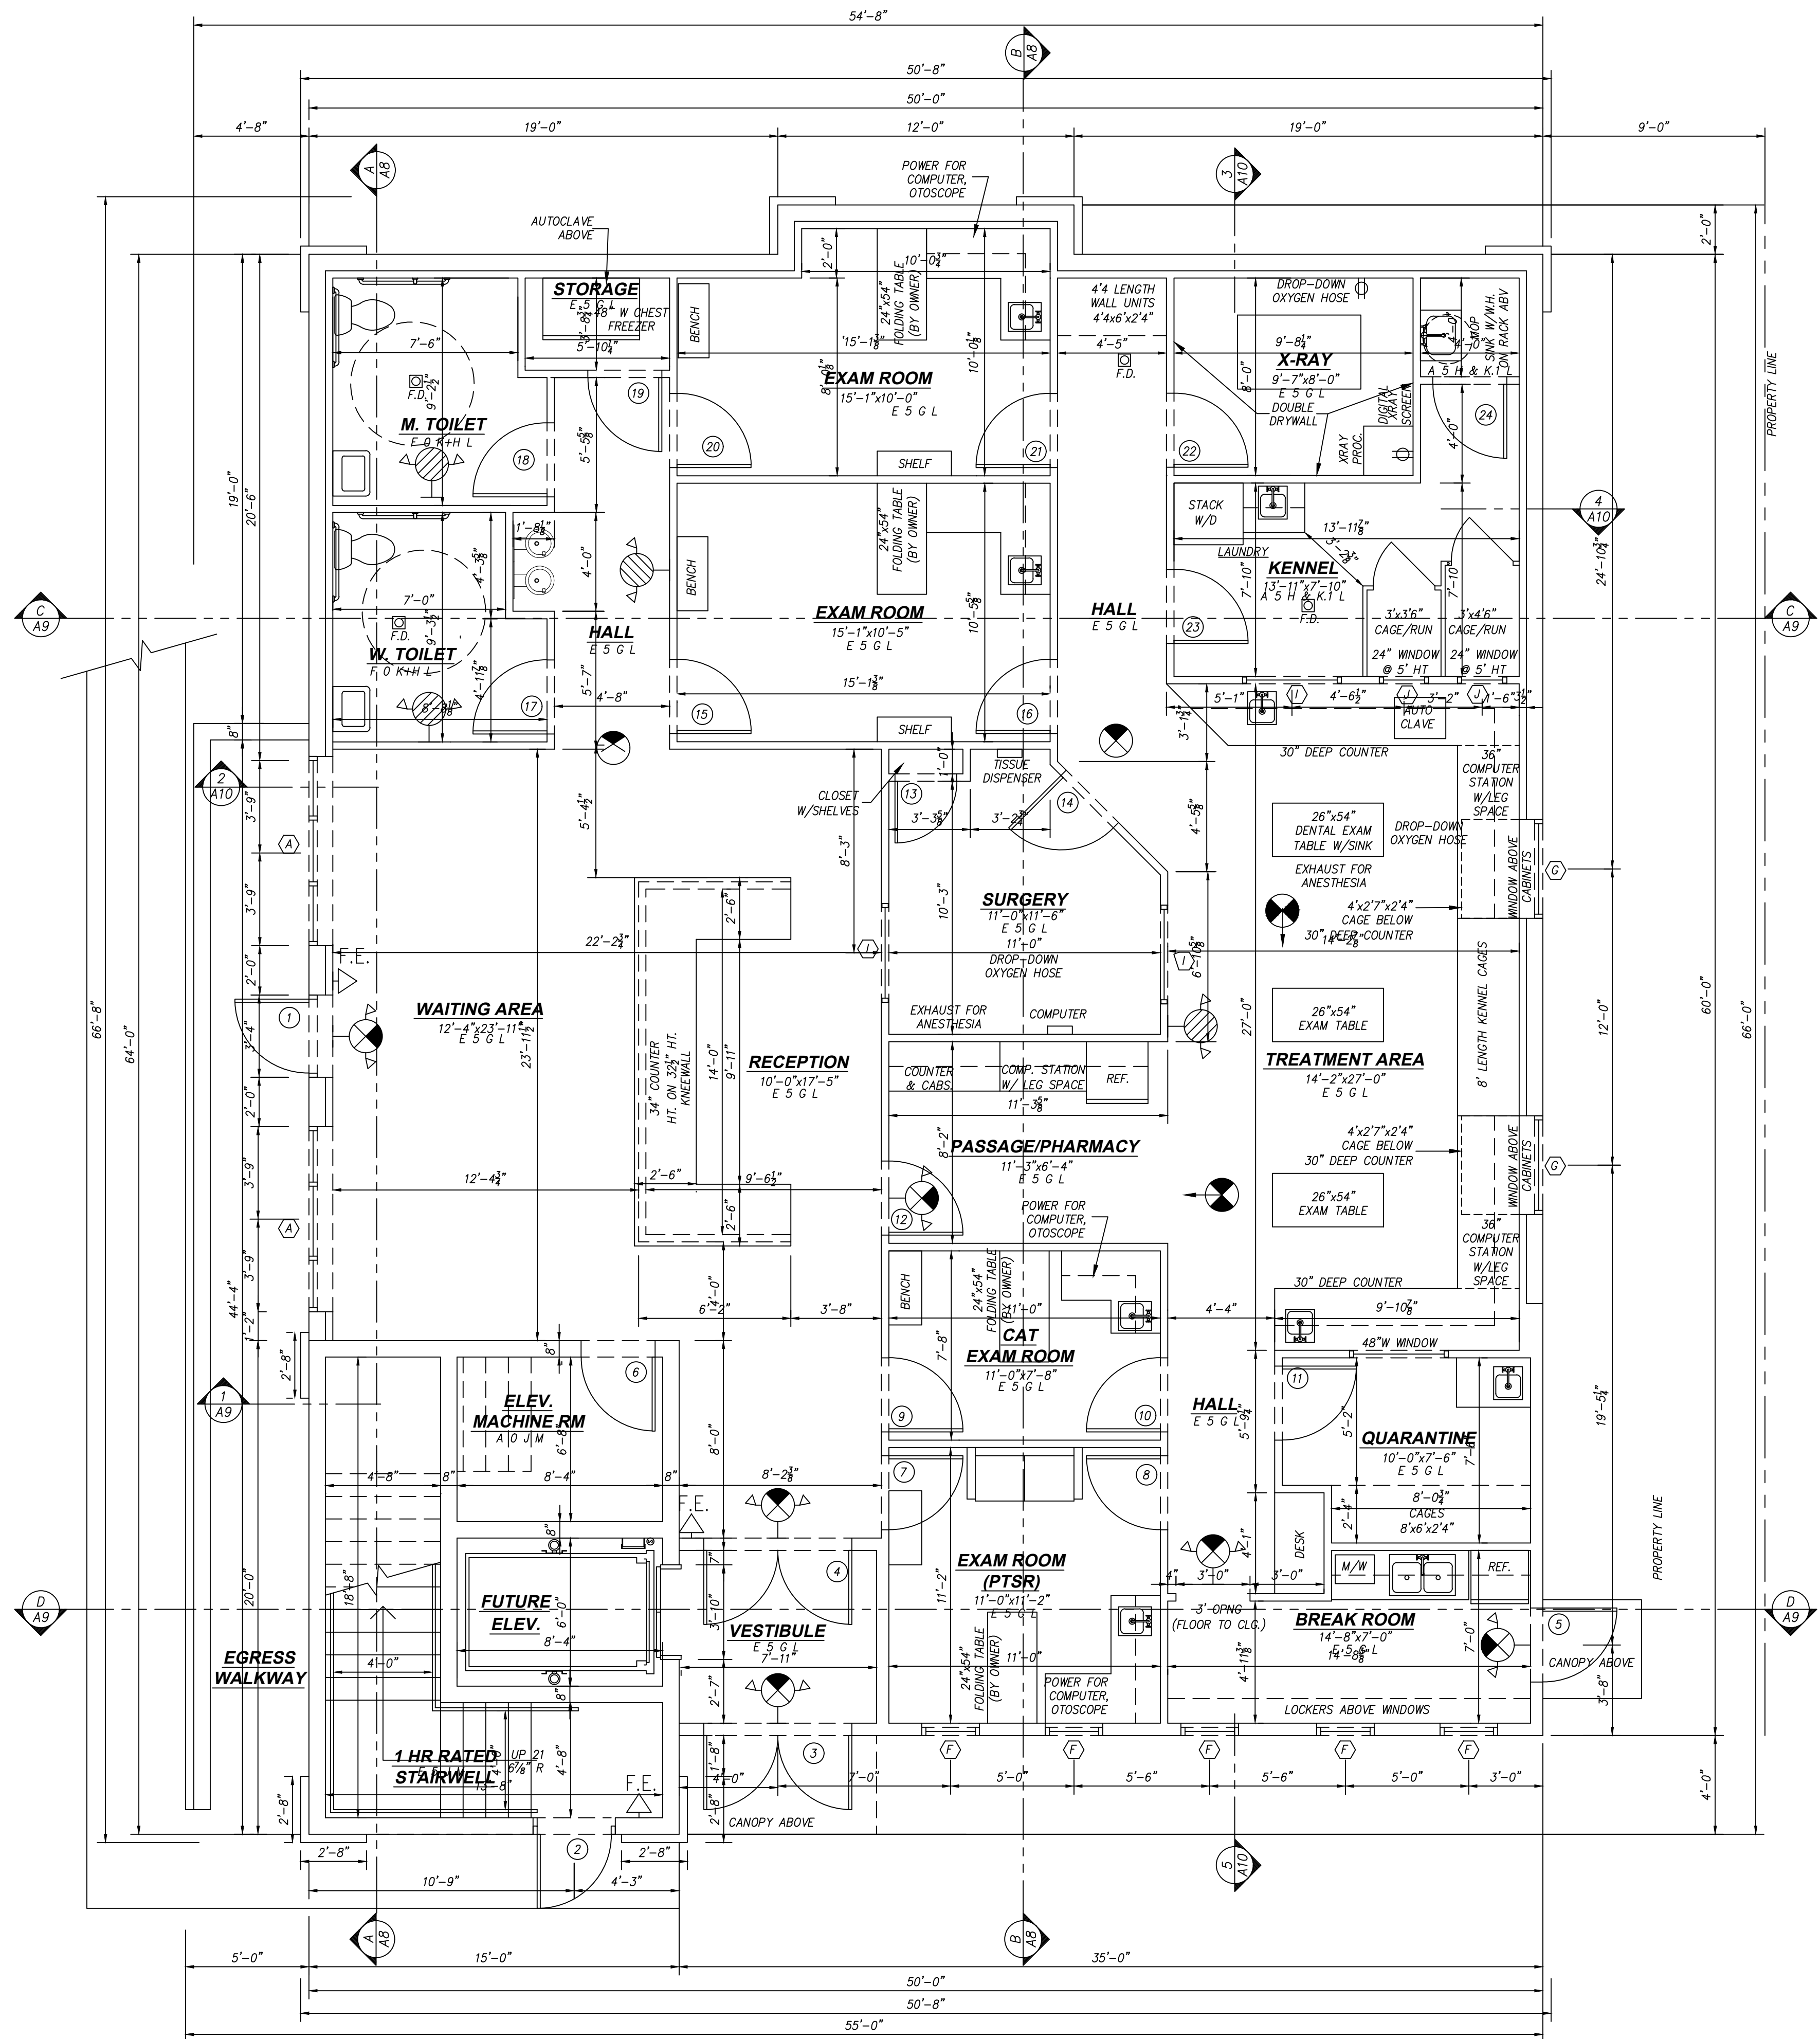

SEAL

REVISIONS	
DATE	REMARKS
4-08-17	AREA OF REFUGE ADDED
6-06-17	OWNER CHANGES
6-08-17	OWNER CHANGES


ISSUED FOR
PERMIT
3-10-17

THIS DRAWING IS THE PROPERTY OF
S.E. Wagner, Architect
1304 SAVANNAH RD
LEWES, DE 19958
p.302.644.8884
f.302.644.8885
design@delmarva@verizon.net
sewain@aol.com
© 2014 S.E. WAGNER, ARCHITECT

CHURCH ROAD ANIMAL HOSPITAL
45441 RURITAN CIRCLE
STERLING VIRGINIA
FIRST FLOOR PLAN

DATE 1-17-17	SHEET NO. A1
FILE -	

©2014 DESIGN DELMARVA / S.E. WAGNER, ARCHITECT. THESE PLANS ARE NOT TO BE REPRODUCED, CHANGED OR COPIED IN ANY FORM OR MANNER WHATSOEVER. NORE ARE THEY TO BE ASSIGNED TO ANY THIRD PARTY WITHOUT FIRST OBTAINING THE EXPRESS WRITTEN PERMISSION AND CONSENT OF DESIGN DELMARVA / S.E. WAGNER, ARCHITECT.

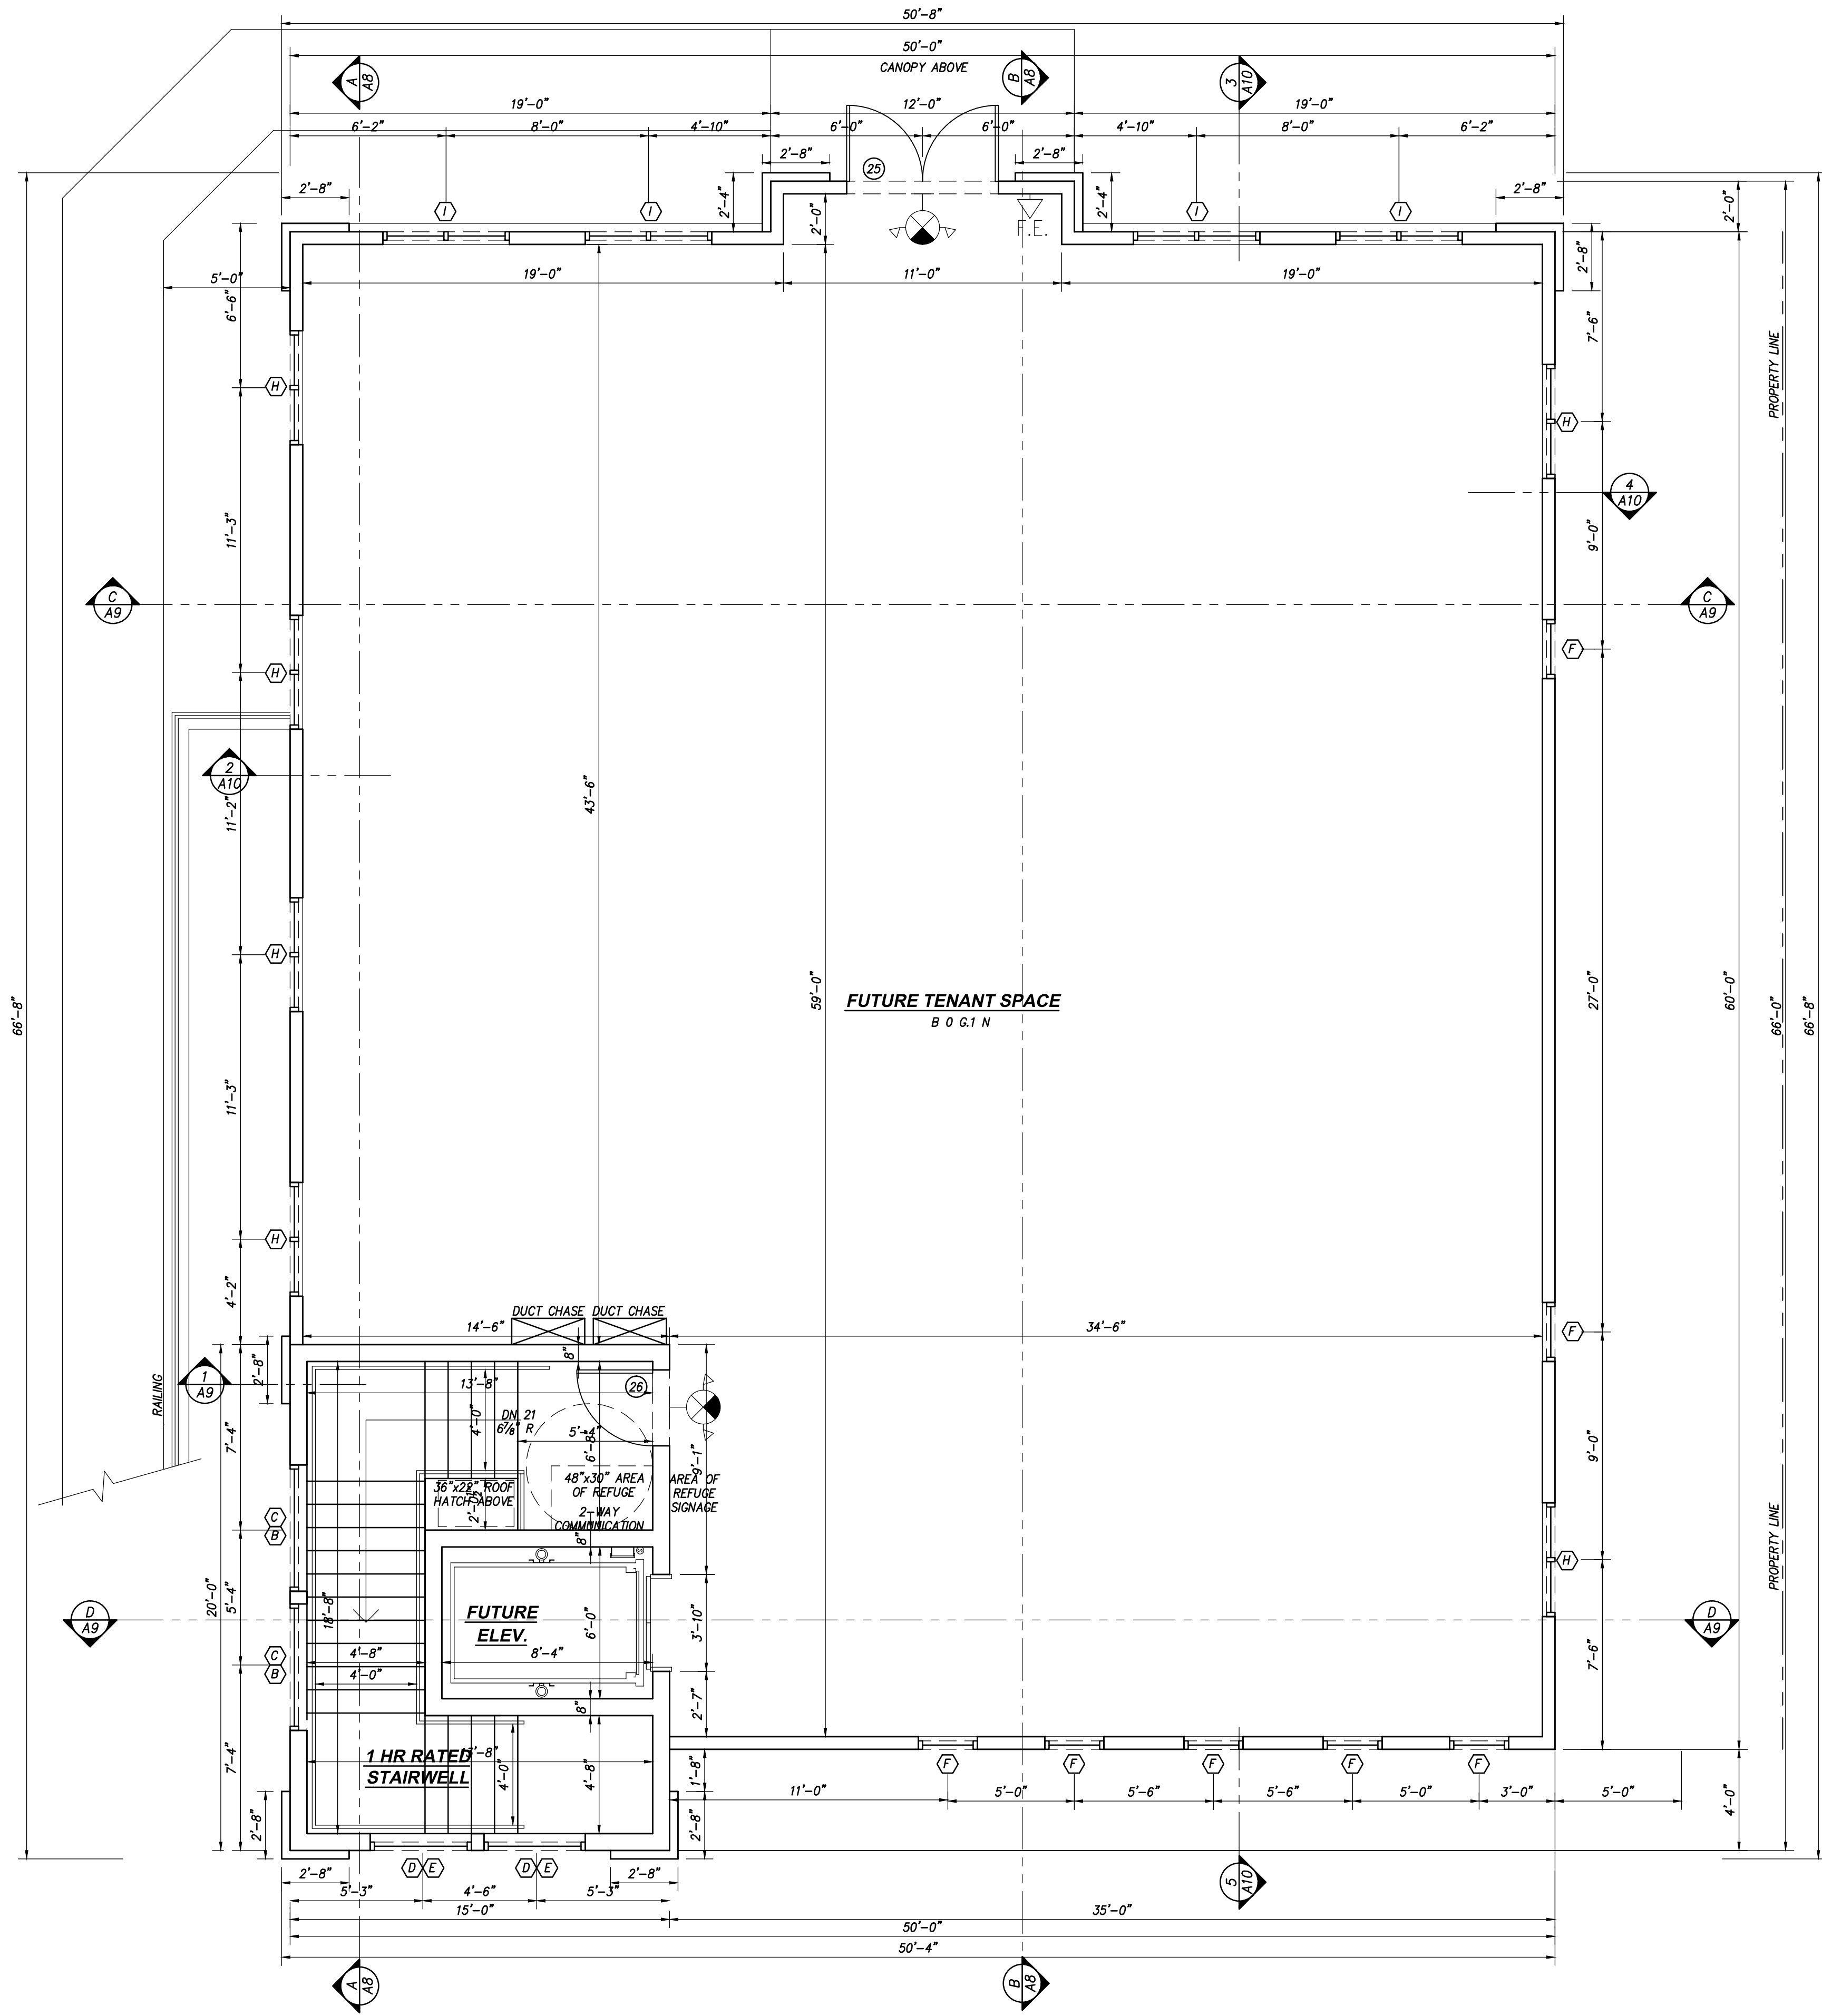

SECOND FLOOR PLAN
SCALE: 1/4"=1'-0"

SEAL

REVISIONS	
DATE	REMARKS
4-08-17	AREA OF REFUGE ADDED
6-06-17	OWNER CHANGES

ISSUED FOR
PERMIT
3-10-17

THIS DRAWING IS THE PROPERTY OF
S.E. Wagner, Architect
4252 MANOR DRIVE
MARSHALL, VA 20115
p.540.364.6399
f.540.364.0446
sewain@aol.com

1304 SAVANNAH RD
LEWES, DE 19958
p.302.644.8884
f.302.644.8885
design@delmarva@verizon.net


© 2014 S.E. WAGNER, ARCHITECT

CHURCH ROAD ANIMAL HOSPITAL
45441 RURITAN CIRCLE
STERLING VIRGINIA

SECOND FLOOR PLAN

DATE 1-17-17	SHEET NO. A
FILE -	

©2014 DESIGN DELMARVA / S.E. WAGNER, ARCHITECT EXPRESSLY RESERVES ITS COMMON LAW COPYRIGHT AND OTHER PROPERTY RIGHTS IN THESE PLANS. THESE PLANS ARE NOT TO BE REPRODUCED, CHANGED OR COPIED IN ANY FORM OR MANNER WHATSOEVER, NOR ARE THEY TO BE ASSIGNED TO ANY THIRD PARTY WITHOUT FIRST OBTAINING THE EXPRESS WRITTEN PERMISSION AND CONSENT OF DESIGN DELMARVA / S.E. WAGNER, ARCHITECT.

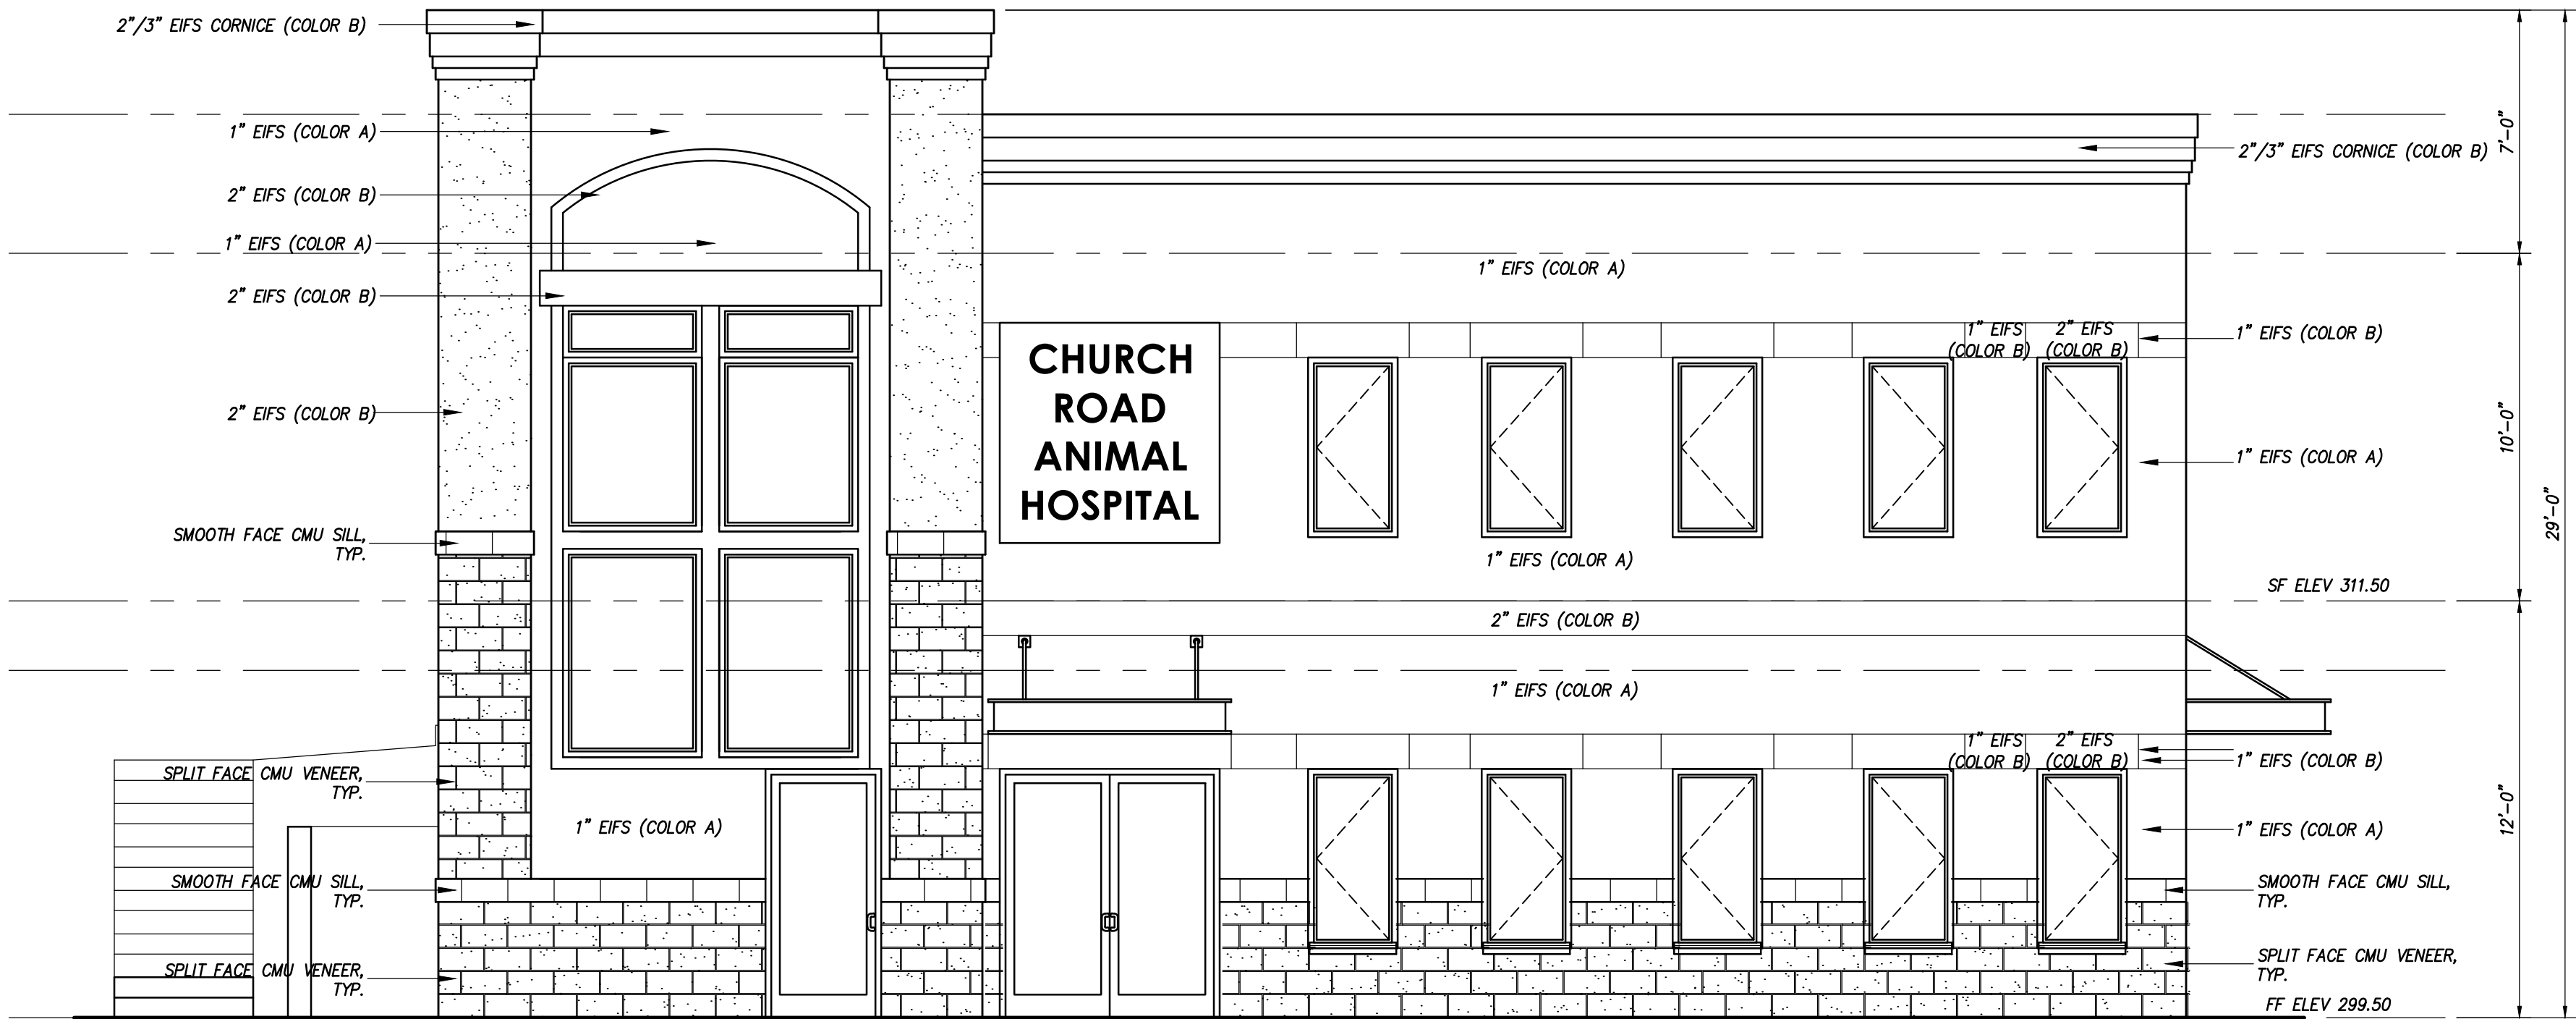

RURITAN CIRCLE ELEVATION

SCALE: 1/4"=1'-0"



CHURCH RD ELEVATION

SCALE: 1/4"=1'-0"

SEAL

REVISIONS	
DATE	REMARKS
6-06-17	OWNER CHANGES

ISSUED FOR
PERMIT
3-10-17

THIS DRAWING IS THE PROPERTY OF
S.E. Wagner, Architect
1304 SAVANNAH RD
LEWES, DE 19958
P. 302.644.8884
F. 302.644.8885
design@delmarva.net
sewain@aol.com
© 2014 S.E. WAGNER, ARCHITECT


CHURCH ROAD ANIMAL HOSPITAL
45441 RURITAN CIRCLE
STERLING

VIRGINIA

FRONT & REAR ELEVATIONS

DATE 1-17-17	SHEET NO. A3
FILE -	


©2014 DESIGN DELMARVA / S.E. WAGNER, ARCHITECT. THESE PLANS ARE NOT TO BE REPRODUCED, CHANGED OR COPIED IN ANY FORM OR MANNER WHATSOEVER. NORE ARE THEY TO BE ASSIGNED TO ANY THIRD PARTY WITHOUT FIRST OBTAINING THE EXPRESS WRITTEN PERMISSION AND CONSENT OF DESIGN DELMARVA / S.E. WAGNER, ARCHITECT.

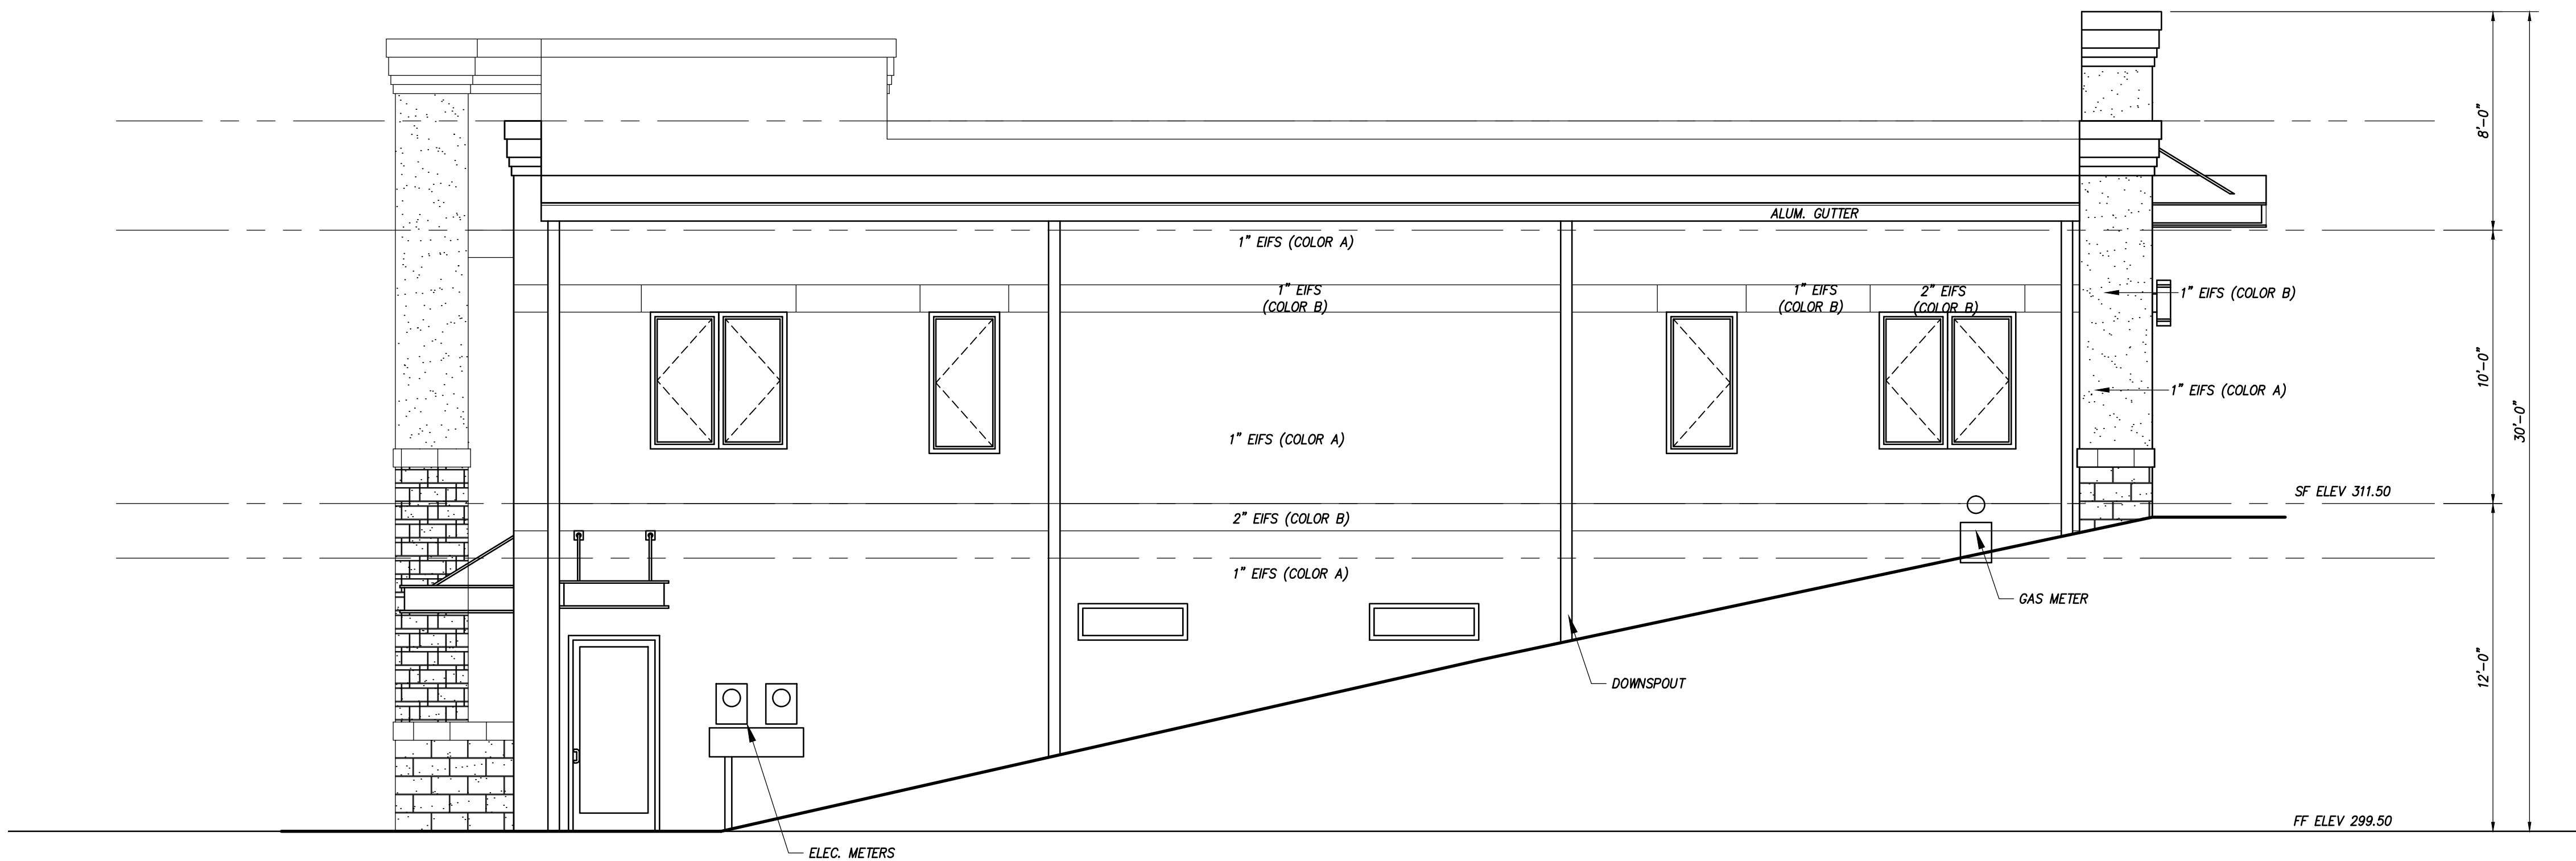

RIGHT ELEVATION

FRONT ELEVATION

SCALE: 1/4"=1'-0"

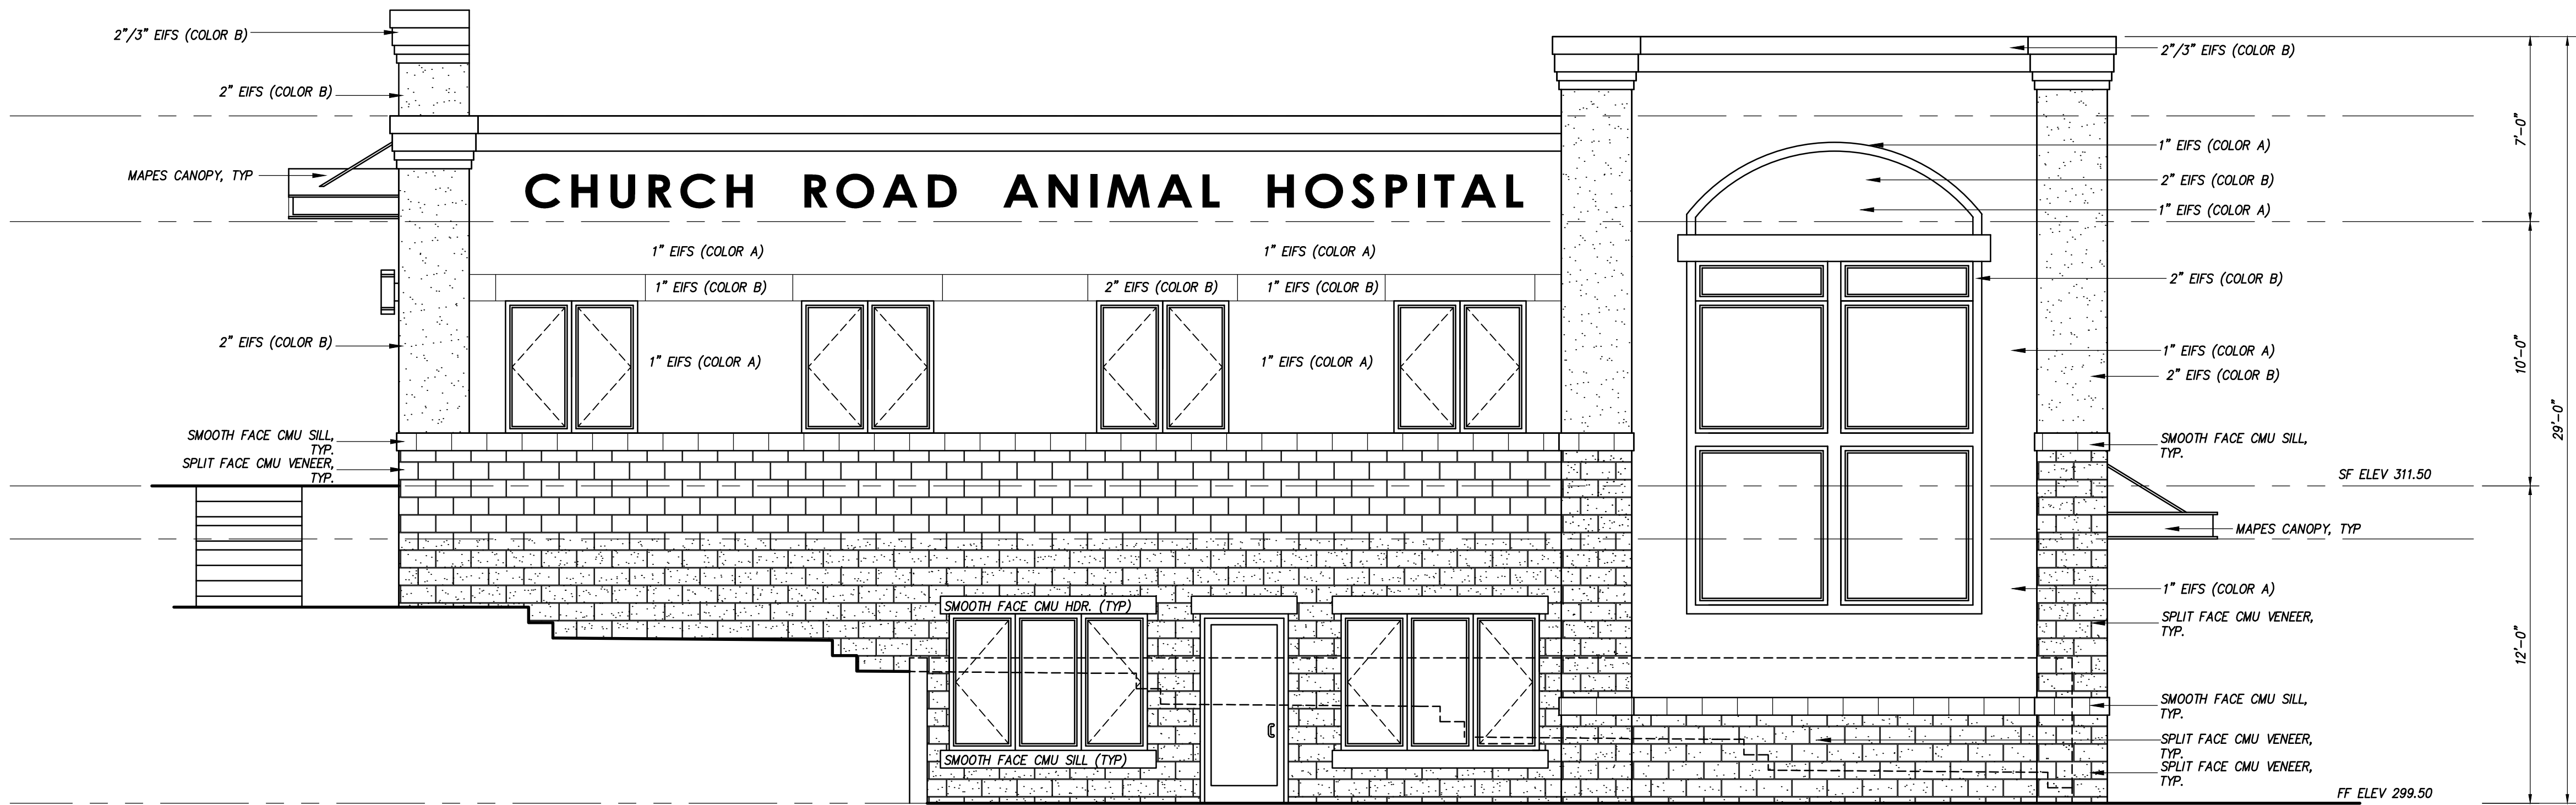

REAR ELEVATION

SCALE: 1/4"=1'-0"

SEAL

REVISIONS	
DATE	REMARKS
4-08-17	AREA OF REFUGE ADDED
6-06-17	OWNER CHANGES


ISSUED FOR
PERMIT
3-10-17

THIS DRAWING IS THE PROPERTY OF
S.E. Wagner, Architect
1304 SAVANNAH RD
LEWES, DE 19958
P. 302.644.8884
F. 302.644.8885
design@delmarva.net
sewain@aol.com
© 2014 S.E. WAGNER, ARCHITECT

CHURCH ROAD ANIMAL HOSPITAL
45441 RURITAN CIRCLE
STERLING VIRGINIA
FRONT & REAR ELEVATIONS

DATE 1-17-17	SHEET NO. A
FILE -	

©2014 DESIGN DELMARVA / S.E. WAGNER, ARCHITECT EXPRESSLY RESERVES ITS COMMON LAW COPYRIGHT AND OTHER PROPERTY RIGHTS IN THESE PLANS. THESE PLANS ARE NOT TO BE REPRODUCED, CHANGED OR COPIED IN ANY FORM OR MANNER WHATSOEVER. NONE ARE THEY TO BE ASSIGNED TO ANY THIRD PARTY WITHOUT FIRST OBTAINING THE EXPRESS WRITTEN PERMISSION AND CONSENT OF DESIGN DELMARVA / S.E. WAGNER, ARCHITECT.

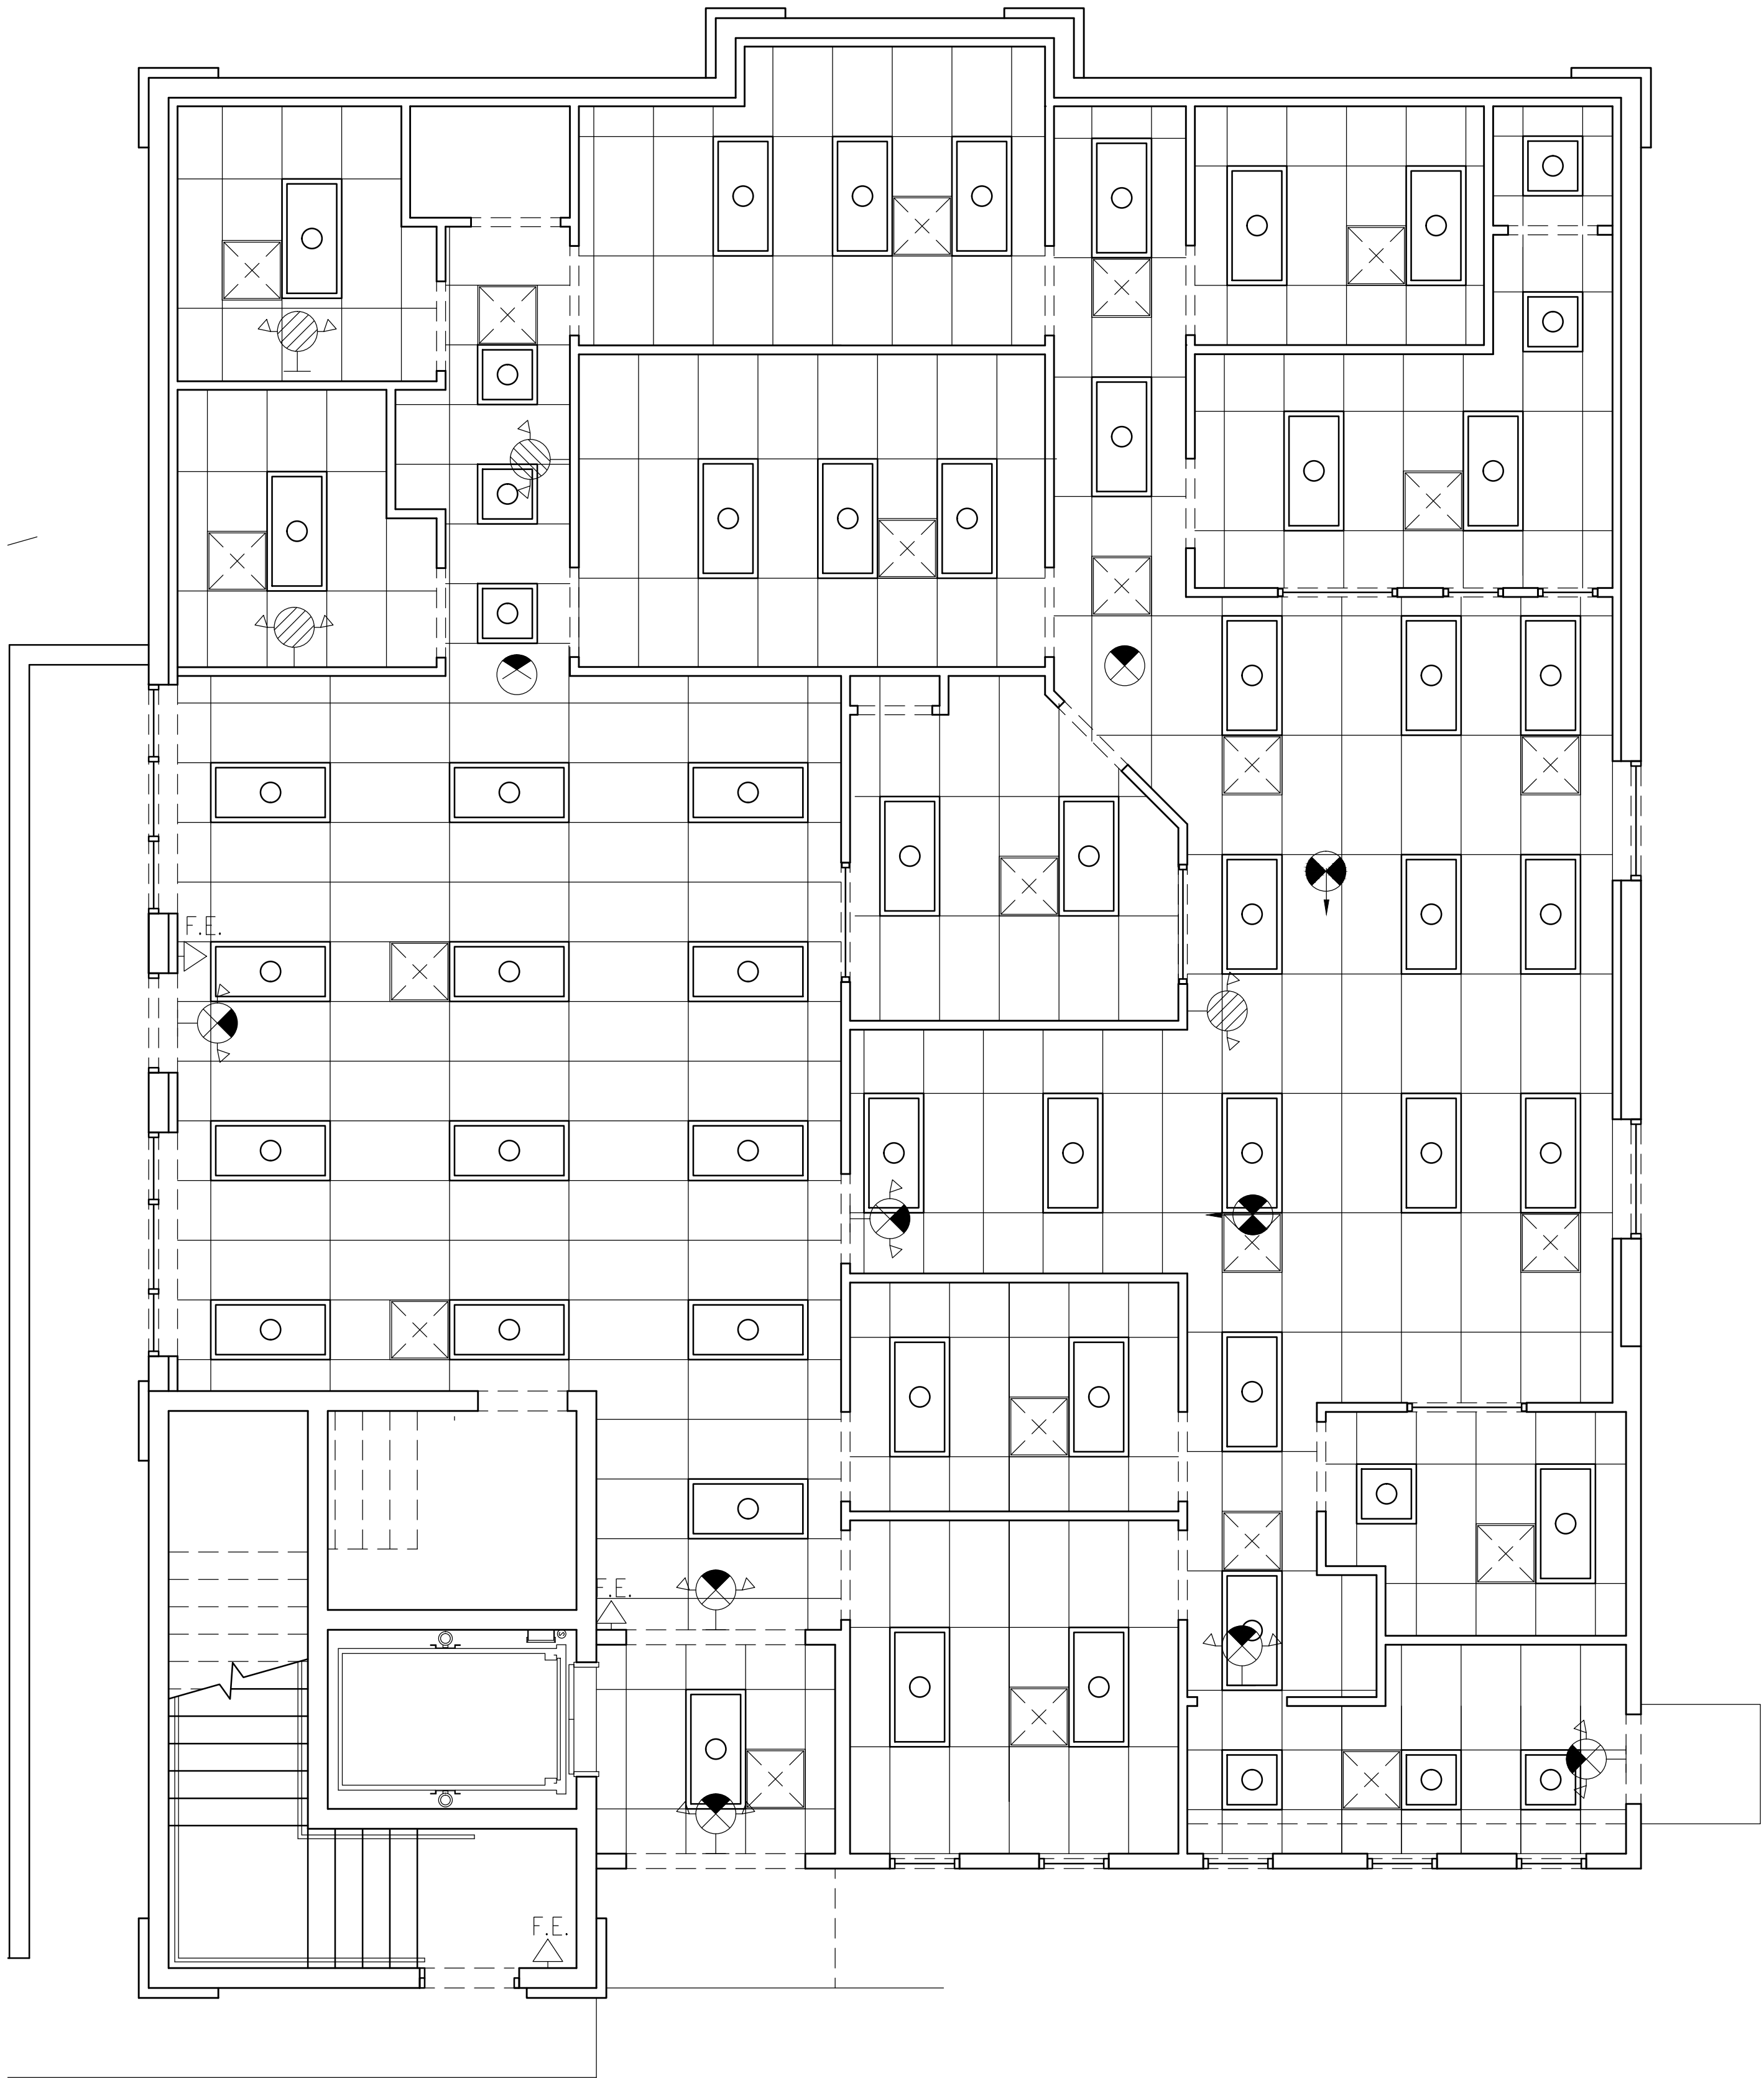

FIRST FLOOR REFLECTED CEILING PLAN

SCALE: 1/4"=1'-0"

SEAL

REVISIONS	
DATE	REMARKS
4-08-17	AREA OF REFUGE ADDED
6-06-17	OWNER CHANGES

ISSUED FOR
PERMIT
3-10-17

THIS DRAWING IS THE PROPERTY OF
S.E. Wagner, Architect
4252 MANOR DRIVE
MARSHALL, VA 20115
p.540.364.6399
f.540.364.0446
sewma@aol.com

1304 SAVANNAH RD
LEWES, DE 19958
p.302.644.8884
f.302.644.8885
design@delmarva@verizon.net

© 2014 S.E. WAGNER, ARCHITECT


CHURCH ROAD ANIMAL HOSPITAL
45441 RURITAN CIRCLE

STERLING VIRGINIA

FIRST FLOOR REFLECTED CEILING PLAN

DATE 1-17-17	SHEET NO. A
FILE 1	

©2014 DESIGN DELMARVA / S.E. WAGNER, ARCHITECT EXPRESSLY RESERVES ITS COMMON LAW COPYRIGHT AND OTHER PROPERTY RIGHTS IN THESE PLANS. THESE PLANS ARE NOT TO BE REPRODUCED, CHANGED OR COPIED IN ANY FORM OR MANNER WHATSOEVER. NONE ARE THEY TO BE ASSIGNED TO ANY THIRD PARTY WITHOUT FIRST OBTAINING THE EXPRESS WRITTEN PERMISSION AND CONSENT OF DESIGN DELMARVA / S.E. WAGNER, ARCHITECT.

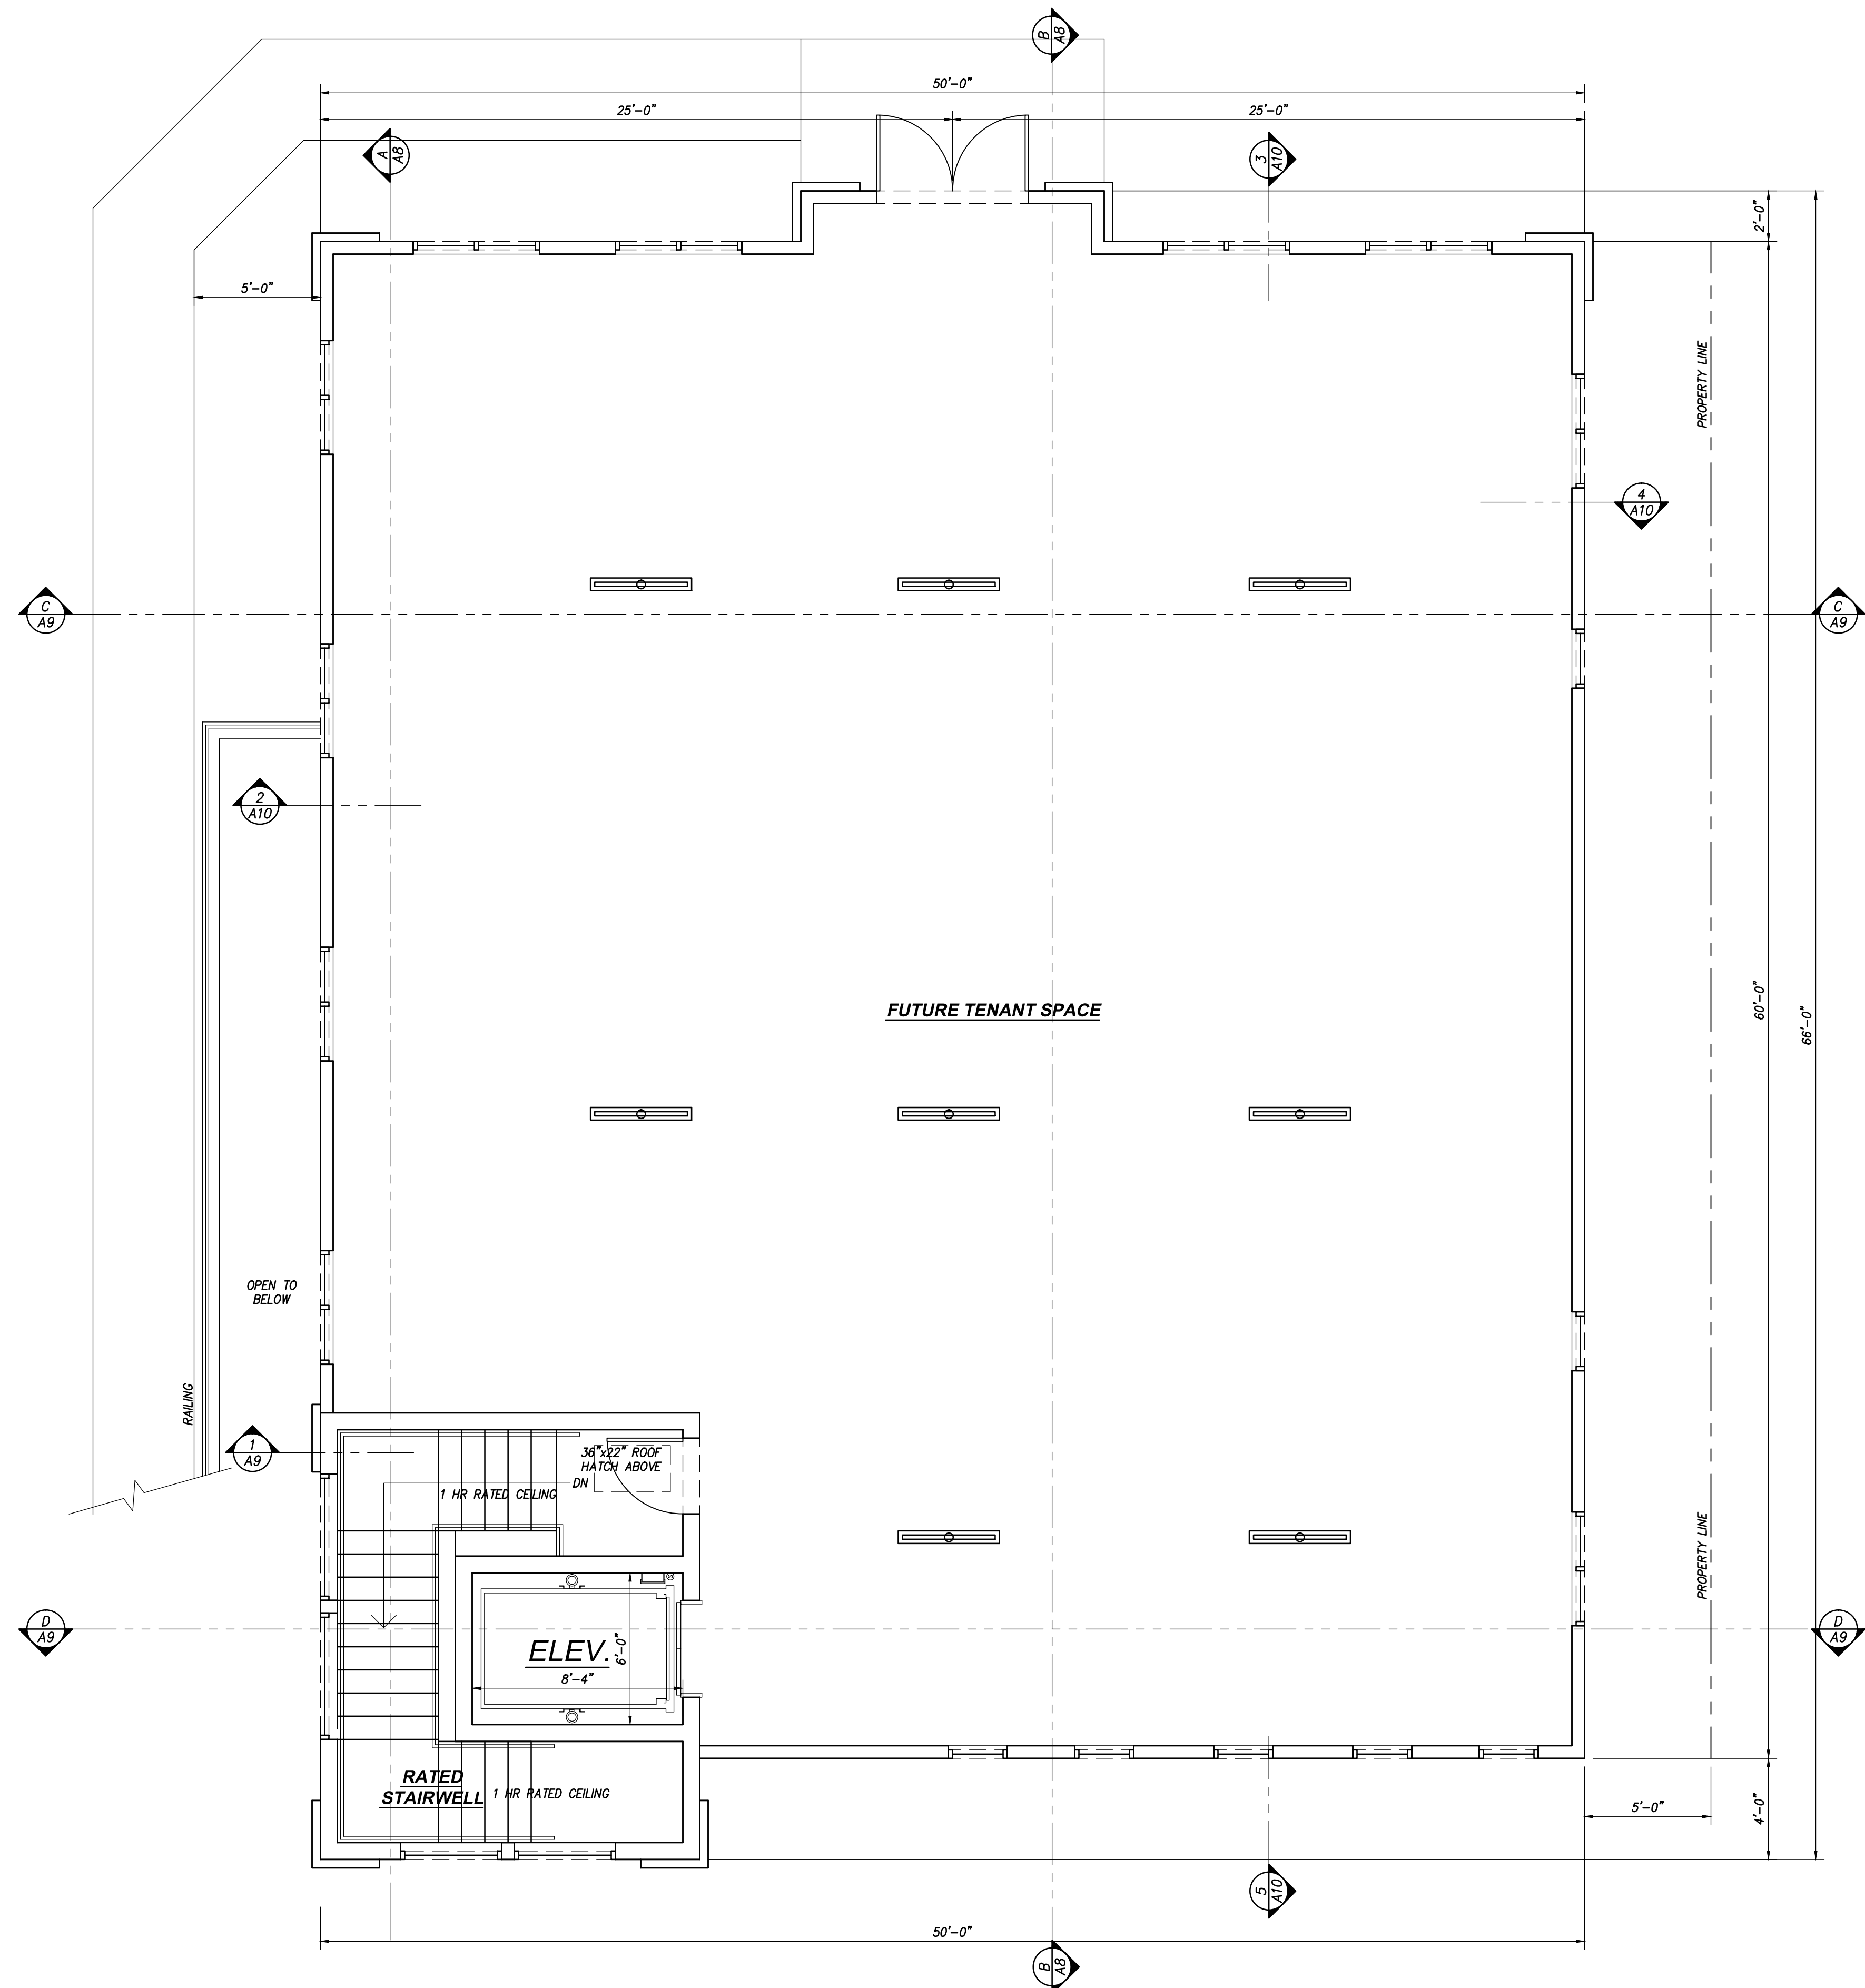

SECOND FLOOR REFLECTED CEILING PLAN

SCALE: 1/4"=1'-0"

SEAL

REVISIONS	
DATE	REMARKS
4-08-17	AREA OF REFUGE ADDED
6-06-17	OWNER CHANGES

ISSUED FOR
PERMIT
3-10-17

THIS DRAWING IS THE PROPERTY OF
S.E. Wagner, Architect
1304 SAVANNAH RD
LEWES, DE 19958
p.302.644.8884
f.302.644.8885
design@delmarva@verizon.net
4252 MANOR DRIVE
MARSHALL, VA 20115
p.540.364.6399
f.540.364.0446
sewain@aol.com
© 2014 S.E. WAGNER, ARCHITECT


CHURCH ROAD ANIMAL HOSPITAL
45441 RURITAN CIRCLE
STERLING

VIRGINIA


SECOND FLOOR
REFLECTED CEILING PLAN

DATE 1-17-17	SHEET NO. A
FILE 1	


©2014 DESIGN DELMARVA / S.E. WAGNER, ARCHITECT EXPRESSLY RESERVES ITS COMMON LAW COPYRIGHT AND OTHER PROPERTY RIGHTS IN THESE PLANS. THESE PLANS ARE NOT TO BE REPRODUCED, CHANGED OR COPIED IN ANY FORM OR MANNER WHATSOEVER, NOR ARE THEY TO BE ASSIGNED TO ANY THIRD PARTY WITHOUT FIRST OBTAINING THE EXPRESS WRITTEN PERMISSION AND CONSENT OF DESIGN DELMARVA / S.E. WAGNER, ARCHITECT.

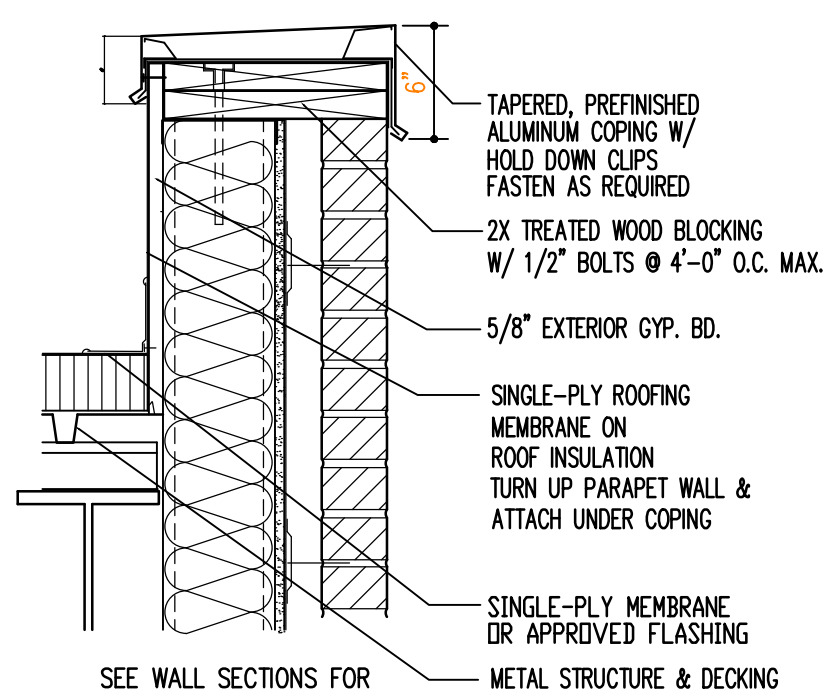


1 PARAPET DETAIL
1 1/2" = 1'-0"

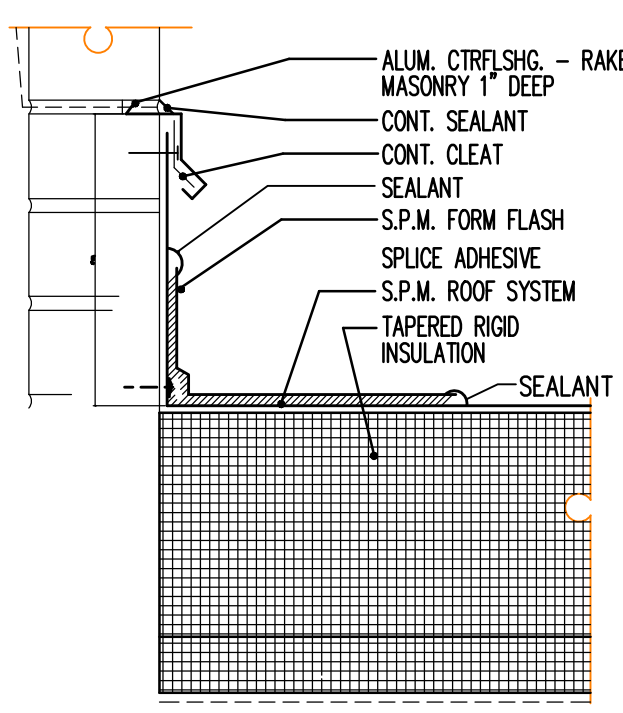


2 FLASHING DETAIL
3" = 1'-0"

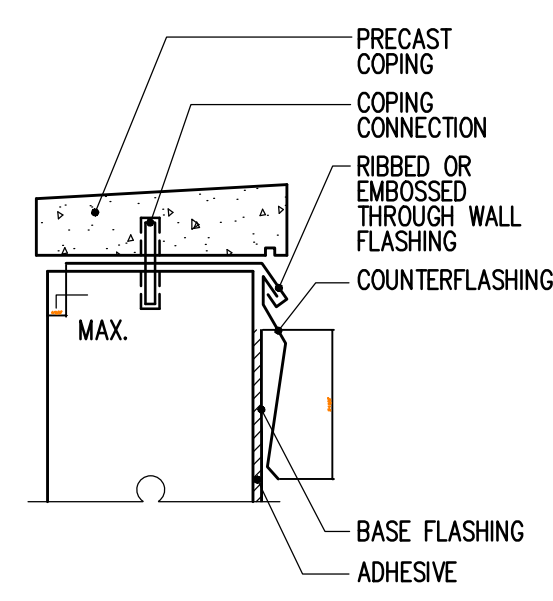


4 COPING DETAIL (ALTERNATE)
3" = 1'-0"

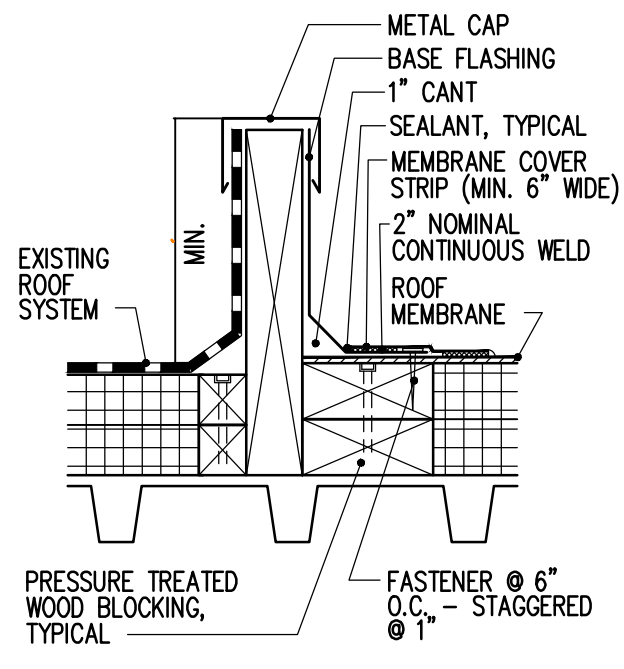


6 CURB DETAIL
3" = 1'-0"

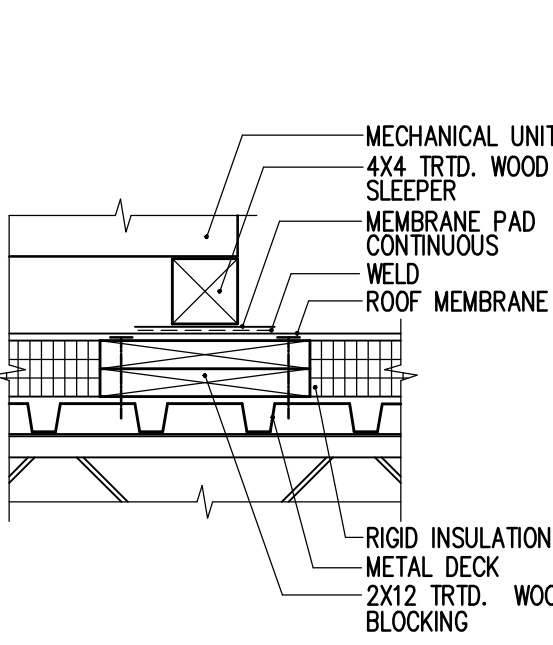


8 MECH. SUPPORT DETAIL
1 1/2" = 1'-0"

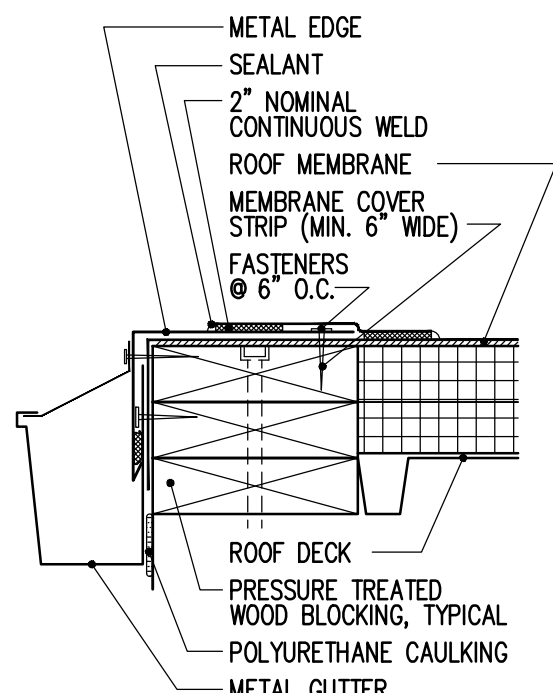


3 GUTTER DETAIL
3" = 1'-0"

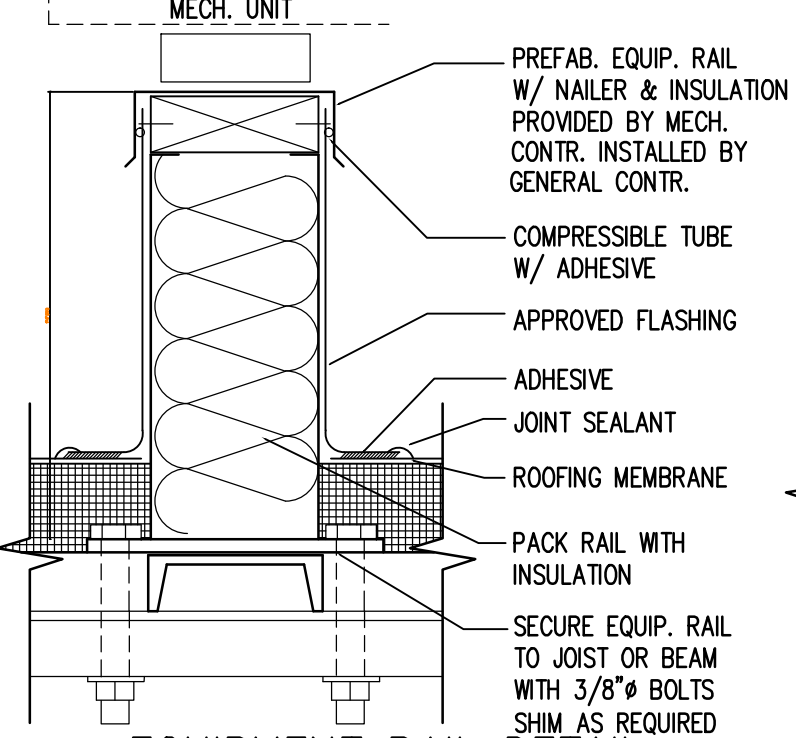


1 EQUIPMENT RAIL DETAIL
3" = 1'-0"

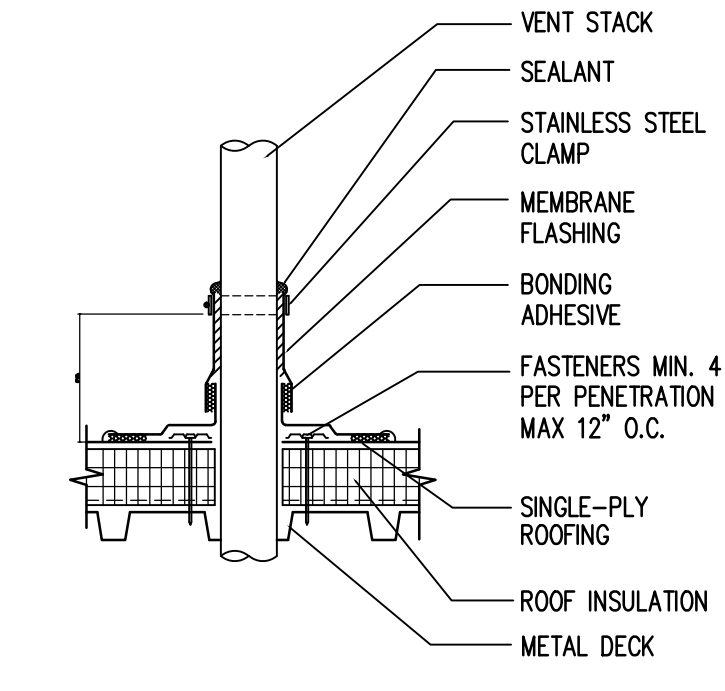


3 VENT PENETRATION DETAIL
1 1/2" = 1'-0"

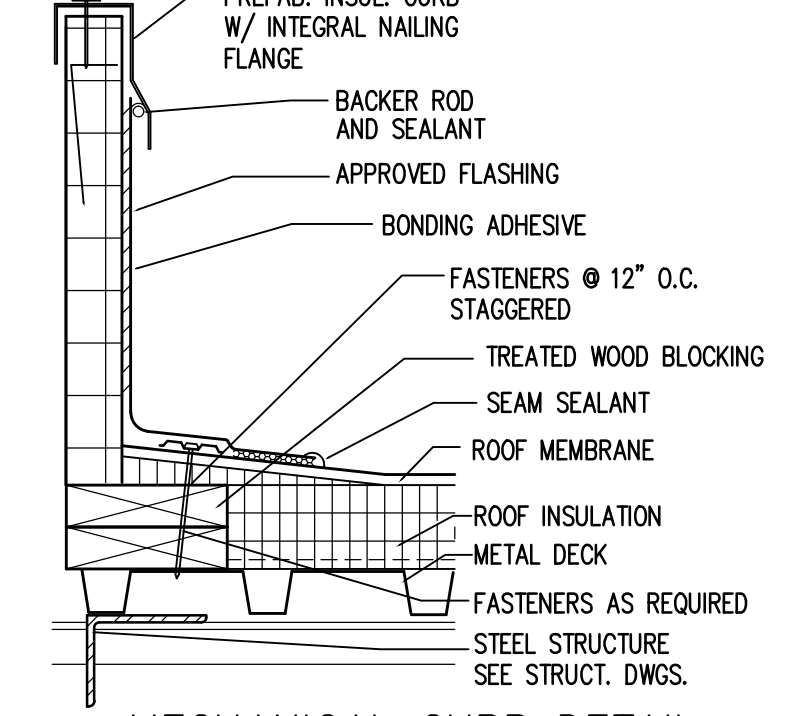


5 MECHANICAL CURB DETAIL
3" = 1'-0"

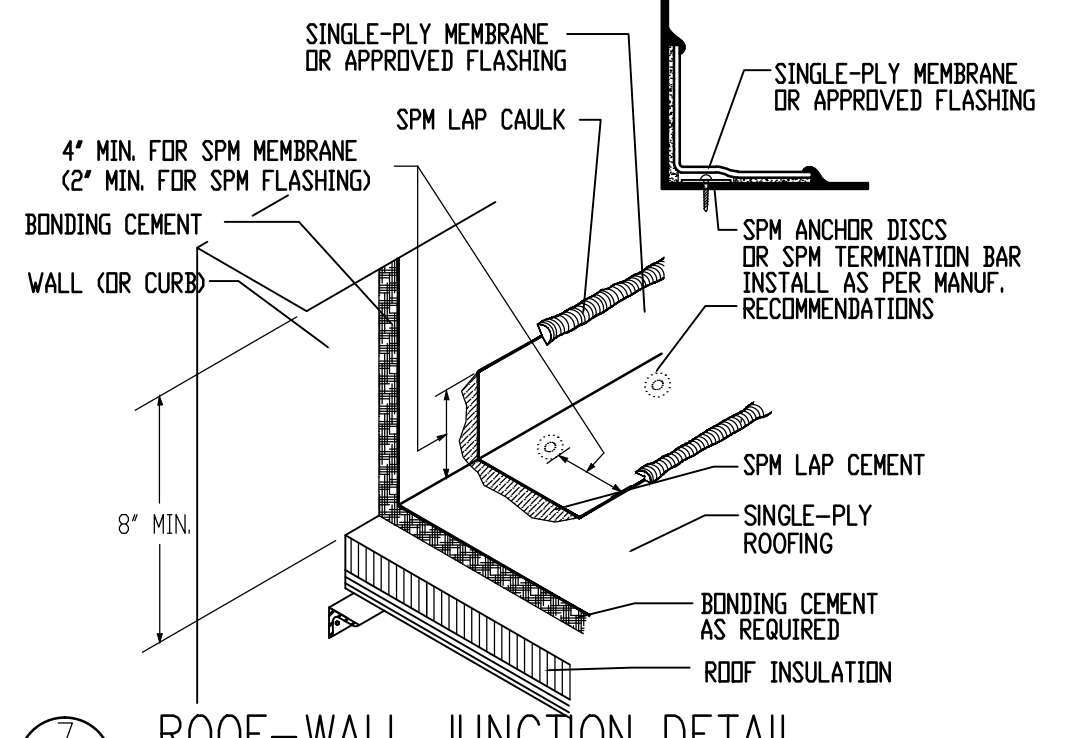


7 ROOF-WALL JUNCTION DETAIL
N.T.S.

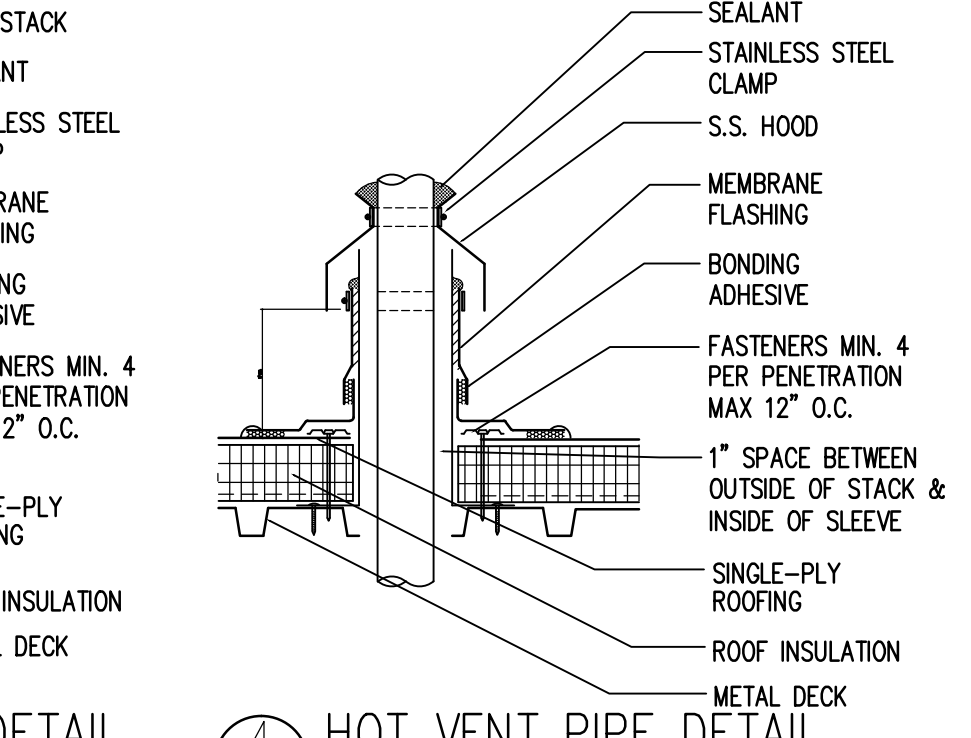

4 HOT VENT PIPE DETAIL
1 1/2" = 1'-0"

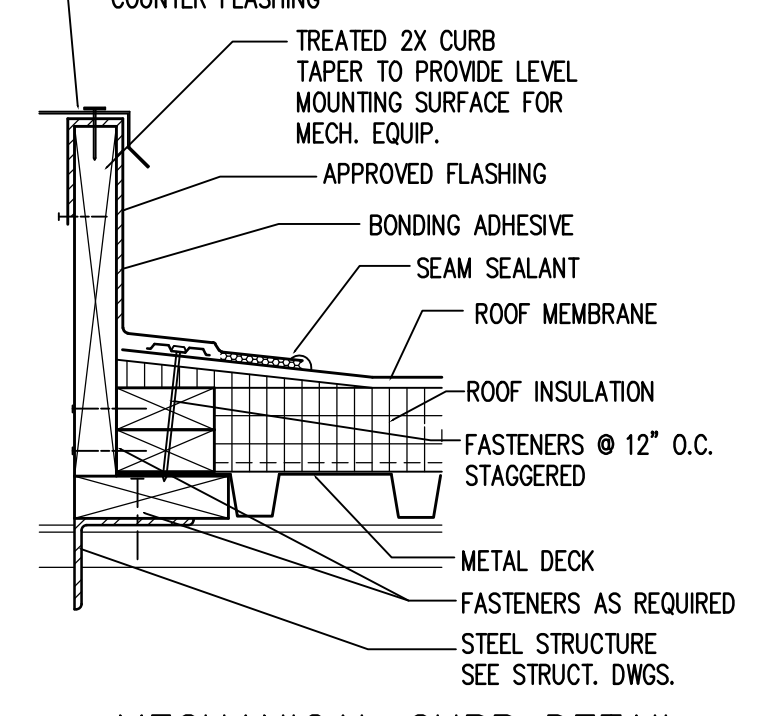


6 MECHANICAL CURB DETAIL
1 1/2" = 1'-0"

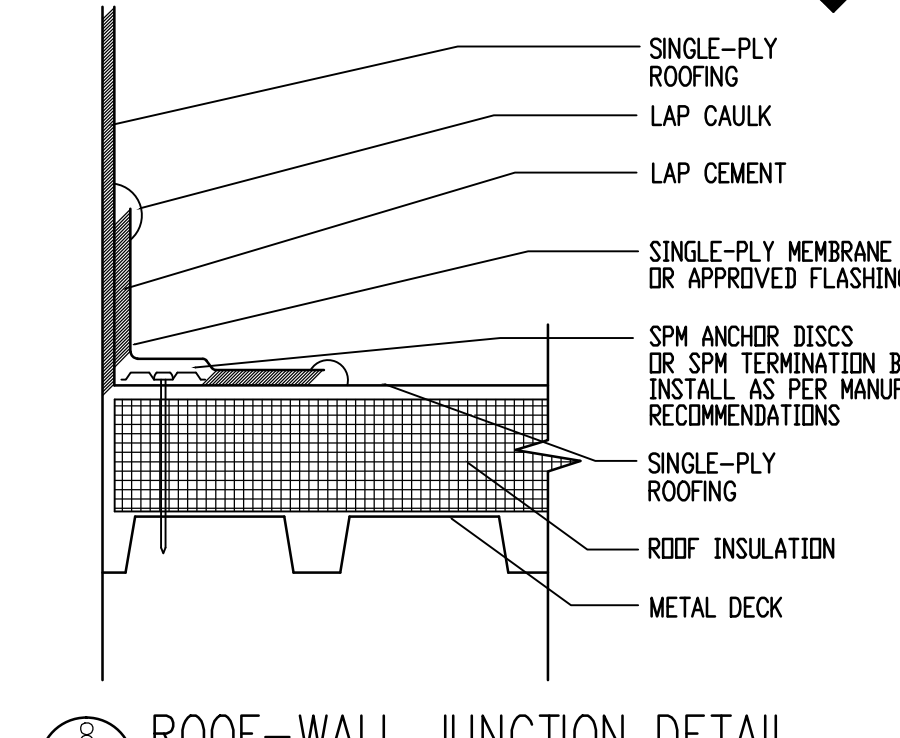


8 ROOF-WALL JUNCTION DETAIL
3" = 1'-0"

5 COPING DETAIL
3" = 1'-0"

7 MECH. SUPPORT DETAIL
1 1/2" = 1'-0"

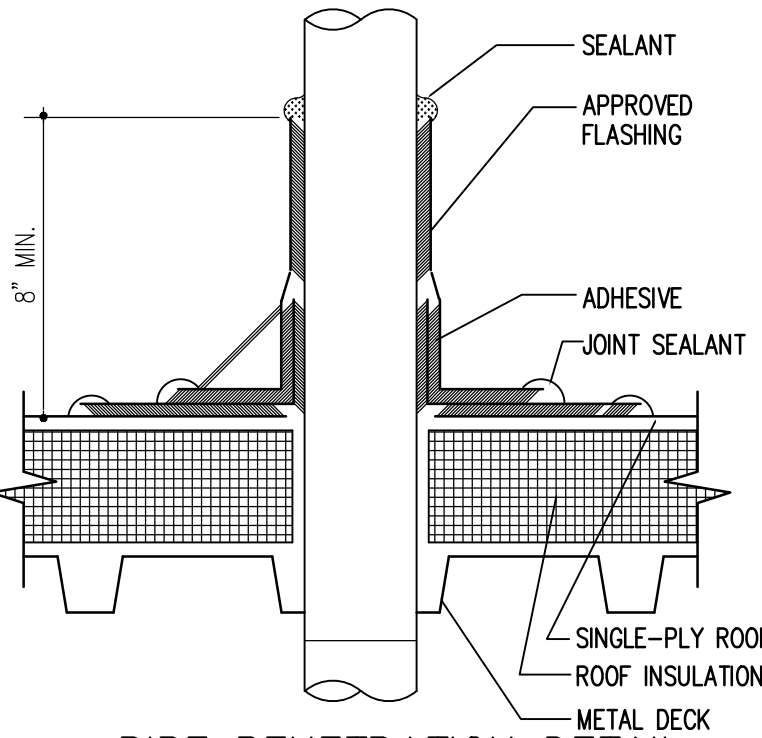

2 PIPE PENETRATION DETAIL
3" = 1'-0"

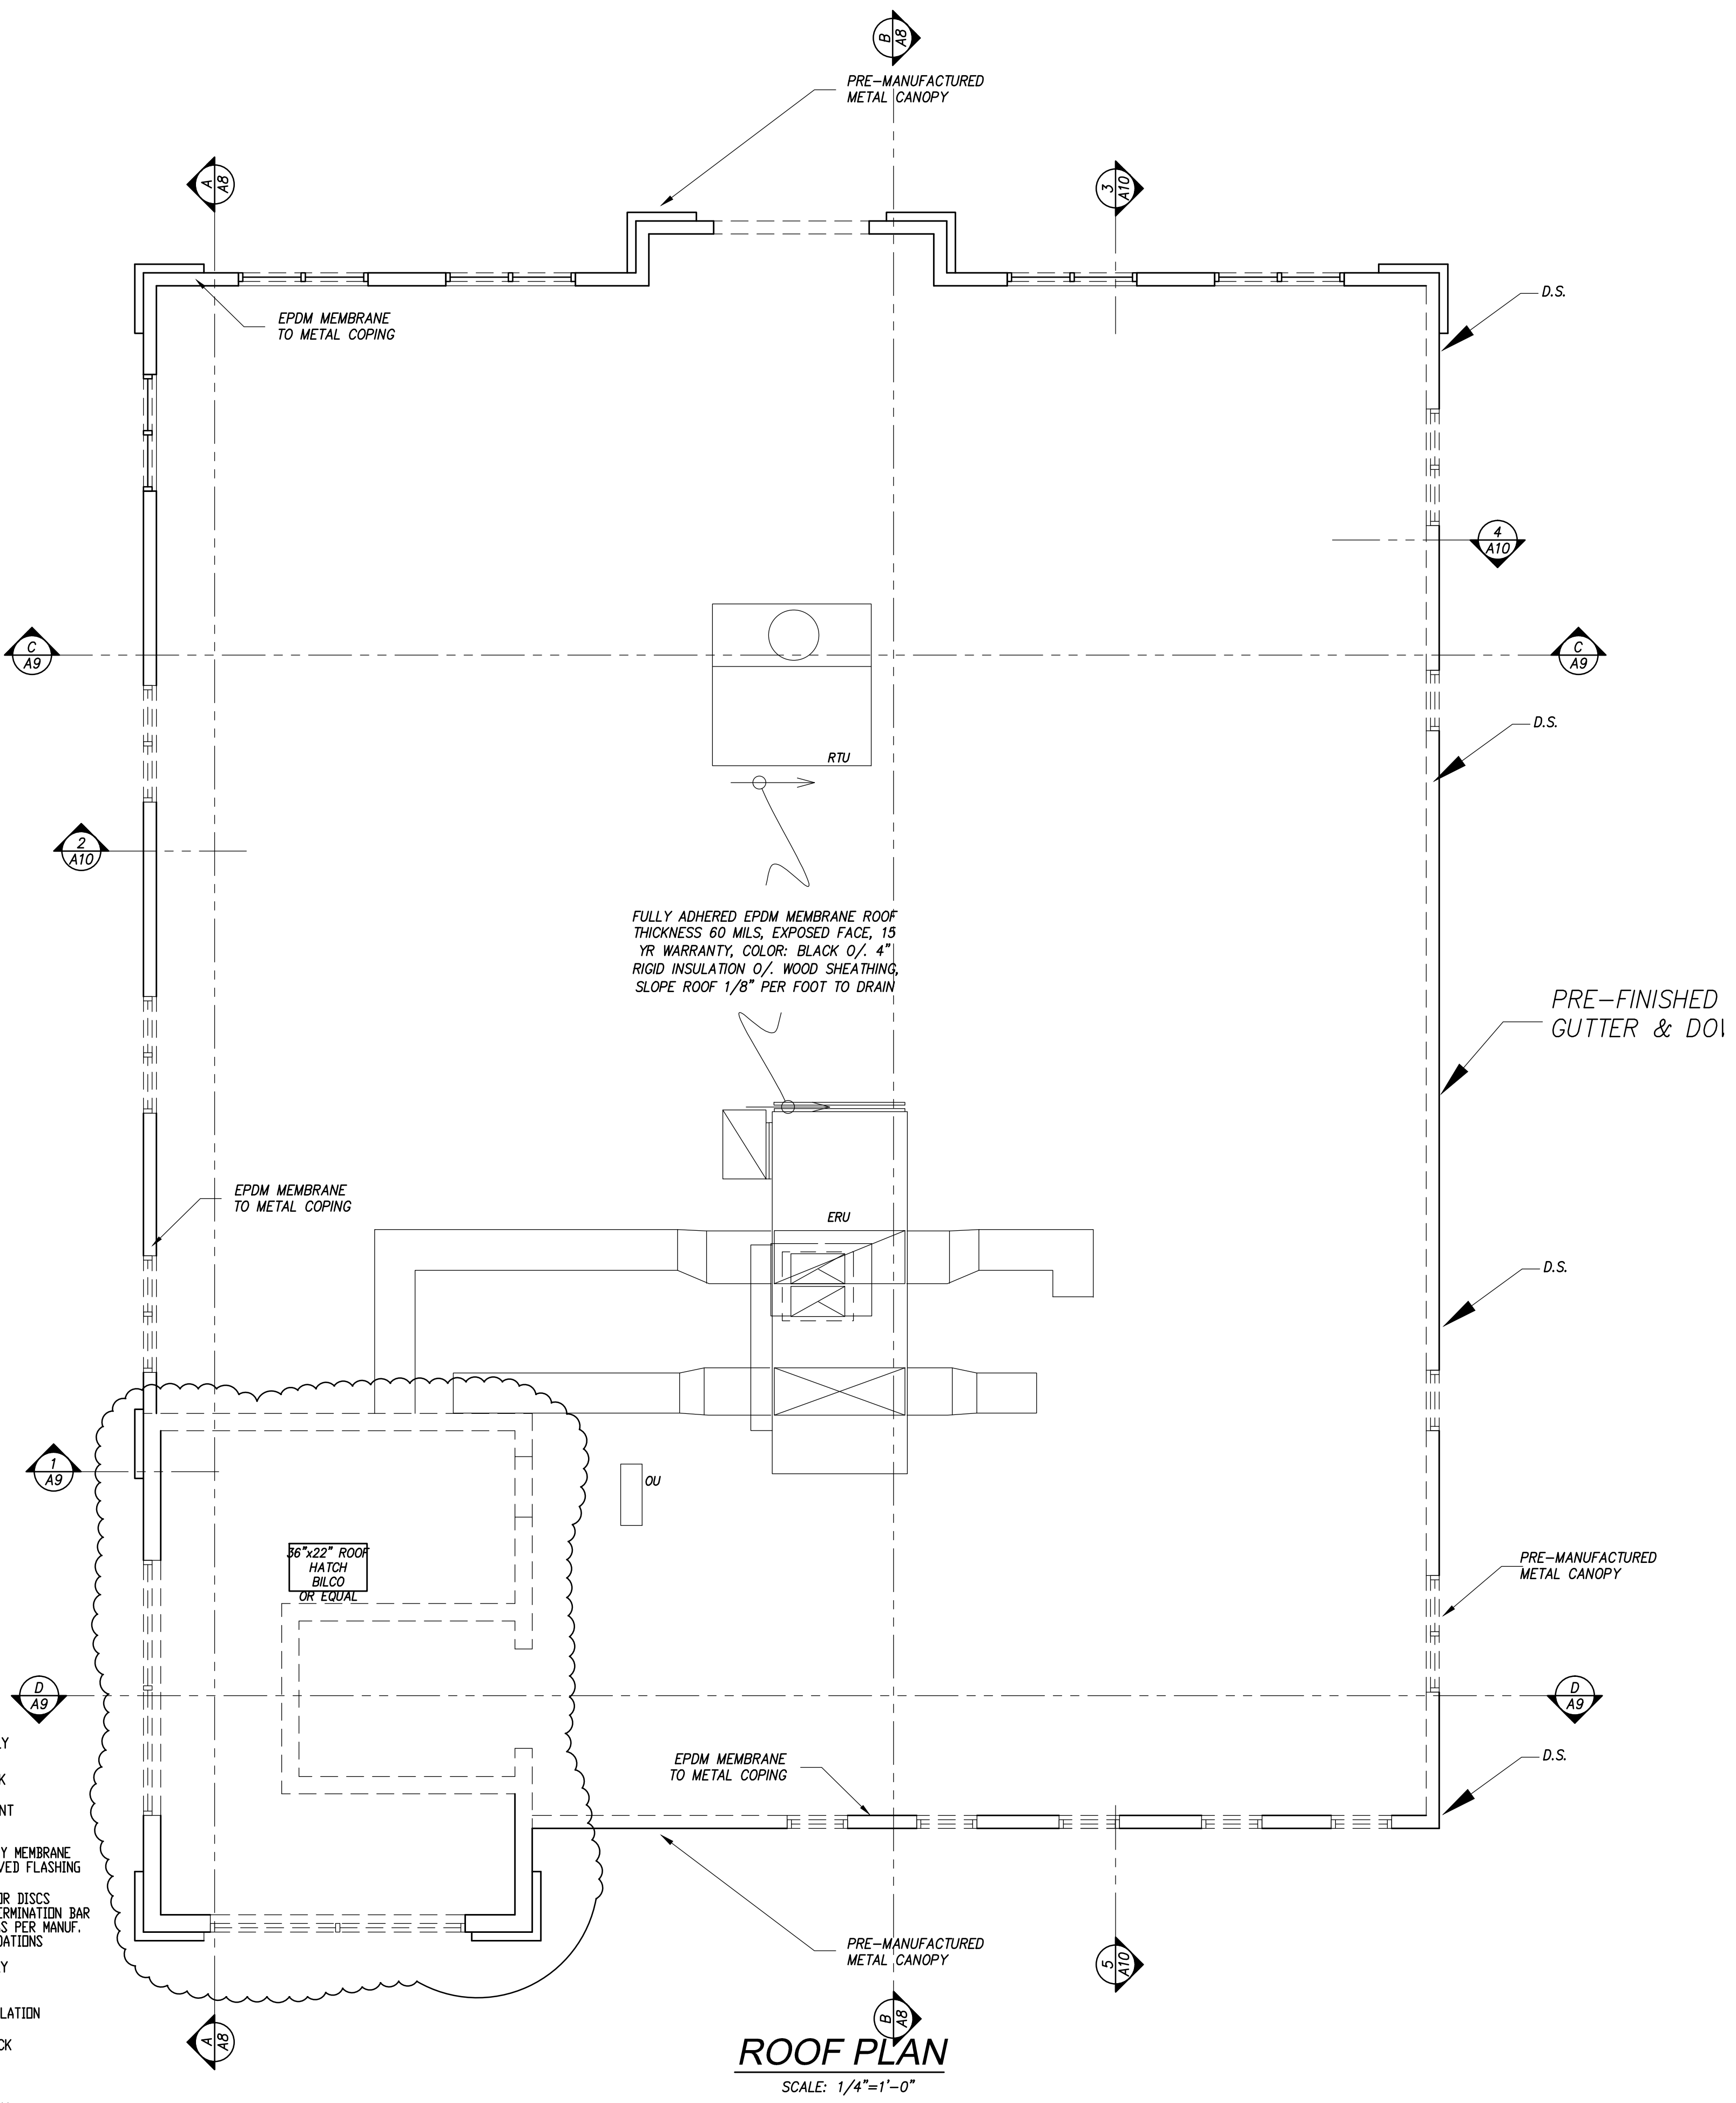

ROOF PLAN
SCALE: 1/4"=1'-0"

SEAL

REVISIONS	
DATE	REMARKS
4-08-17	AREA OF REFUGE ADDED

ISSUED FOR PERMIT
3-10-17


THIS DRAWING IS THE PROPERTY OF
S.E. Wagner, Architect
1304 SAVANNAH RD
LEWES, DE 19958
p.302.644.8884
f.302.644.8885
sewain@aol.com
design@delmarva.com
© 2014 S.E. WAGNER, ARCHITECT

4232 MANOR DRIVE
MARSHALL, VA 20115
p.540.364.6399
f.540.364.0446
sewain@aol.com


CHURCH ROAD ANIMAL HOSPITAL
45441 RURITAN CIRCLE
STERLING VIRGINIA
ROOF PLAN

DATE 1-17-17	SHEET NO. A7
FILE -	

©2014 DESIGN DELMARVA / S.E. WAGNER, ARCHITECT EXPRESSLY RESERVES ITS COMMON LAW COPYRIGHT AND OTHER PROPERTY RIGHTS IN THESE PLANS. THESE PLANS ARE NOT TO BE REPRODUCED, CHANGED OR COPIED IN ANY FORM OR MANNER WHATSOEVER. NORE ARE THEY TO BE ASSIGNED TO ANY THIRD PARTY WITHOUT FIRST OBTAINING THE EXPRESS WRITTEN PERMISSION AND CONSENT OF DESIGN DELMARVA / S.E. WAGNER, ARCHITECT.

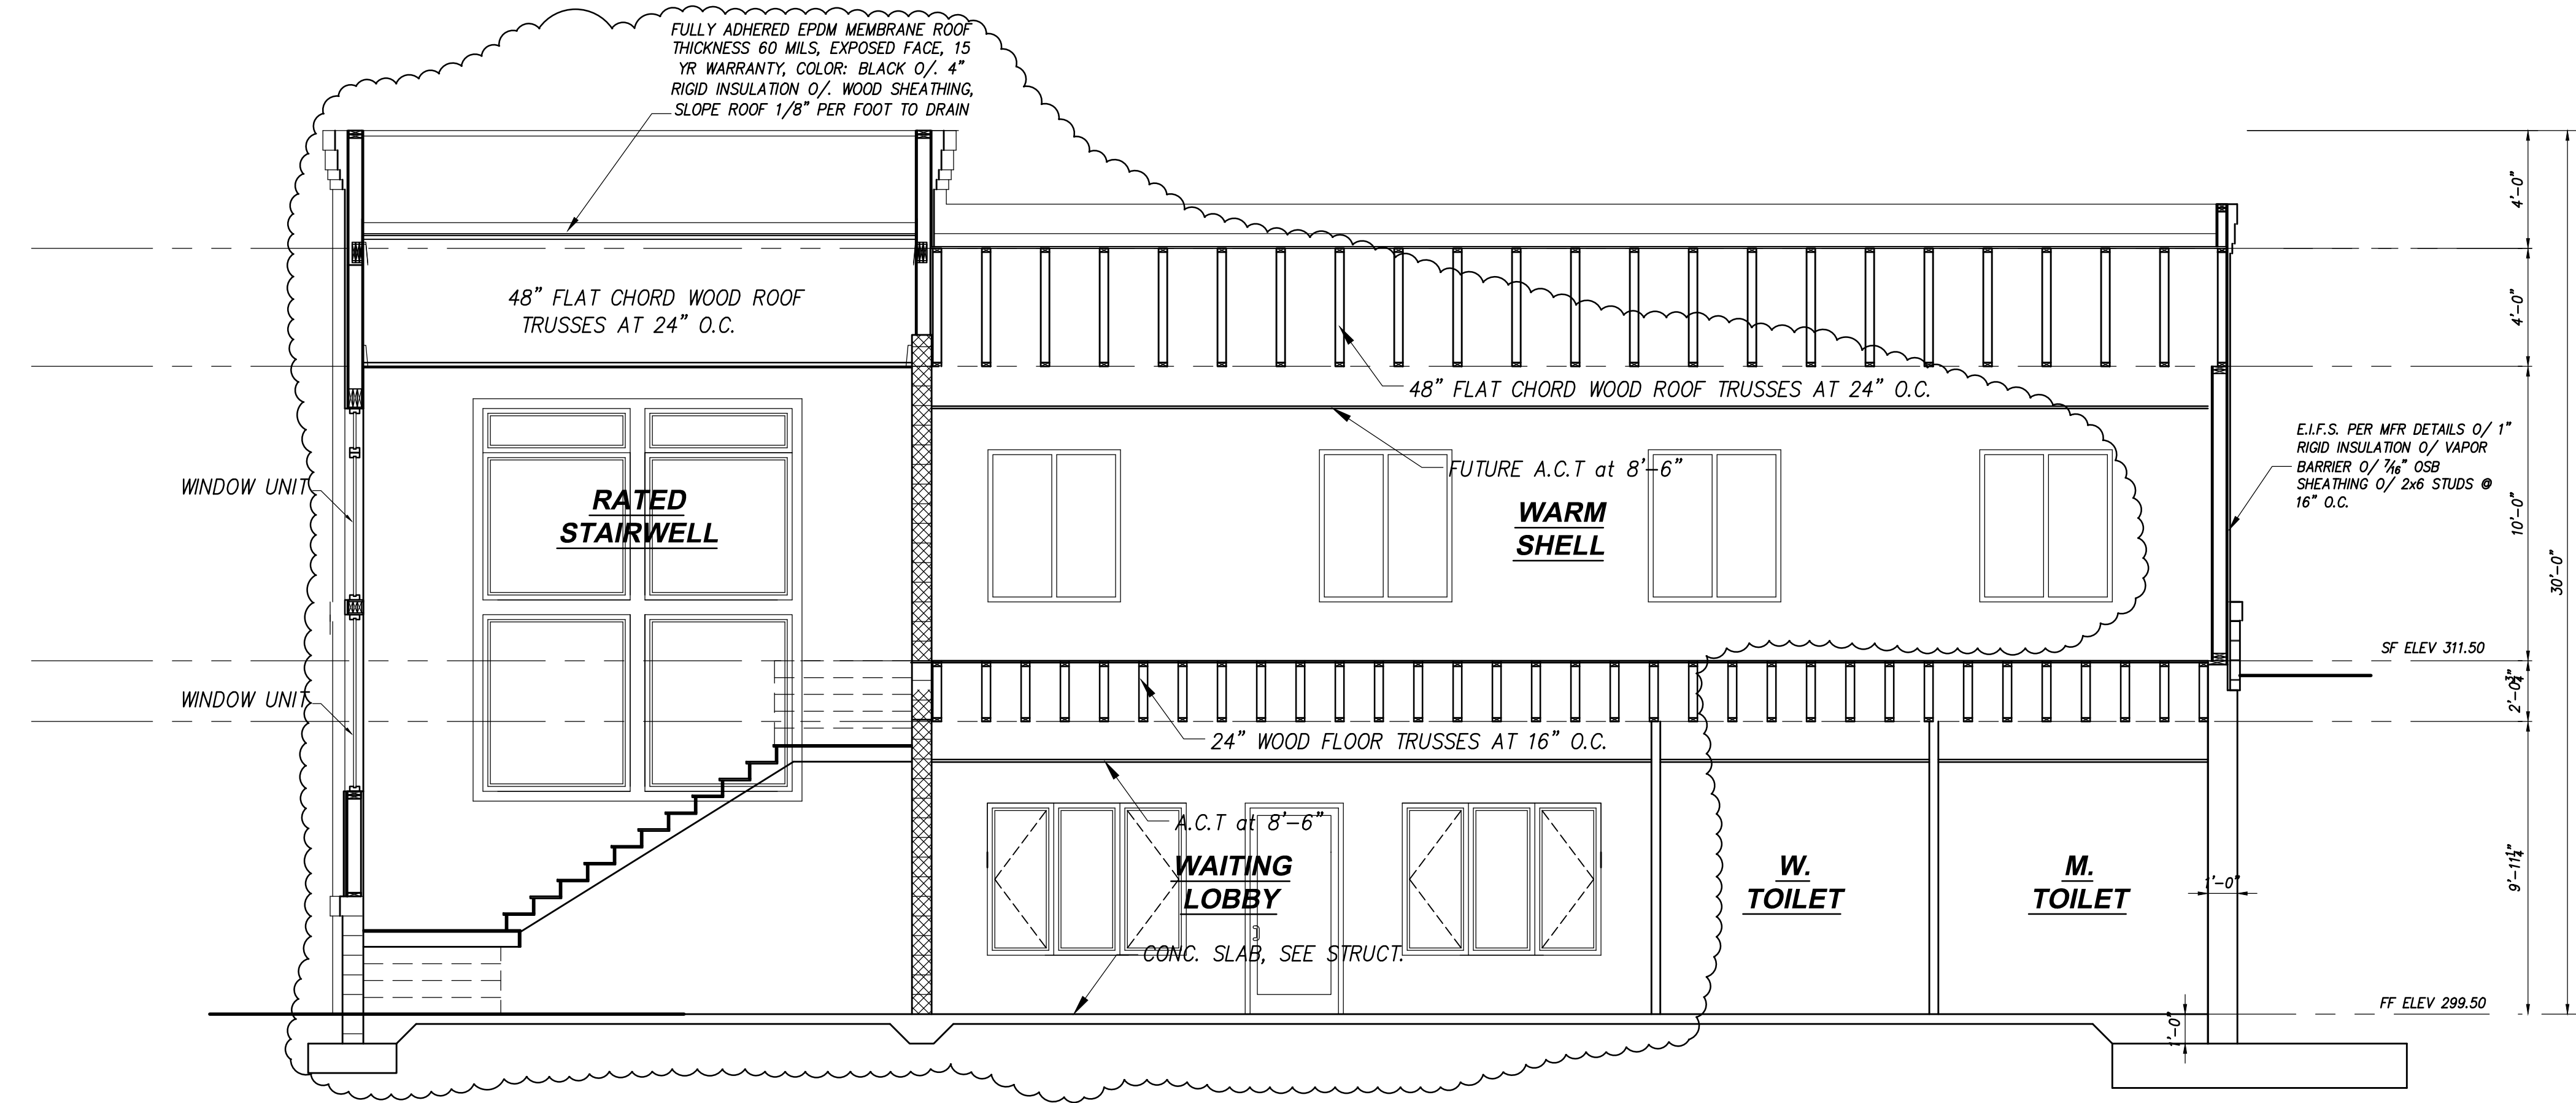

CROSS SECTION A
SCALE: 1/4"=1'-0"

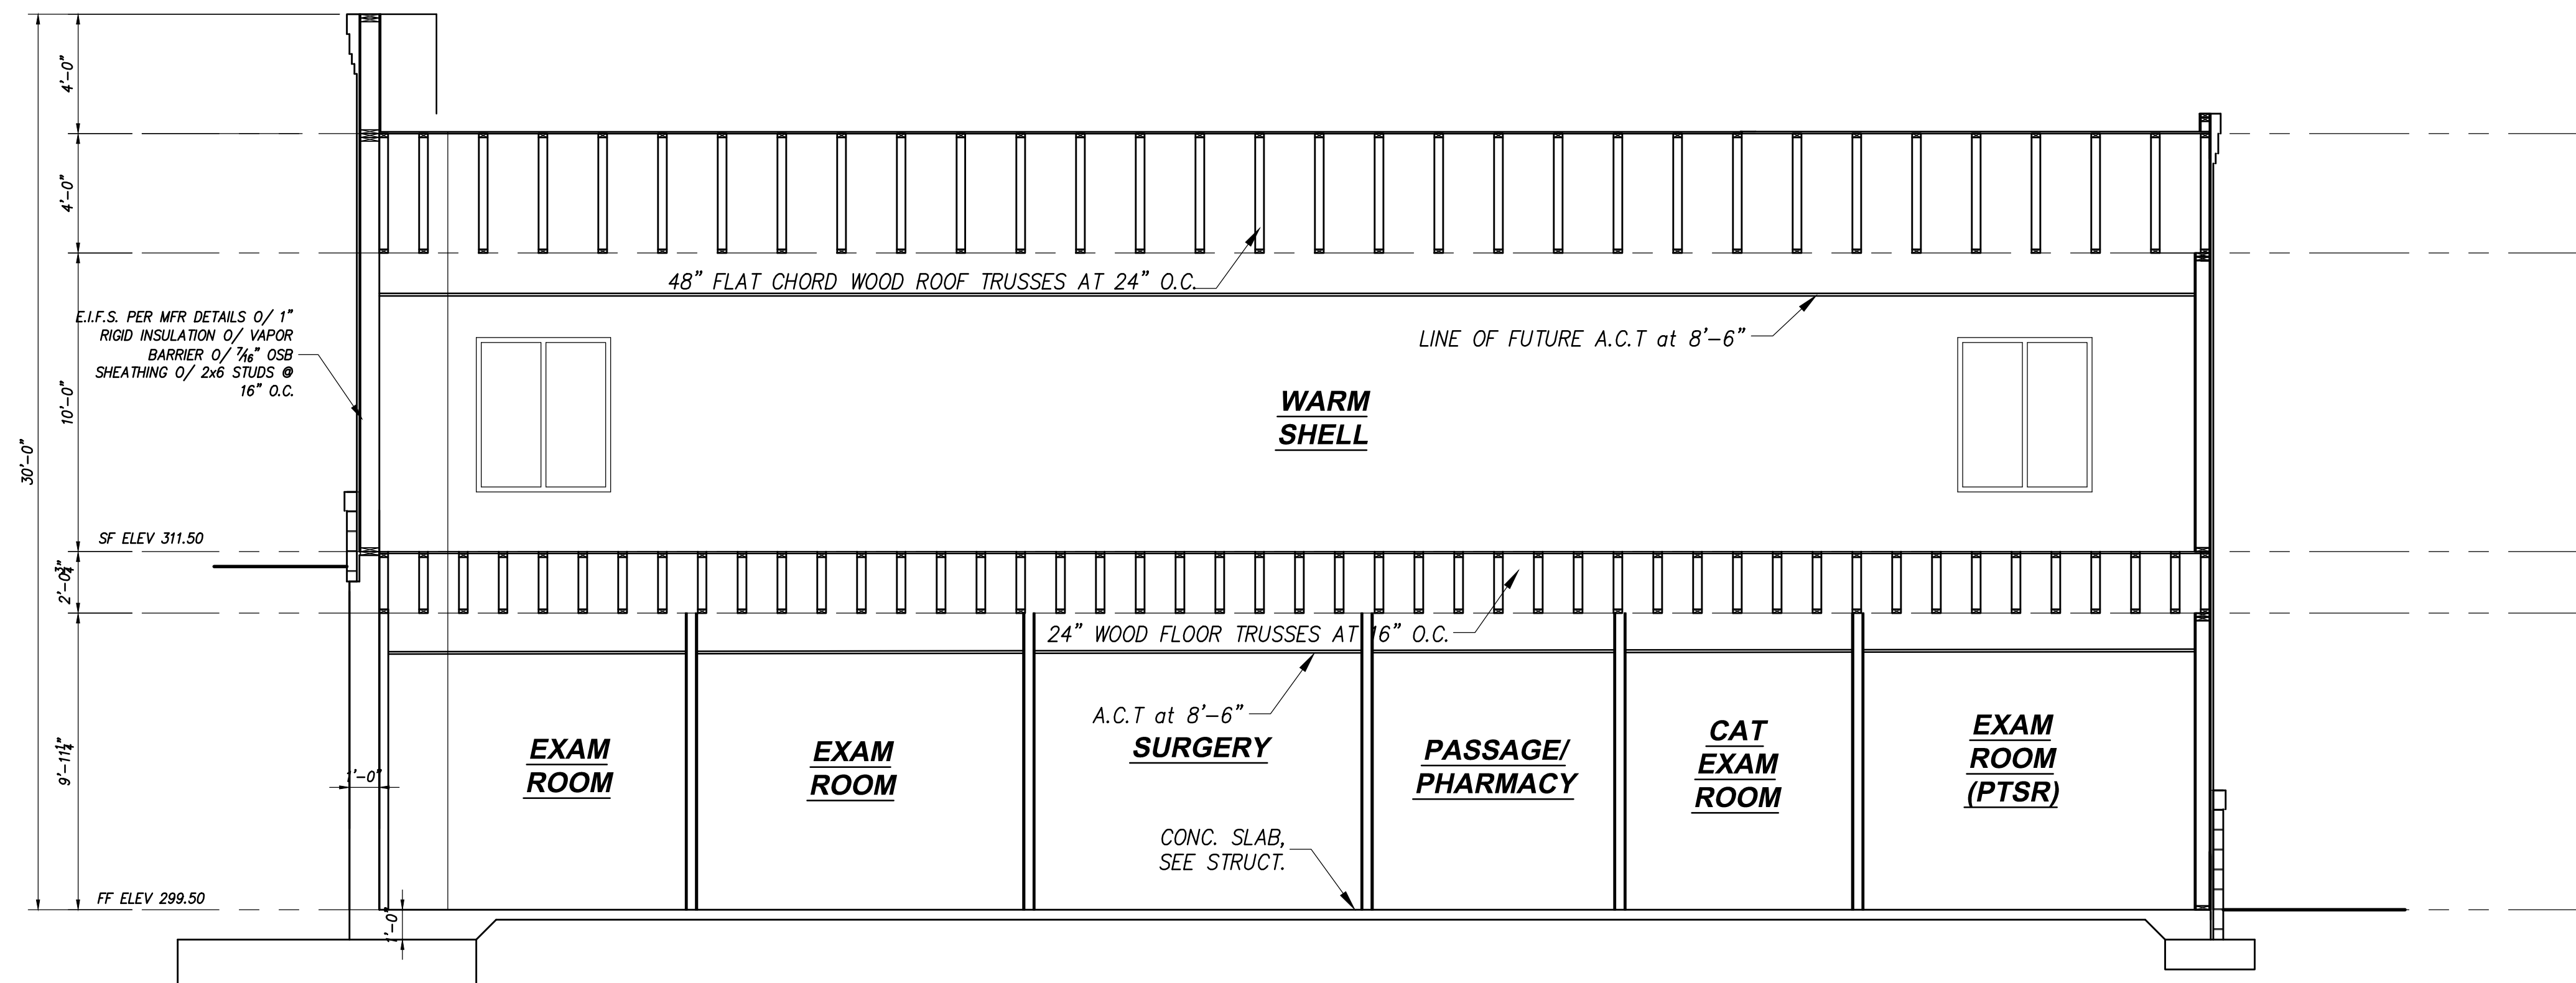

CROSS SECTION B
SCALE: 1/4"=1'-0"

SEAL

REVISIONS	
DATE	REMARKS
4-08-17	AREA OF REFUGE ADDED
6-06-17	OWNER CHANGES

ISSUED FOR
PERMIT
3-10-17


THIS DRAWING IS THE PROPERTY OF
S.E. Wagner, Architect
1304 SAVANNAH RD
LEWES, DE 19958
p.302.644.8884
f.302.644.8885
design@delmarva.net
sewain@aol.com
© 2014 S.E. WAGNER, ARCHITECT

CHURCH ROAD ANIMAL HOSPITAL
45441 RURITAN CIRCLE
STERLING VIRGINIA


CROSS SECTIONS A & B

DATE 1-17-17	SHEET NO. A
FILE -	


©2014 DESIGN DELMARVA / S.E. WAGNER, ARCHITECT EXPRESSLY RESERVES ITS COMMON LAW COPYRIGHT AND OTHER PROPERTY RIGHTS IN THESE PLANS. THESE PLANS ARE NOT TO BE REPRODUCED, CHANGED OR COPIED IN ANY FORM OR MANNER WHATSOEVER. NONE ARE THEY TO BE ASSIGNED TO ANY THIRD PARTY WITHOUT FIRST OBTAINING THE EXPRESS WRITTEN PERMISSION AND CONSENT OF DESIGN DELMARVA / S.E. WAGNER, ARCHITECT.

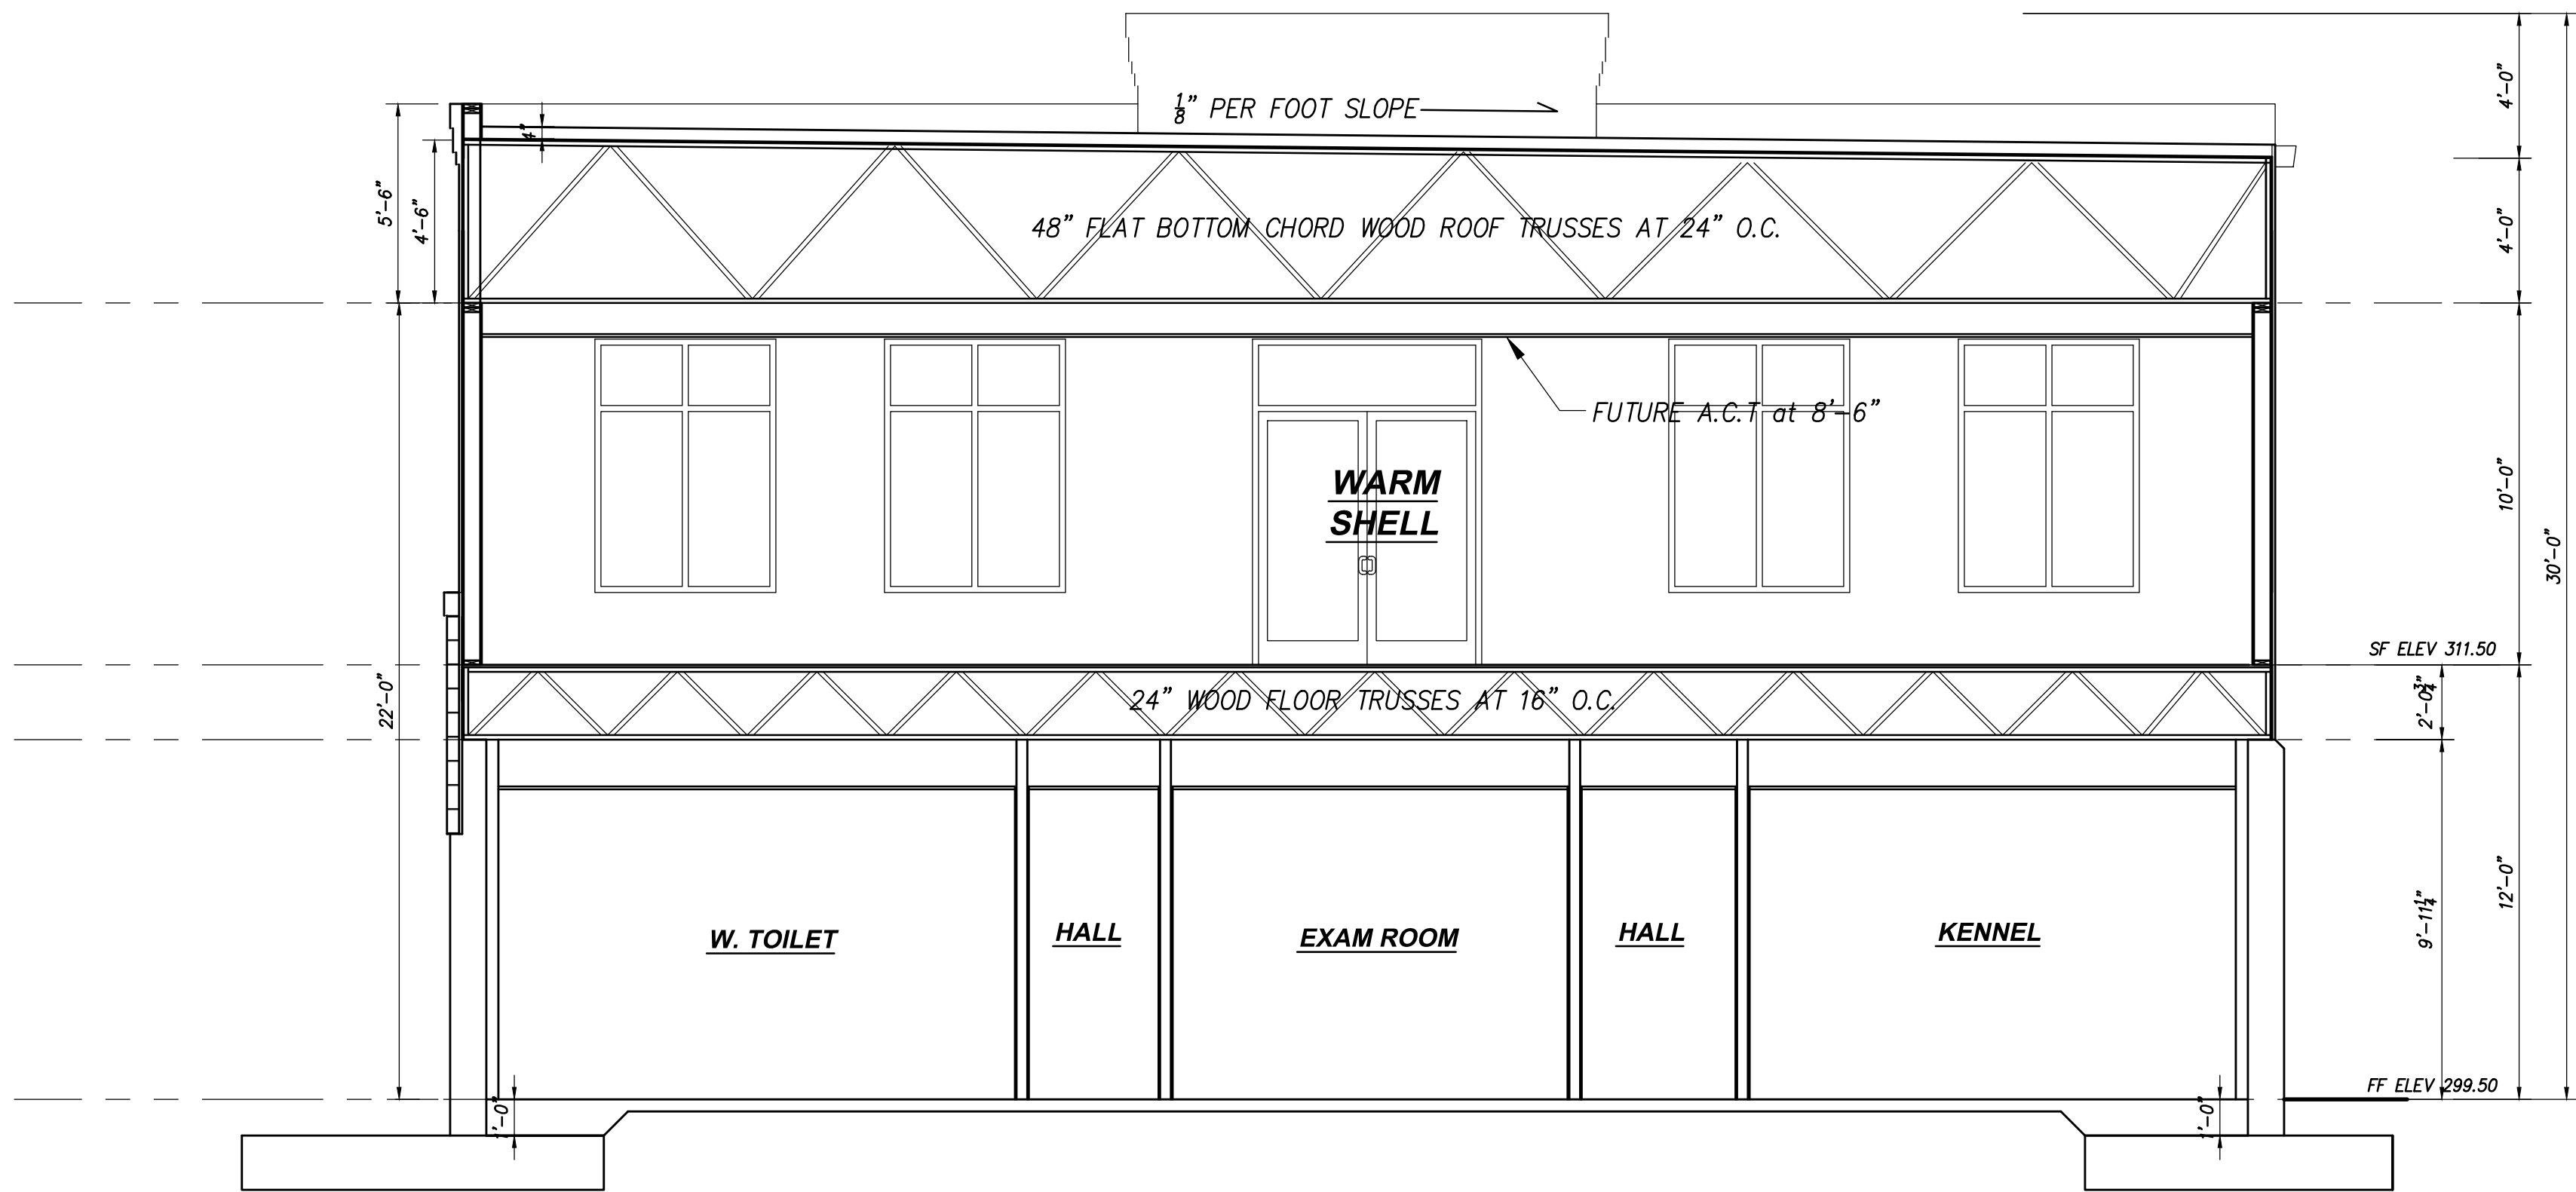

CROSS SECTION C
SCALE: 1/4"=1'-0"

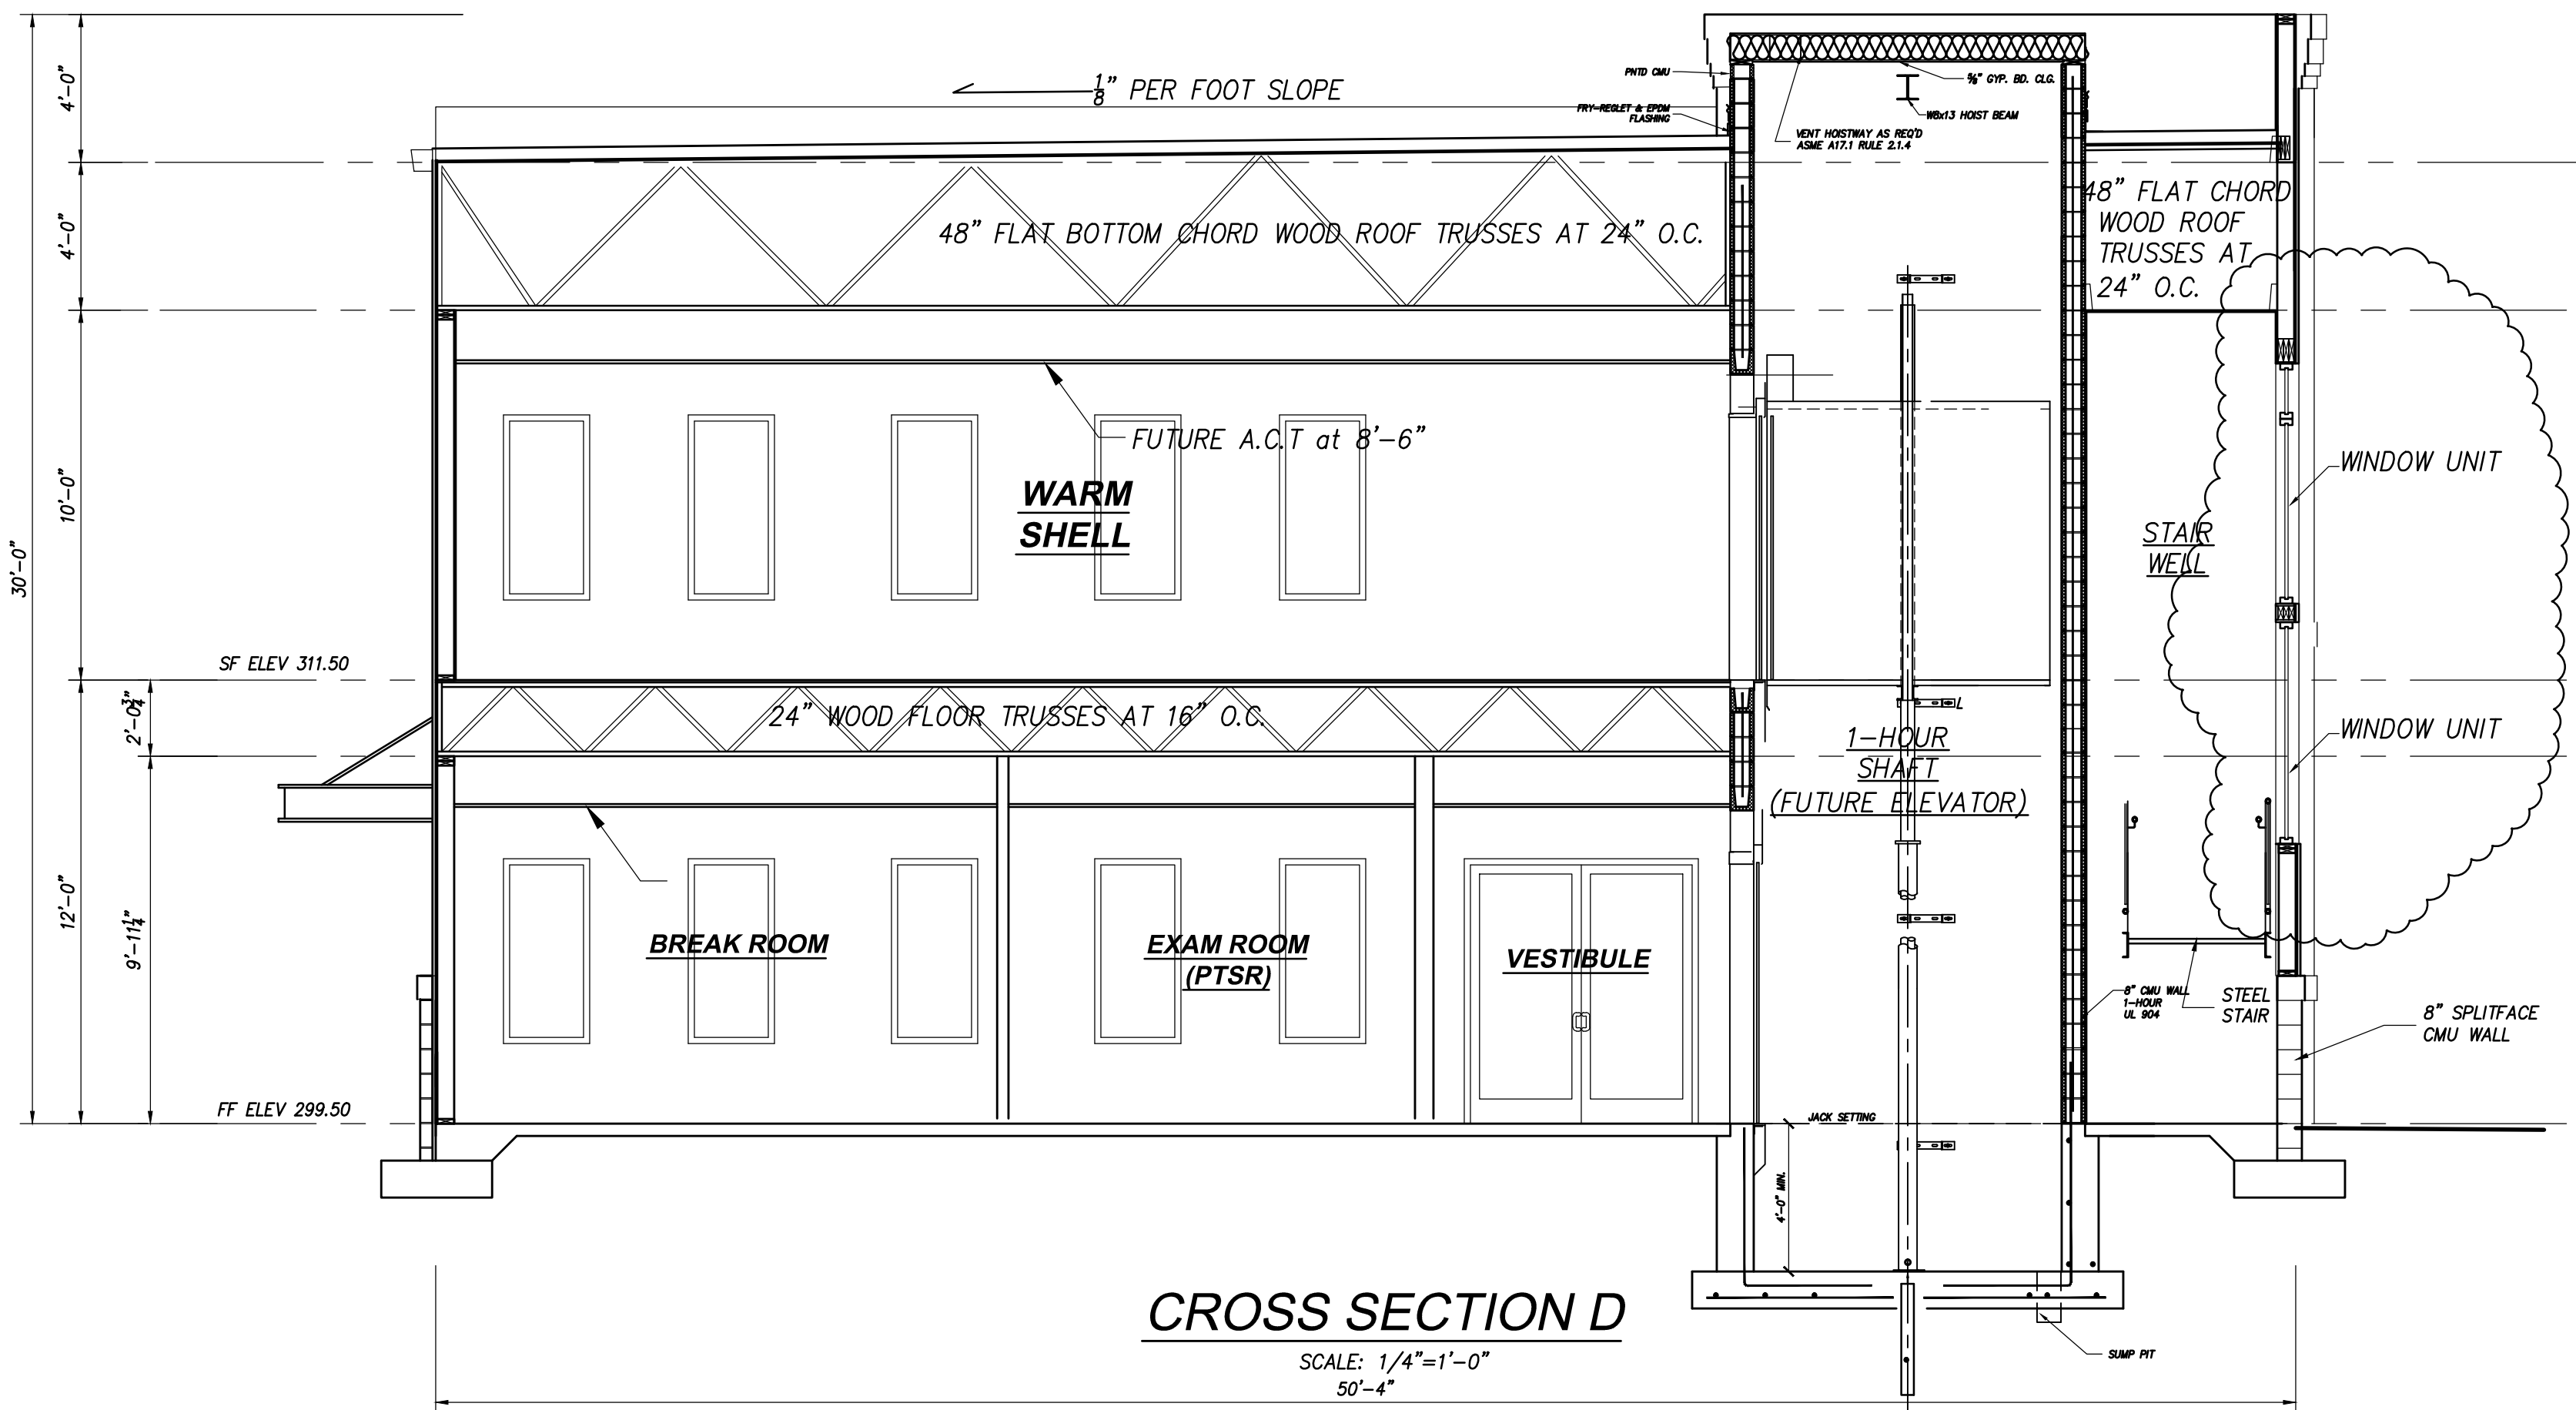

CROSS SECTION D
SCALE: 1/4"=1'-0"
50'-4"

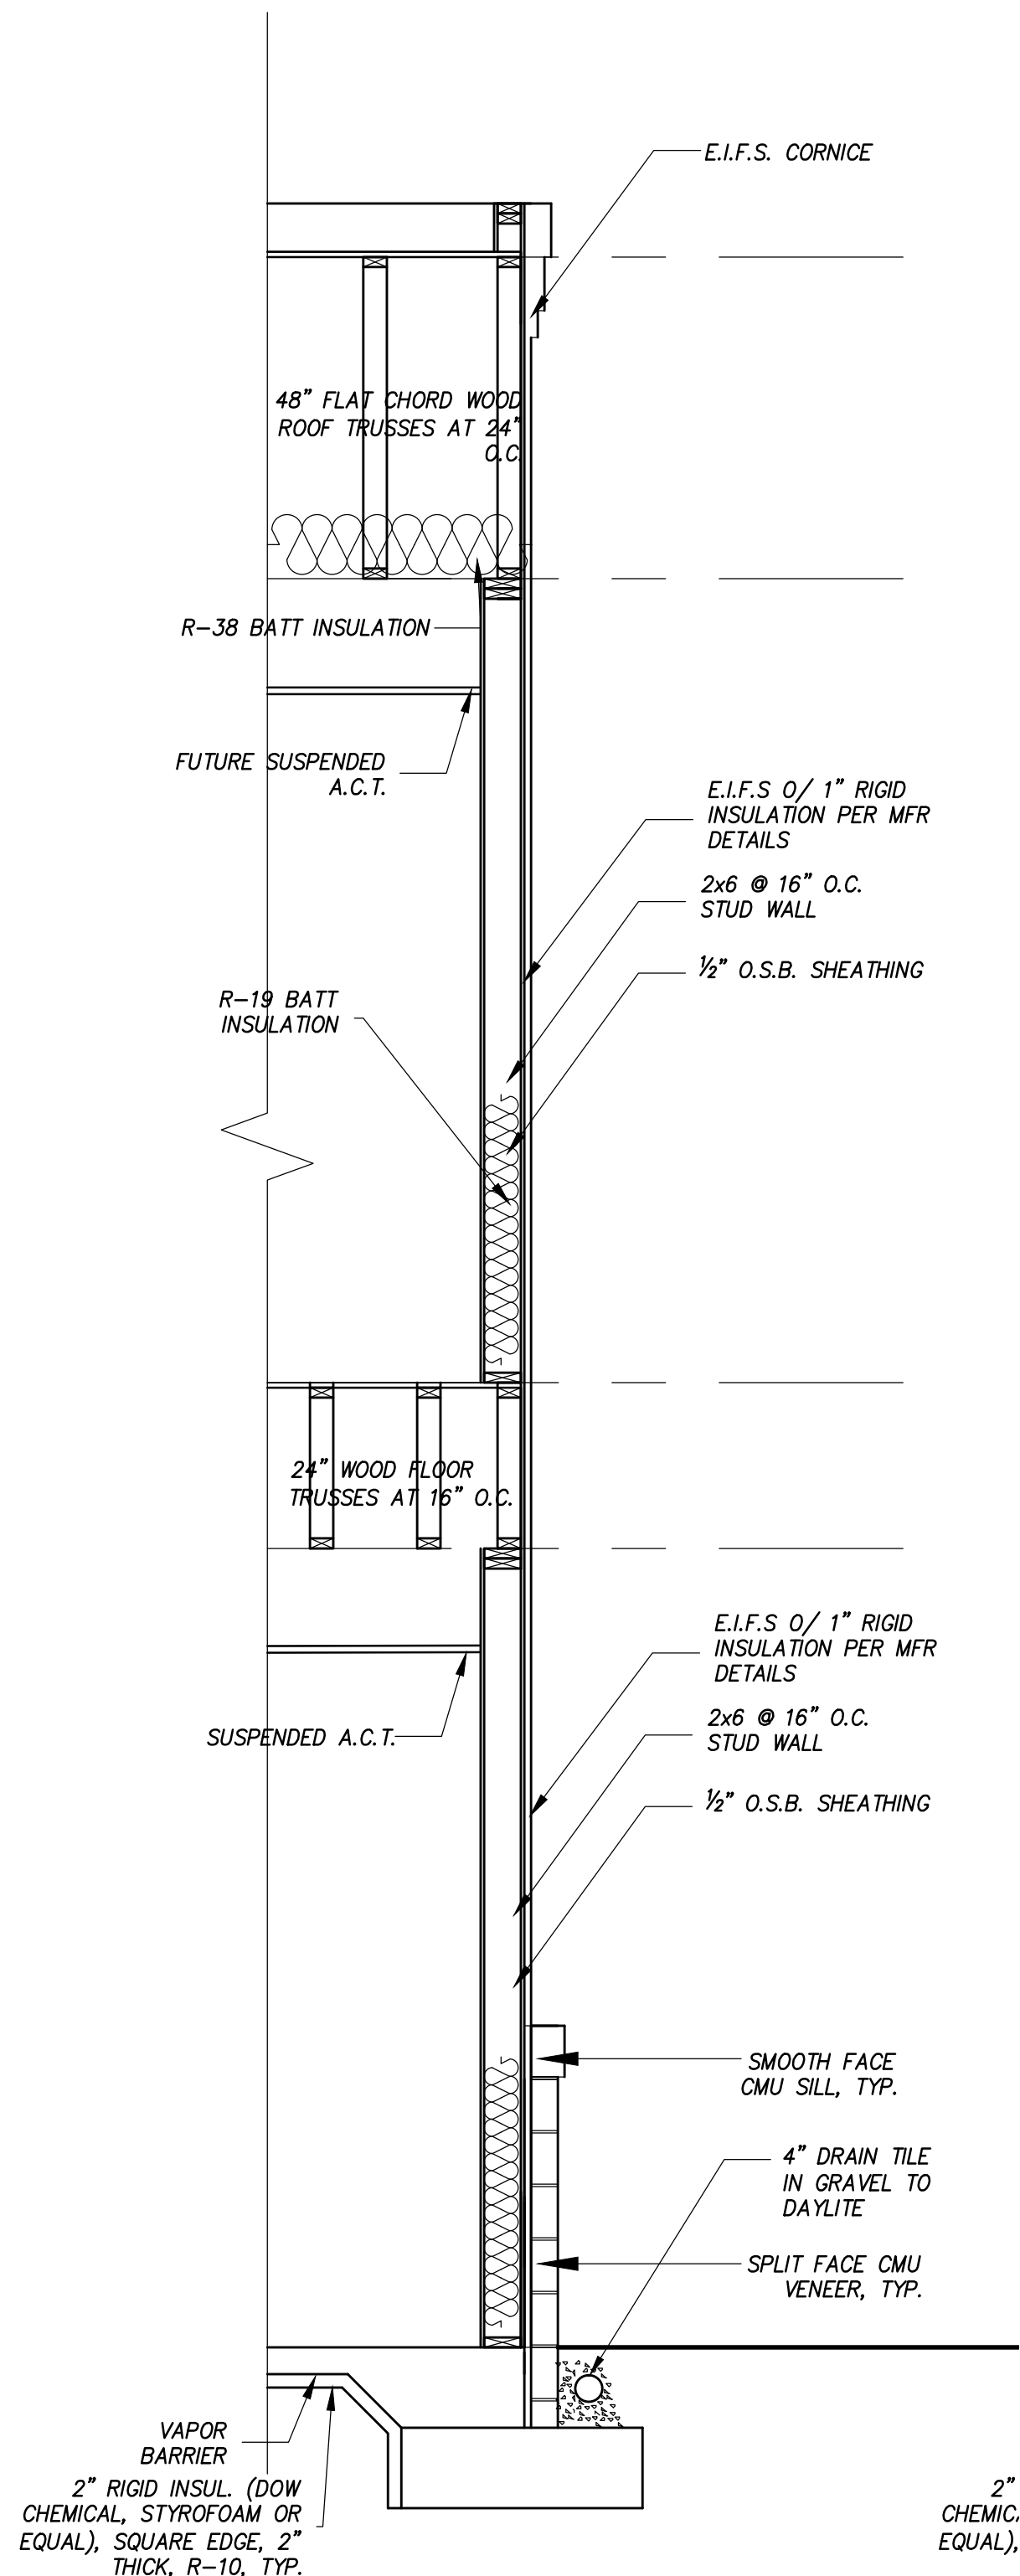

1 WALL SECTION
A9 SCALE: 1/2"=1'-0"

SEAL

REVISIONS	
DATE	REMARKS
6-06-17	OWNER CHANGES


ISSUED FOR
PERMIT
3-10-17

THIS DRAWING IS THE PROPERTY OF
S.E. Wagner, Architect
1304 SAVANNAH RD
LEWES, DE 19958
p.302.644.8884
f.302.644.8885
design@delmarva@verizon.net
sewain@aol.com
© 2014 S.E. WAGNER, ARCHITECT


CHURCH ROAD ANIMAL HOSPITAL
45441 RURITAN CIRCLE
STERLING VIRGINIA
CROSS SECTION C & D
WALL SECTIONS

DATE 1-17-17	SHEET NO. A
FILE -	


©2014 DESIGN DELMARVA / S.E. WAGNER, ARCHITECT EXPRESSLY RESERVES ITS COMMON LAW COPYRIGHT AND OTHER PROPERTY RIGHTS IN THESE PLANS. THESE PLANS ARE NOT TO BE REPRODUCED, CHANGED OR COPIED IN ANY FORM OR MANNER WHATSOEVER, NOR ARE THEY TO BE ASSIGNED TO ANY THIRD PARTY WITHOUT FIRST OBTAINING THE EXPRESS WRITTEN PERMISSION AND CONSENT OF DESIGN DELMARVA / S.E. WAGNER, ARCHITECT.

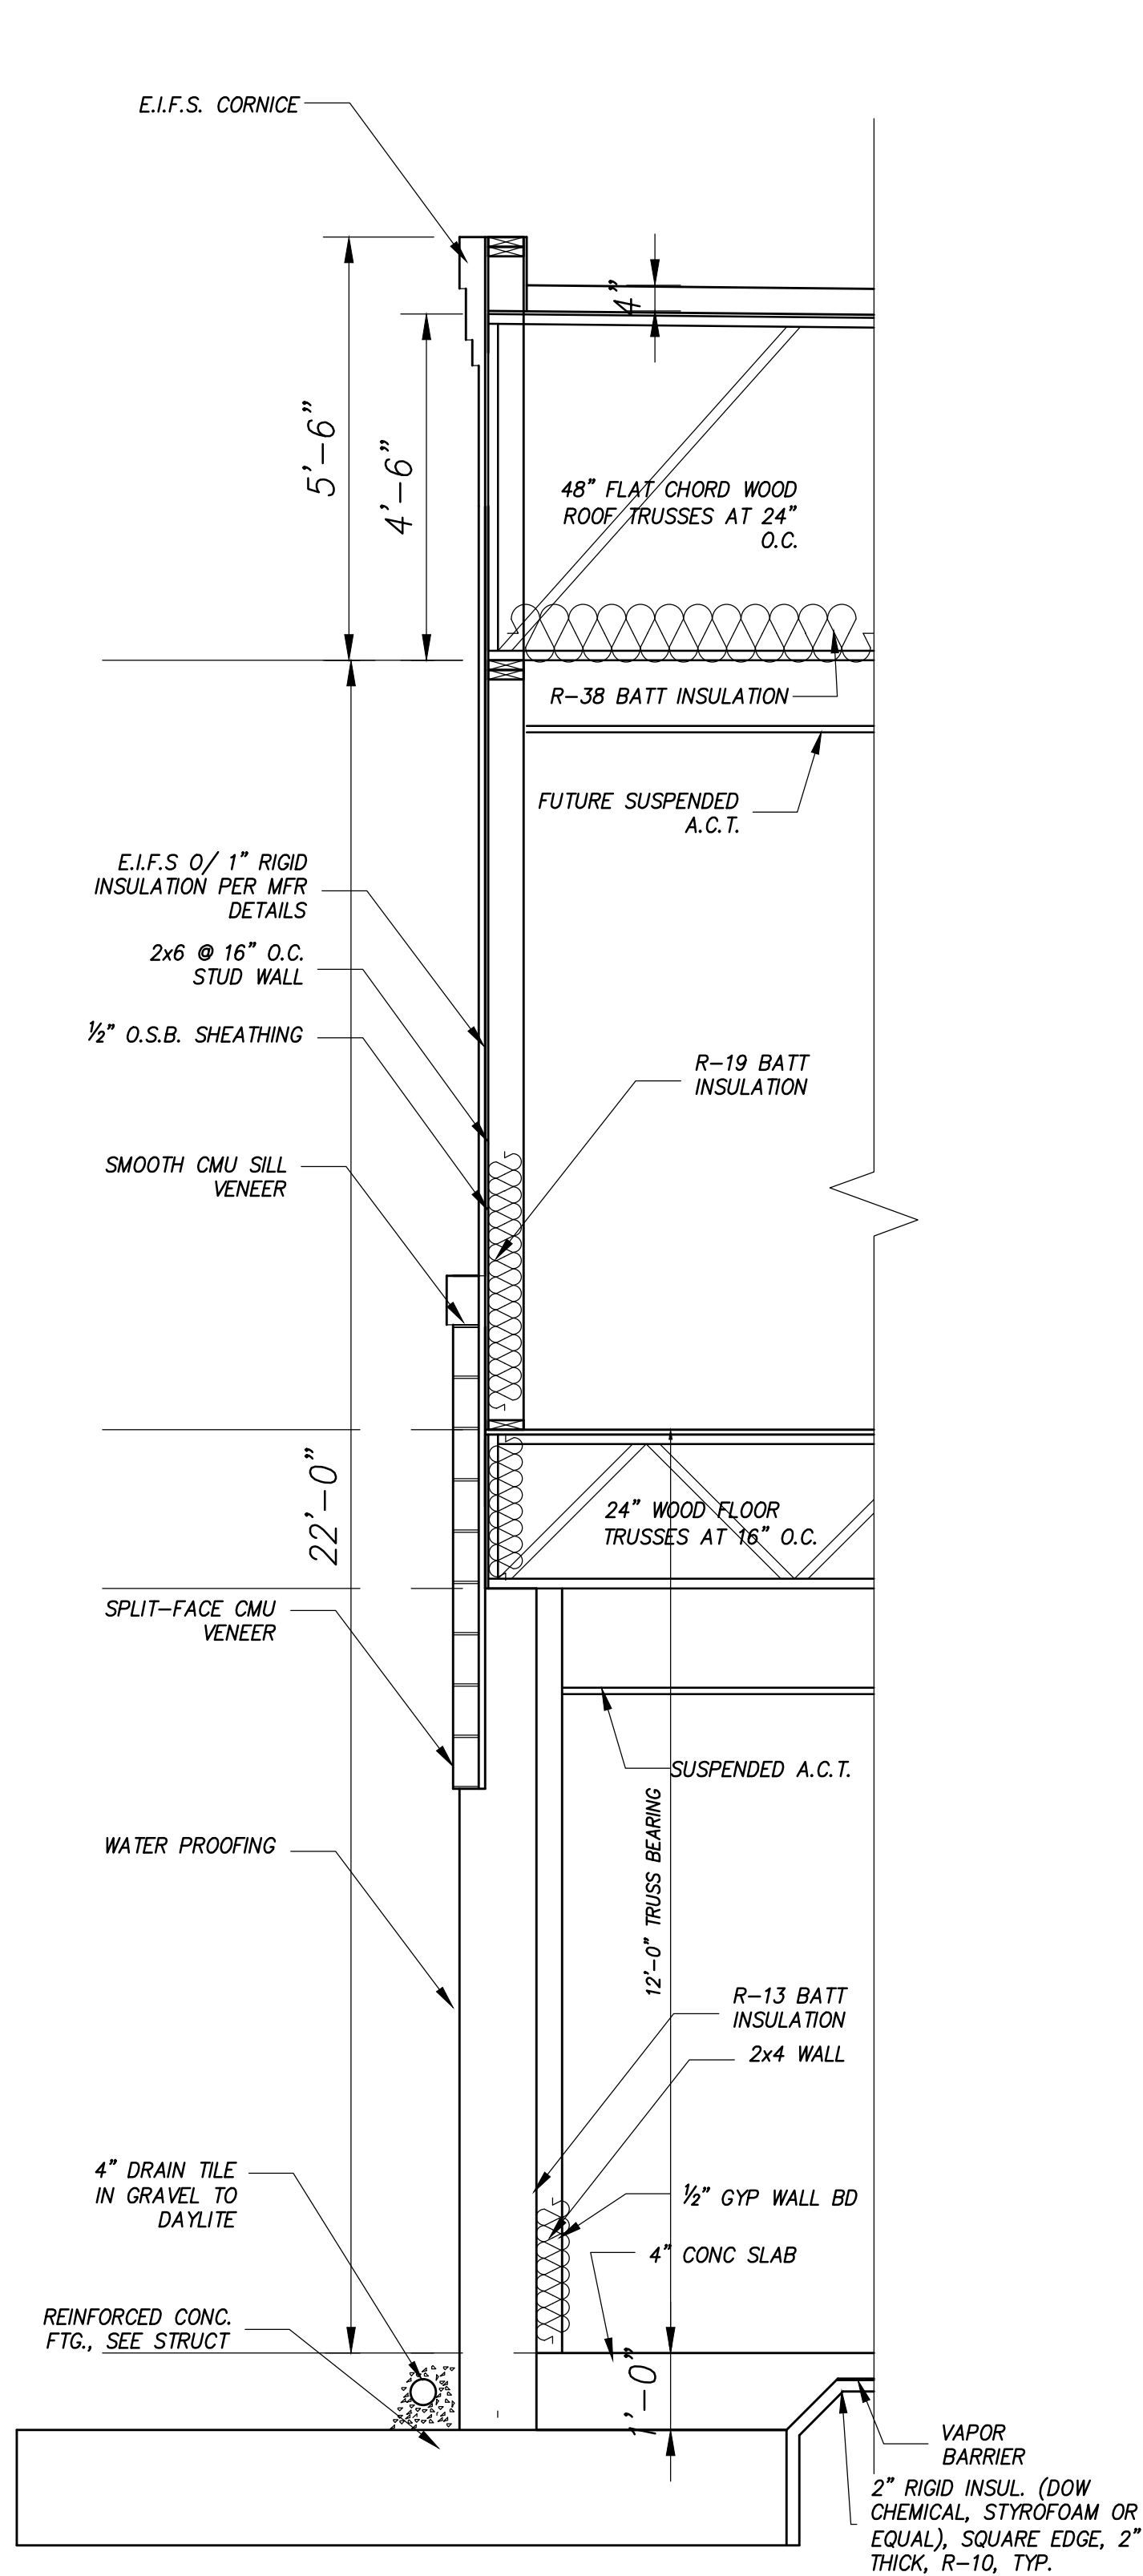


2 WALL SECTION
A10 SCALE: 1/2"=1'-0"

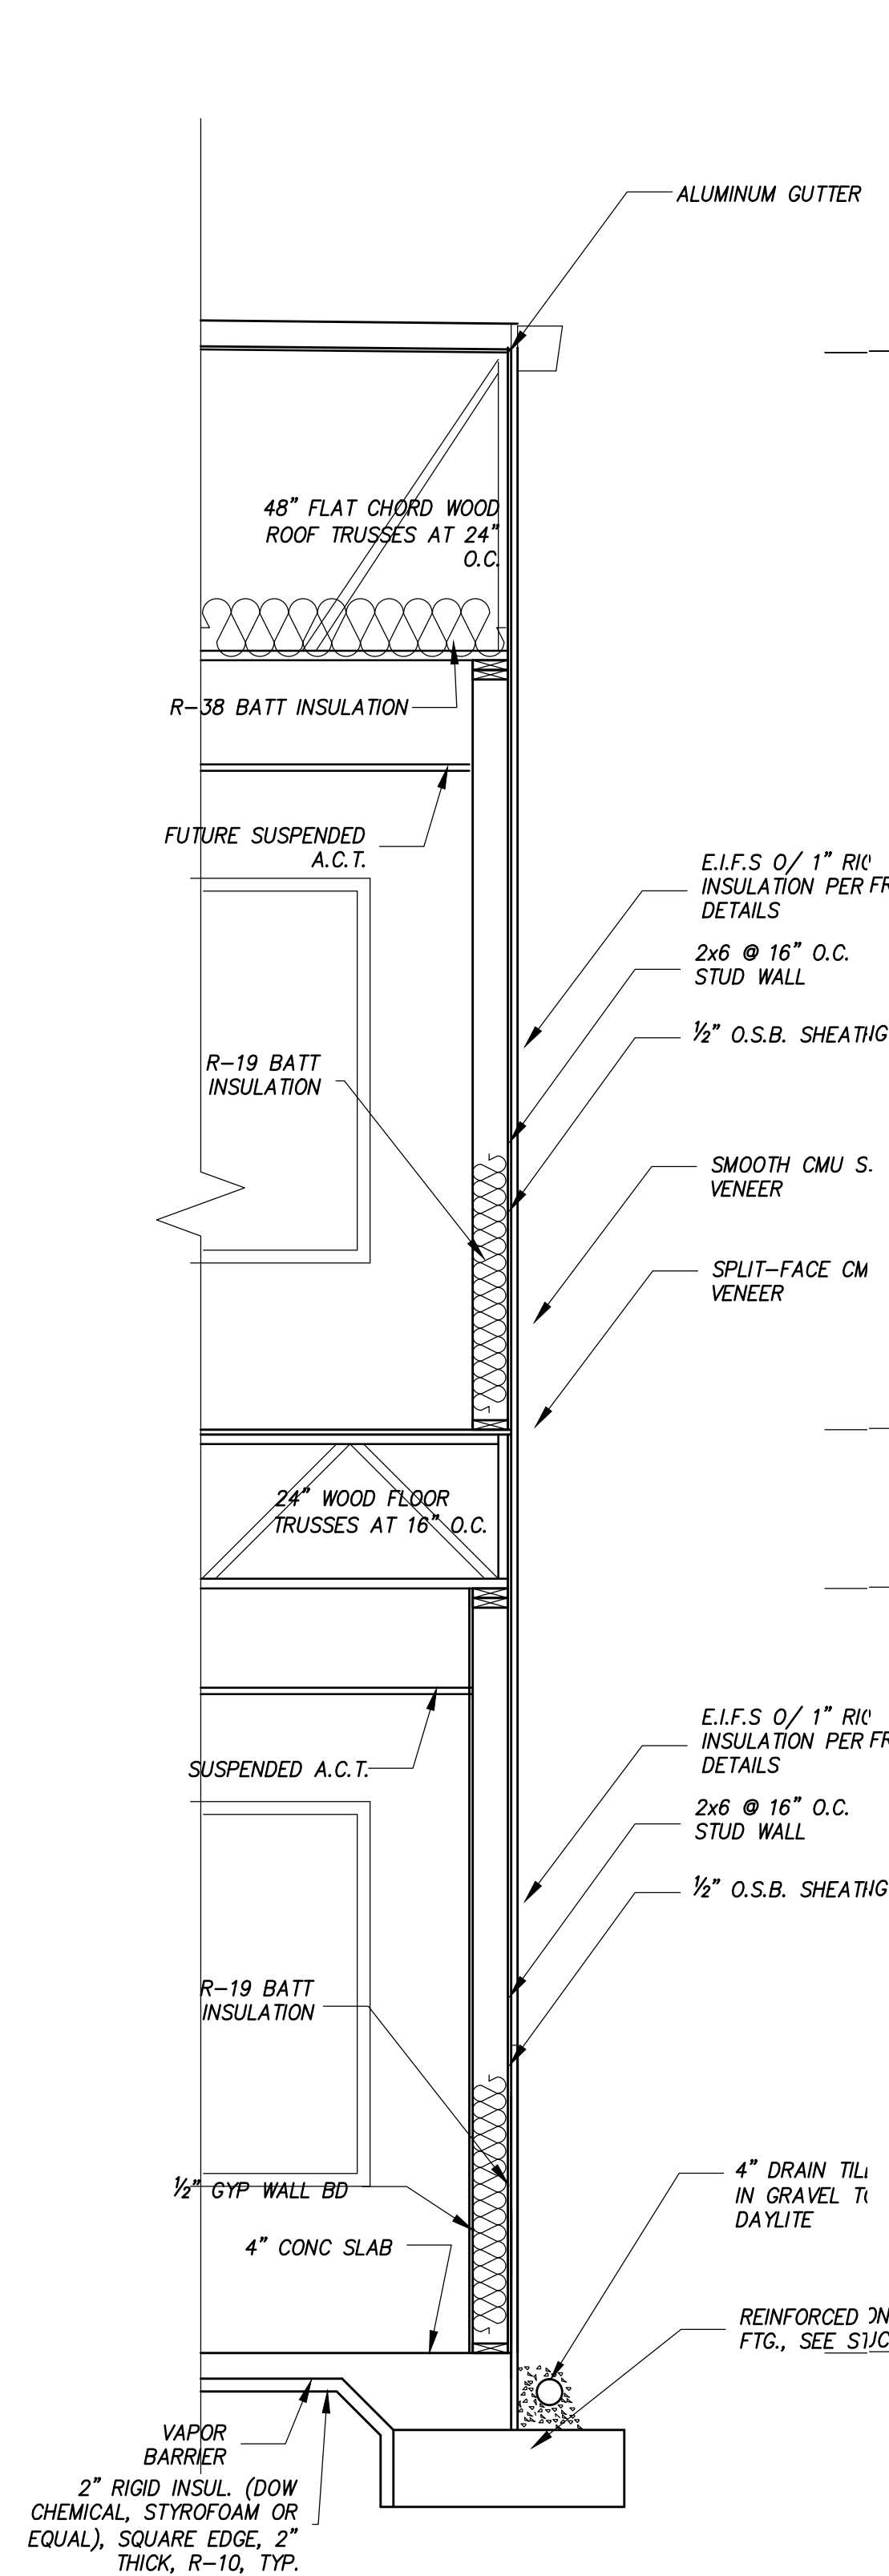

3 WALL SECTION
A10 SCALE: 1/2"=1'-0"

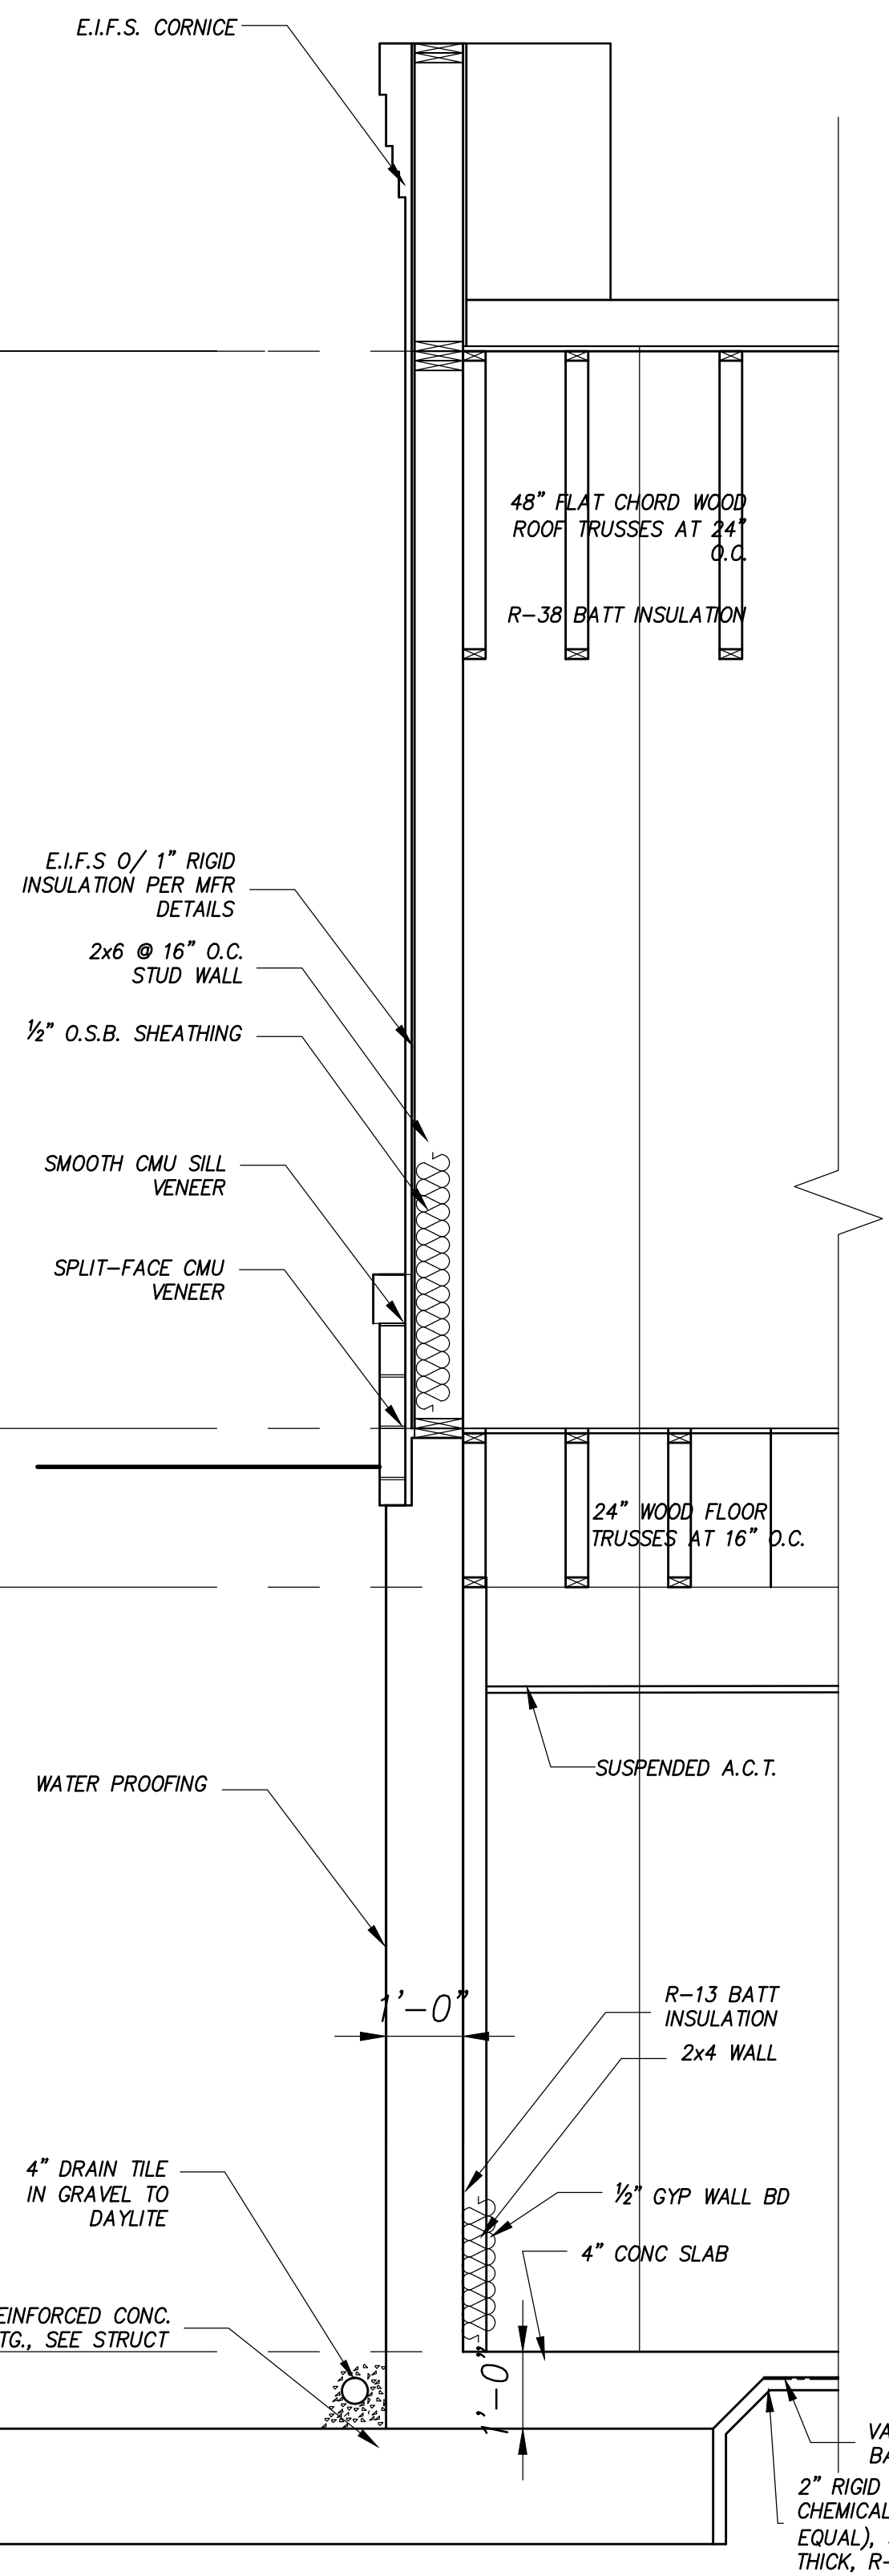

4 WALL SECTION
A10 SCALE: 1/2"=1'-0"

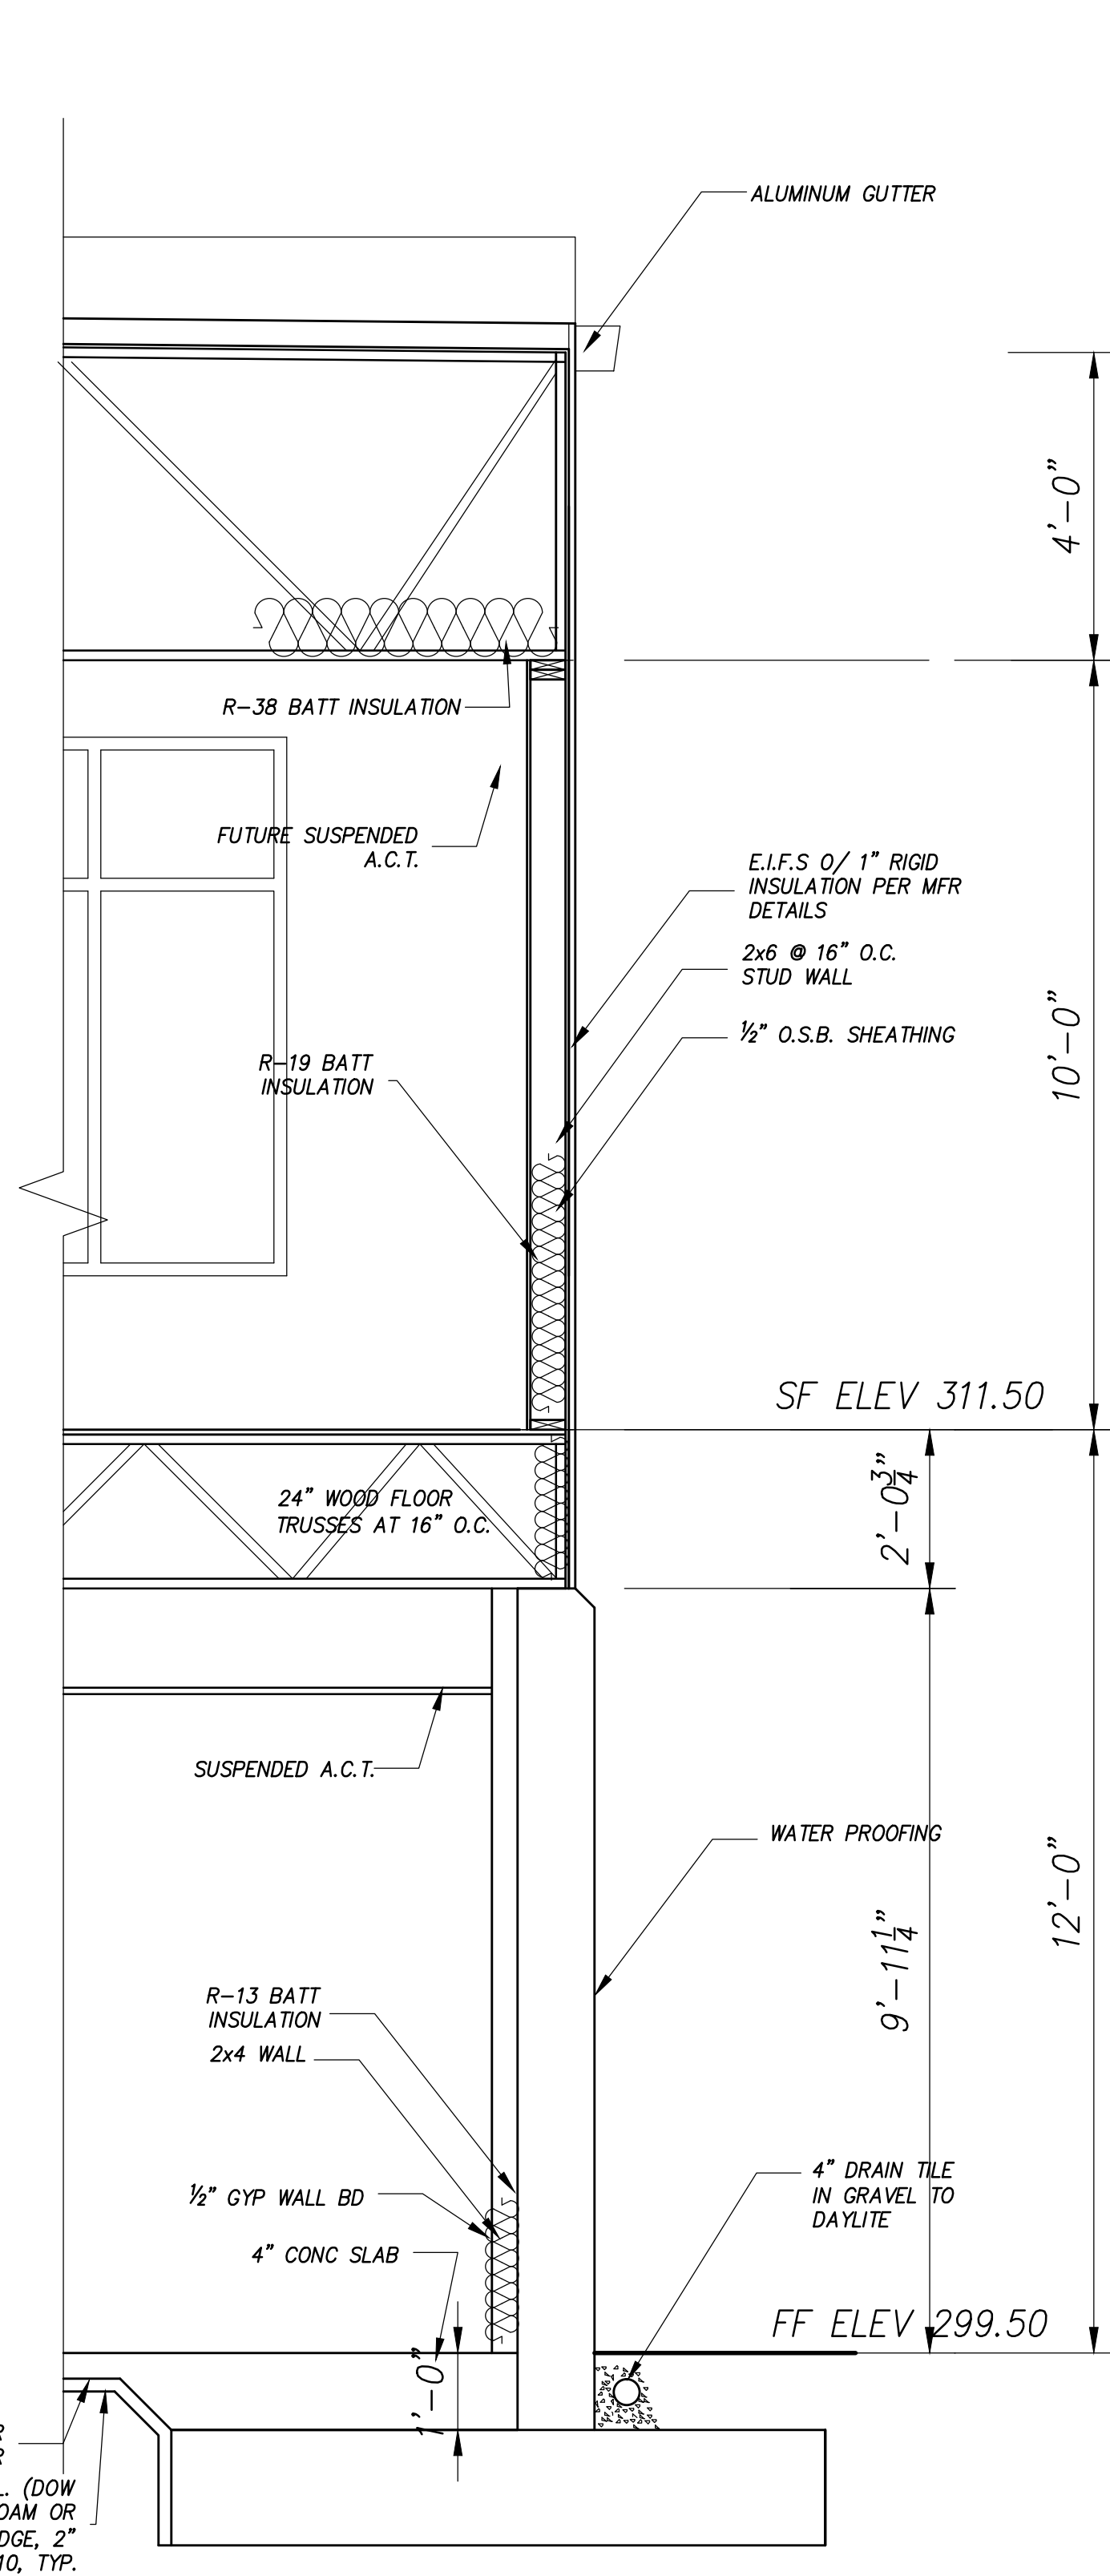

5 WALL SECTION
A10 SCALE: 1/2"=1'-0"

SEAL

REVISIONS	
DATE	REMARKS

ISSUED FOR
PERMIT
10-10-17

THIS DRAWING IS THE PROPERTY OF
S.E. Wagner, Architect
1304 SAVANNAH RD
LEWES, DE 19958
P. 302.644.8884
F. 302.644.8885
design@delmarva.com
sewain@aol.com
© 2014 S.E. WAGNER, ARCHITECT

CHURCH ROAD ANIMAL HOSPITAL
45441 RURITAN CIRCLE
STERLING VIRGINIA
WALL SECTIONS




DATE 1-17-17	SHEET NO. A10
FILE -	

©2014 DESIGN DELMARVA / S.E. WAGNER, ARCHITECT EXPRESSLY RESERVES ITS COMMON LAW COPYRIGHT AND OTHER PROPERTY RIGHTS IN THESE PLANS. THESE PLANS ARE NOT TO BE REPRODUCED, CHANGED OR COPIED IN ANY FORM OR MANNER WHATSOEVER. NORE ARE THEY TO BE ASSIGNED TO ANY THIRD PARTY WITHOUT FIRST OBTAINING THE EXPRESS WRITTEN PERMISSION AND CONSENT OF DESIGN DELMARVA / S.E. WAGNER, ARCHITECT.

DOOR SCHEDULE

DOOR No.	DOOR TYPE	DOOR				FRAME																LOCATION/REMARKS			
		SIZE				MAT.	FINISH	MAT.	FINISH	PANIC HARDWARE	ENTRANCE LOCKSET	OFFICE LOCKSET	PRIVACY LOCK	PUSH/PULL	STOREFRONT LOCK	PASSAGE LATCH	SPRING HINGES	CLOSER	WEATHER STRIPING	THRESHOLD	LABELLED ASSEMBLY	HARDWARE NOTE			
		W.	H.	D.	GLAZING																				
FIRST FLOOR																									
①	TYPE-B	3'-0"	7'-0"	1 3/4"	TEMPERED	ALUM	PF	ALUM	PF	●	●	-	-	-	-	-	-	●	●	●	-	-	-	WAITING AREA/STOREFRONT/EXTERIOR DOOR	
②	TYPE-B	3'-0"	7'-0"	1 3/4"	TEMPERED	ALUM	PF	ALUM	PF	●	●	-	-	-	-	-	-	●	●	●	-	-	-	STAIRWELL/STOREFRONT/EXTERIOR DOOR	
③	TYPE-A	3'-0" PAIR	7'-0"	1 3/4"	TEMPERED	ALUM	PF	ALUM	PF	●	●	-	-	-	-	-	-	●	●	●	-	-	-	VESTIBULE/STOREFRONT/EXTERIOR DOOR	
④	TYPE-A	3'-0" PAIR	7'-0"	1 3/4"	TEMPERED	ALUM	PF	ALUM	PF	●	●	-	-	-	-	-	-	●	●	●	-	-	-	VESTIBULE/STOREFRONT	
⑤	TYPE-B	3'-0"	7'-0"	1 3/4"	TEMPERED	ALUM	PF	ALUM	PF	●	●	-	-	-	-	-	-	●	●	●	-	-	-	BREAK ROOM/EXTERIOR DOOR	
⑥	TYPE-E	3'-0"	7'-0"	1 3/4"	-	HM	PNT	HM	PNT	-	-	-	-	-	●	-	-	●	-	-	-	-	-	ELEVATOR MACHINE ROOM	
⑦	TYPE-D	3'-0"	7'-0"	1 3/4"	-	SC	STN	HM	PNT	-	-	-	-	-	●	-	-	●	-	-	-	-	-	EXAM ROOM PTRSR	
⑧	TYPE-D	3'-0"	7'-0"	1 3/4"	-	SC	STN	HM	PNT	-	-	-	-	-	●	-	-	●	-	-	-	-	-	EXAM ROOM PTRSR	
⑨	TYPE-D	3'-0"	7'-0"	1 3/4"	TEMPERED	SC	STN	HM	PNT	-	-	-	-	-	●	-	-	●	-	-	-	-	-	CAT EXAM ROOM	
⑩	TYPE-D	3'-0"	7'-0"	1 3/4"	TEMPERED	SC	STN	HM	PNT	-	-	-	-	-	●	-	-	●	-	-	-	-	-	CAT EXAM ROOM	
⑪	TYPE-C	3'-0"	7'-0"	1 3/4"	TEMPERED	SC	PNT	HM	PNT	-	-	-	-	-	●	-	-	●	-	-	-	-	-	QUARANTINE	
⑫	TYPE-D	3'-0"	7'-0"	1 3/4"	TEMPERED	SC	STN	HM	PNT	-	-	-	-	-	●	-	-	●	-	-	-	-	-	PASSAGE/PHARMACY	
⑬	TYPE-D	3'-0"	7'-0"	1 3/4"	TEMPERED	SC	STN	HM	PNT	-	-	-	-	-	●	-	-	●	-	-	-	-	-	SURGERY CLOSET	
⑭	TYPE-D	3'-0"	7'-0"	1 3/4"	TEMPERED	SC	STN	HM	PNT	-	-	-	-	-	●	-	-	●	-	-	-	-	-	SURGERY	
⑮	TYPE-D	3'-0"	7'-0"	1 3/4"	TEMPERED	SC	STN	HM	PNT	-	-	●	-	-	●	-	-	●	-	-	-	-	-	EXAM ROOM	
⑯	TYPE-D	3'-0"	7'-0"	1 3/4"	TEMPERED	SC	STN	HM	PNT	-	-	-	-	-	●	-	-	●	-	-	-	-	-	EXAM ROOM	
⑰	TYPE-E	3'-0"	7'-0"	1 3/4"	-	SC	STN	HM	PNT	-	-	-	-	-	●	-	-	●	-	-	-	-	-	WOMEN'S TOILET	
⑱	TYPE-E	3'-0"	7'-0"	1 3/4"	-	SC	STN	HM	PNT	-	-	-	-	-	●	-	-	●	-	-	-	-	-	MEN'S TOILET	
⑲	TYPE-E	3'-0"	7'-0"	1 3/4"	-	HM	PNT	HM	PNT	-	-	-	-	-	●	-	-	●	-	-	-	-	-	STORAGE ROOM	
⑳	TYPE-D	3'-0"	7'-0"	1 3/4"	TEMPERED	HM	PNT	HM	PNT	-	-	-	-	-	●	-	-	●	-	-	-	-	-	EXAM ROOM	
㉑	TYPE-D	3'-0"	7'-0"	1 3/4"	TEMPERED	SC	PNT	HM	PNT	-	-	-	-	-	●	-	-	●	-	-	-	-	-	EXAM ROOM	
㉒	TYPE-E	3'-0"	7'-0"	1 3/4"	-	SC	PNT	HM	PNT	-	-	-	-	-	●	-	-	●	-	-	-	-	-	X RAY	
㉓	TYPE-C	3'-0"	7'-0"	1 3/4"	-	SC	PNT	HM	PNT	-	-	-	-	-	●	-	-	●	-	-	-	-	-	KENNEL	
㉔	TYPE-E	3'-0"	7'-0"	1 3/4"	TEMPERED	HM	PNT	HM	PNT	-	-	-	-	-	●	-	-	●	-	-	-	-	-	JANITOR CLOSET	
㉕	TYPE-A	3'-0" PAIR	7'-0"	1 3/4"	TEMPERED	ALUM	PF	ALUM	PF	●	●	-	-	-	-	●	-	●	-	-	-	-	-	CHURCH RD ENTRANCE	
㉖	TYPE-E	3'-0"	7'-0"	1 3/4"	-	HM	PNT	HM	PNT	-	-	-	-	-	●	-	-	●	-	-	¾ HR	-	-	2ND FLOOR STAIRWELL	
ABBREVIATIONS SC = SOLID CORE, PAINT GRADE, BIRCH VENEER, FLUSH DOOR HM = HOLLOW METAL ANDZ = ANODIZE ALUM = ALUMINUM PF = MANUFACTURER PREFINISH PG = PLEXIGLAS MFC = PRE FINISHED METAL W/ FOAM CORE INSULATION STL = STEEL GALV = GALVANIZED PNT = PAINT STN = STAINED																									

DOOR TYPES

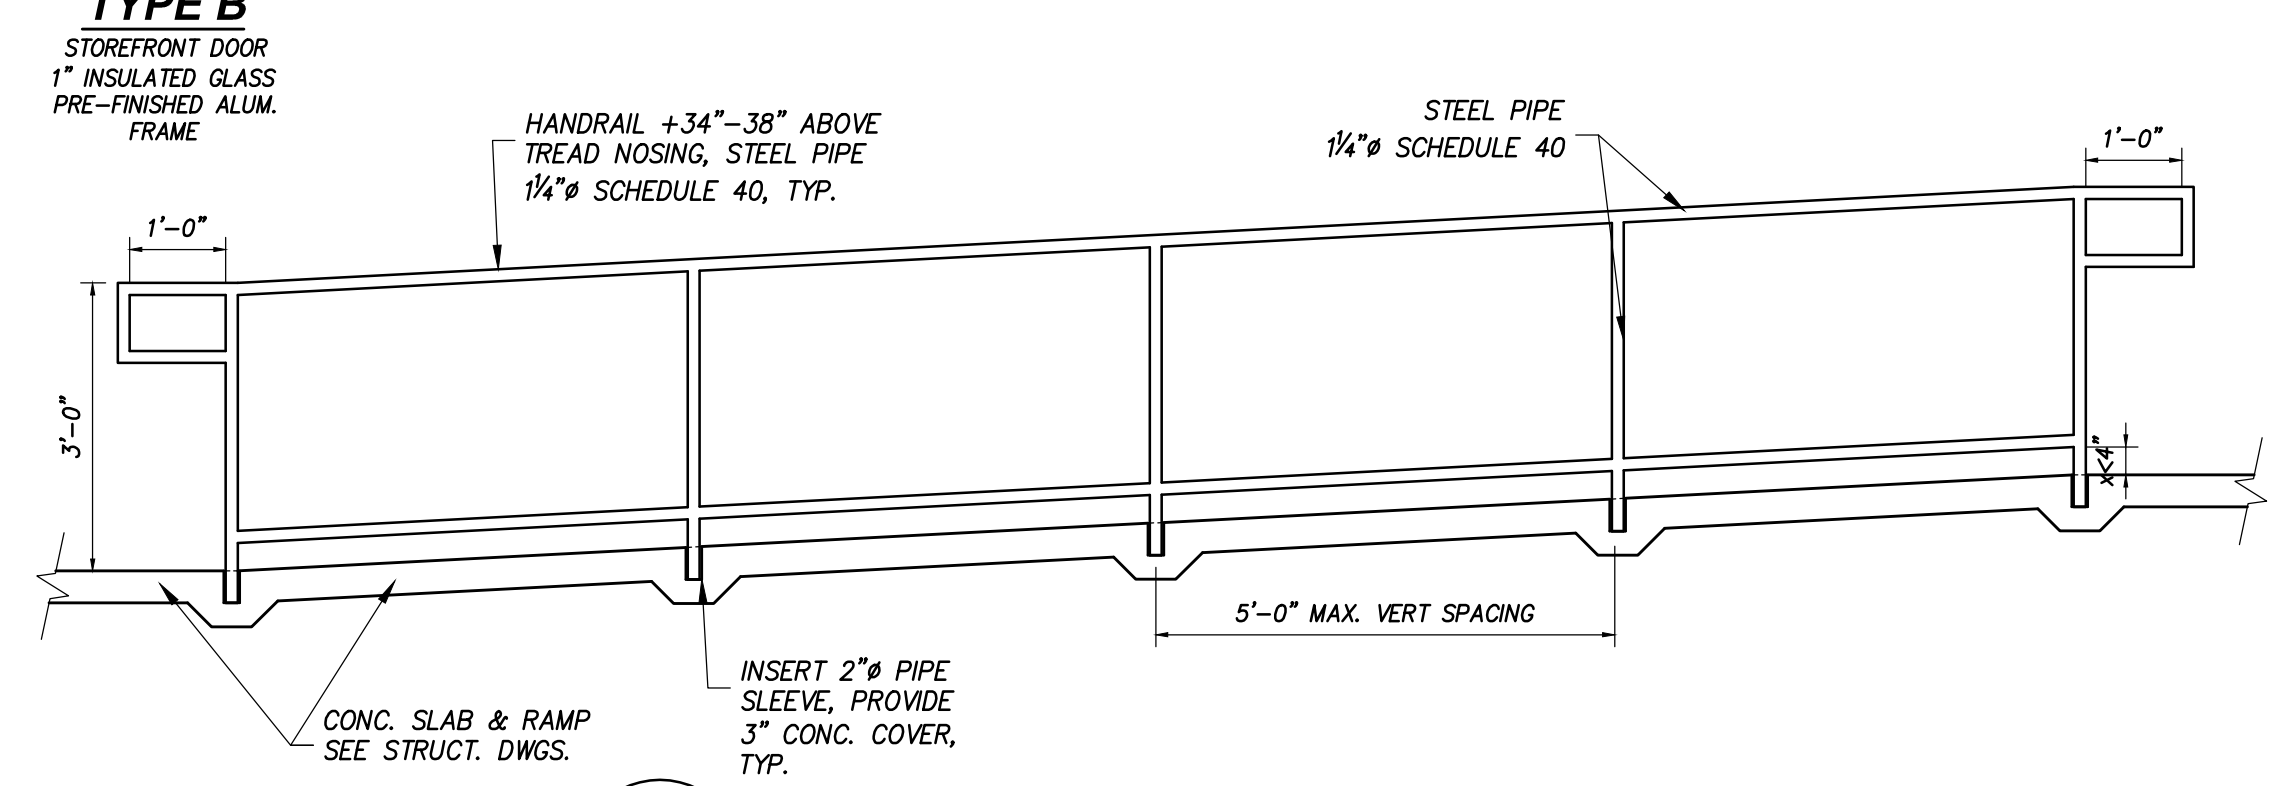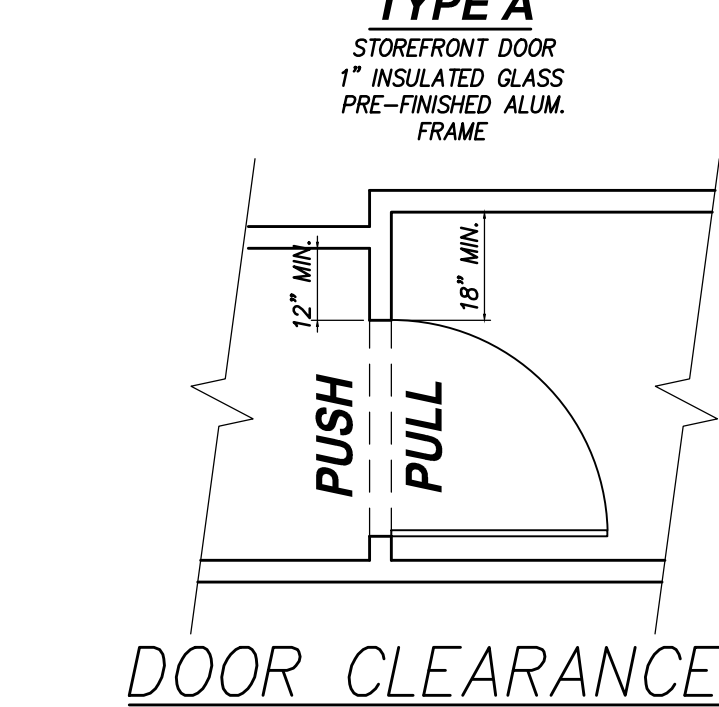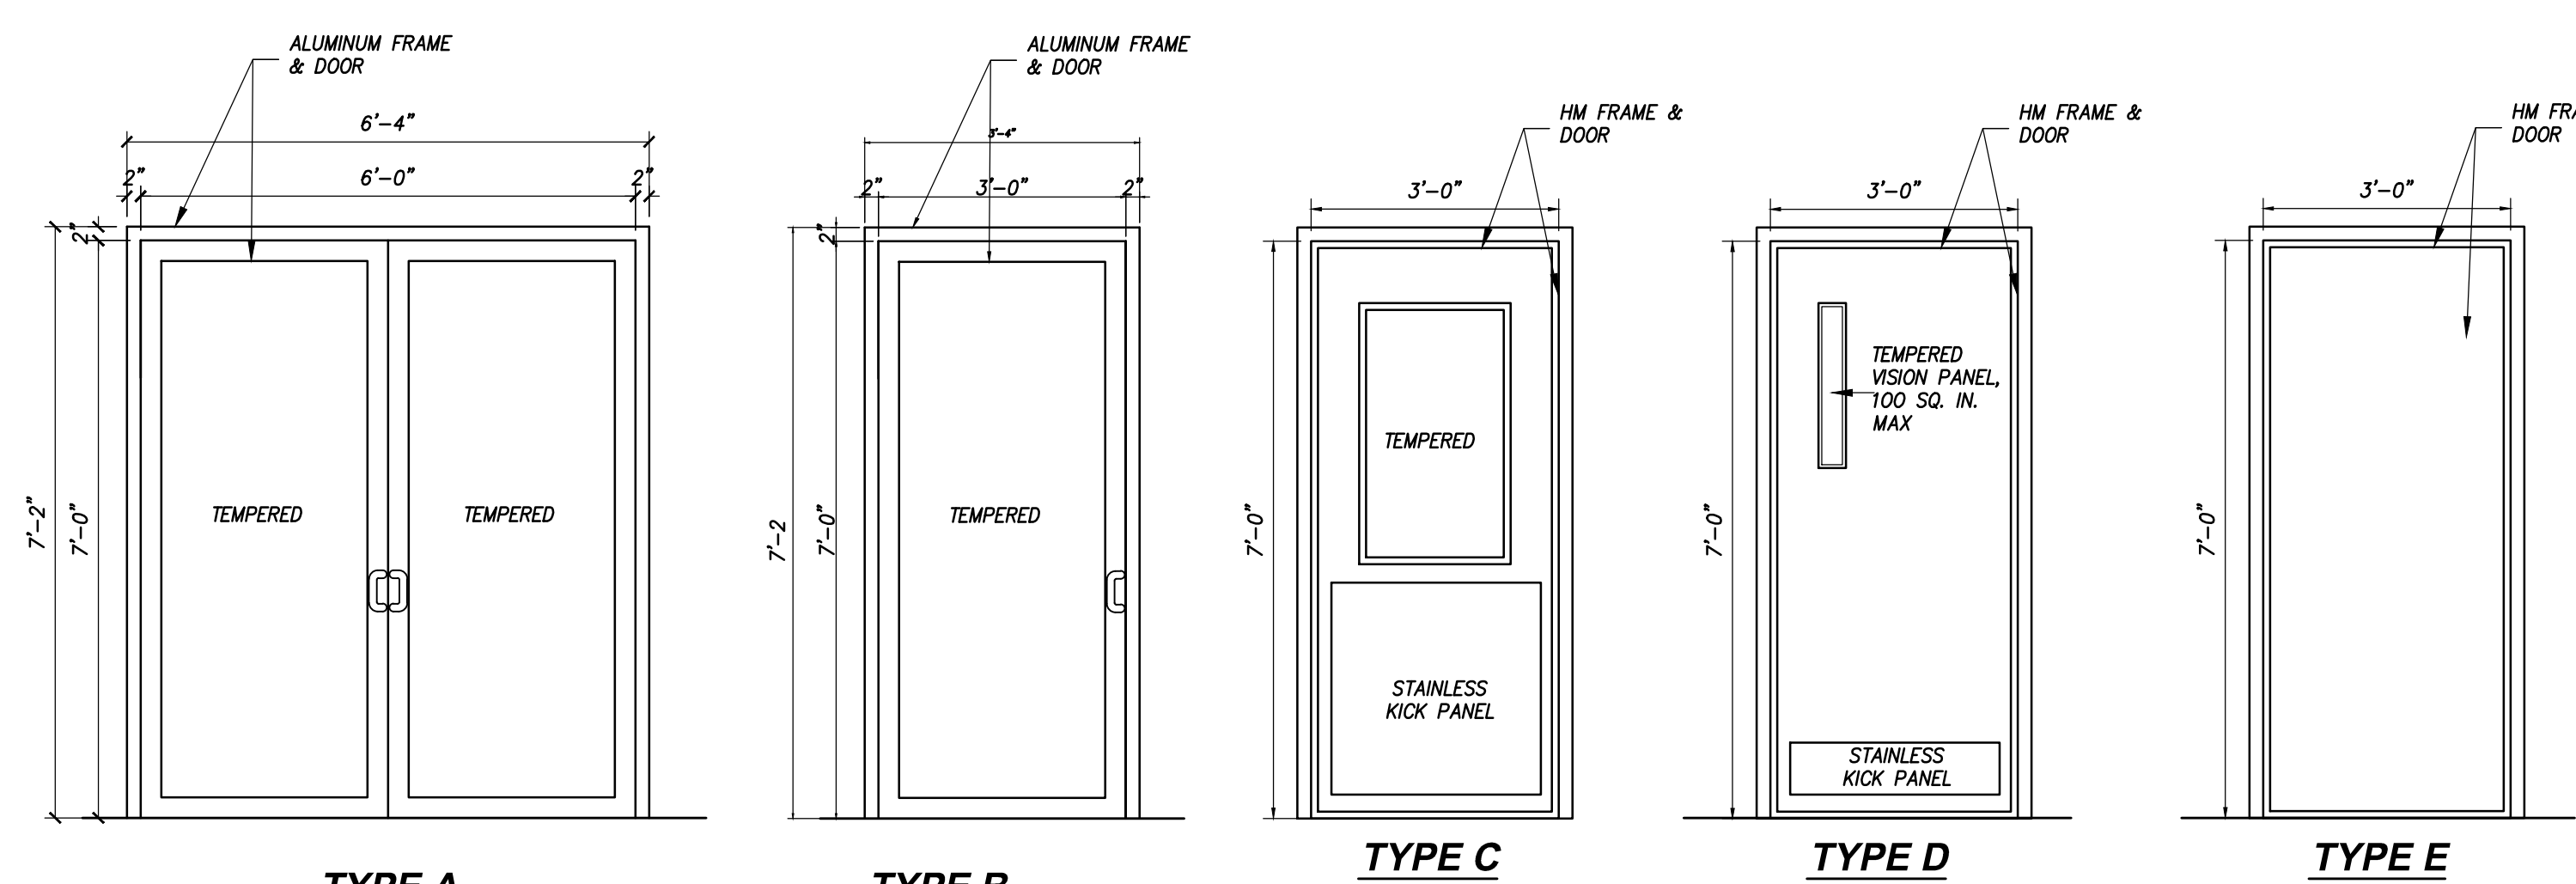


3 TYP. CONC. RAMP DETAIL A11

SCALE: 1/2"=1'-0"

FINISH SCHEDULE:


FLOOR FINISH ROOM NAME
A - SEALED CONCRETE W/EPOXY FINISH/COVE
B - NO FLOORING (UNFINISHED)
C - GLUE-DOWN CARPET W/ EXTRA PADDING
D - SHEET VINYL
E - VCT
F - CERAMIC TILE
BASE
4 - WOOD
5 - VINYL
6 - CARPET
0 - NONE
WALLS
G - GYPSUM BOARD AND PAINT
G.1 - NO FINISH
H - GREEN (MOISTURE RESISTANT) GYPSUM BOARD
J - CMU AND PAINT
K - CERAMIC TILE TO 48" H.T.
K.1 - FRP FULL HEIGHT.
CEILING
L - ACOUSTICAL CEILING TILE
M - GYPSUM BOARD AND PAINT
N - EXPOSED STRUCTURE

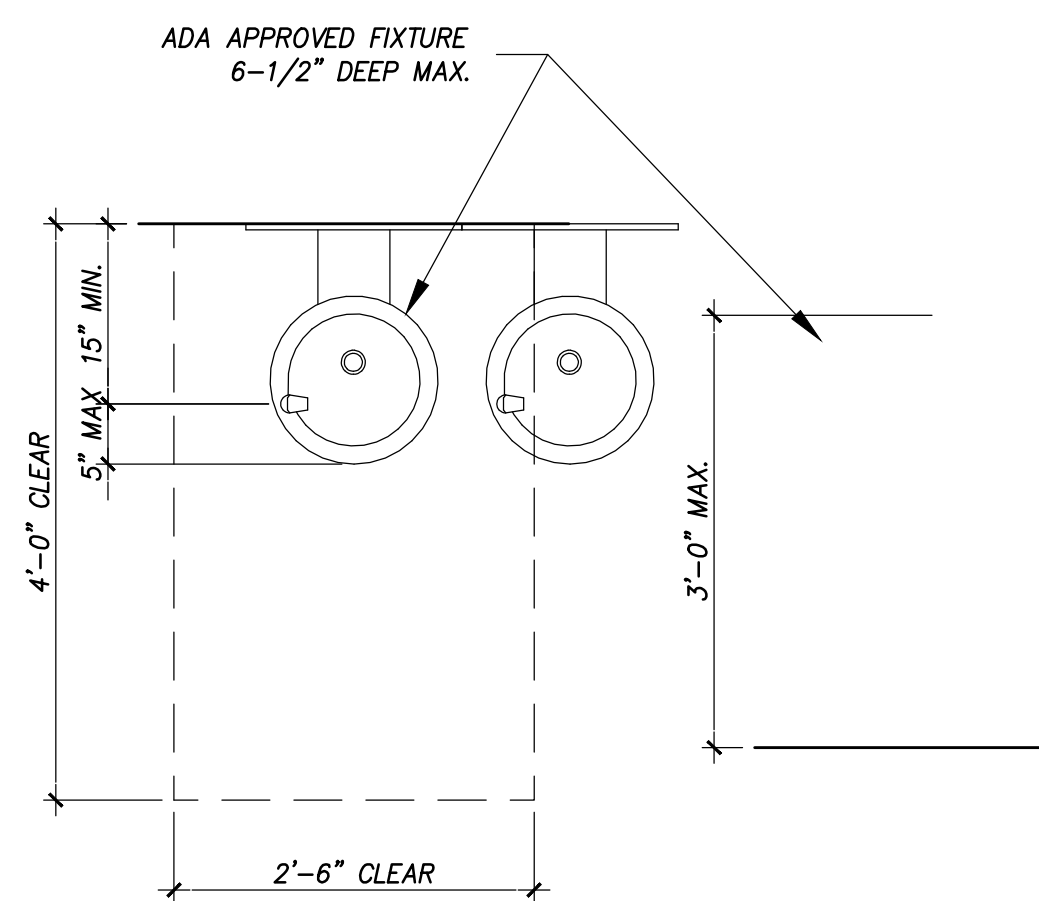

WATER FOUNTAIN DETAILS


SCALE: 3/4"=1'-0"

NOTE: THE STEEL STAIR SHOP DRAWING SHALL BE DESIGNED AND CERTIFIED BY A LICENSED STRUCTURAL ENGINEER, THE SHOP DRAWING SHALL BE REVIEWED AND APPROVED BY THE BUILDING STRUCTURAL ENGINEER OF RECORD

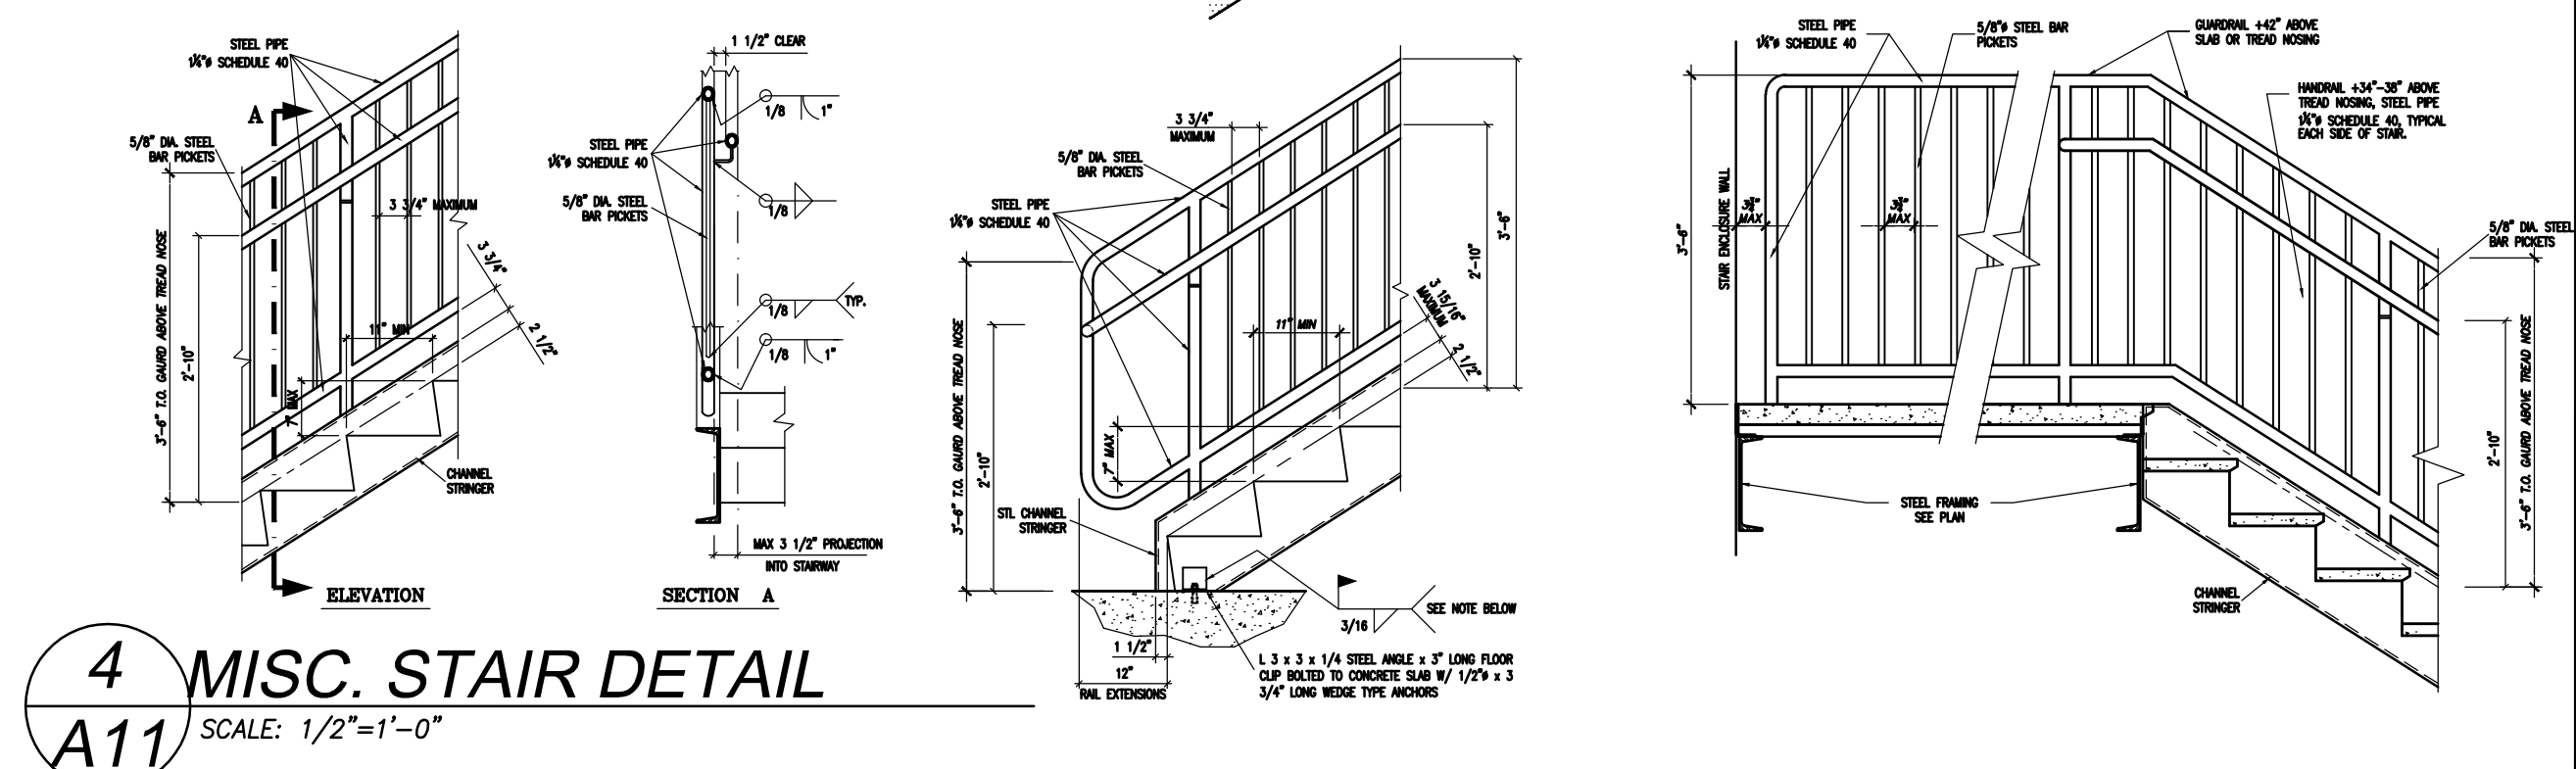


4 MISC. STAIR DETAIL A11

SCALE: 1/2"=1'-0"

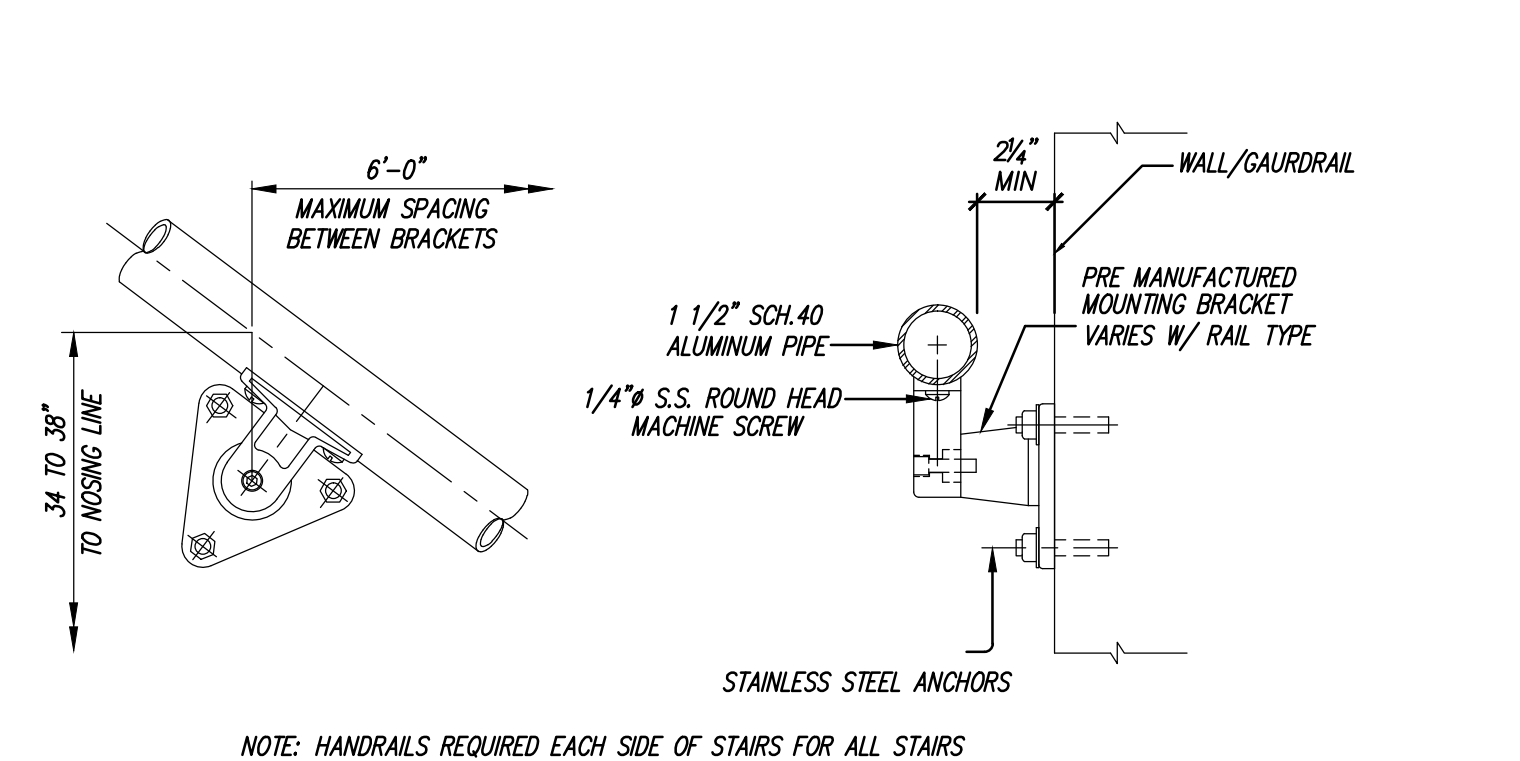

NOTE: HANDRAILS REQUIRED EACH SIDE OF STAIRS FOR ALL STAIRS

1 RAILING DETAIL A11 NOT TO SCALE

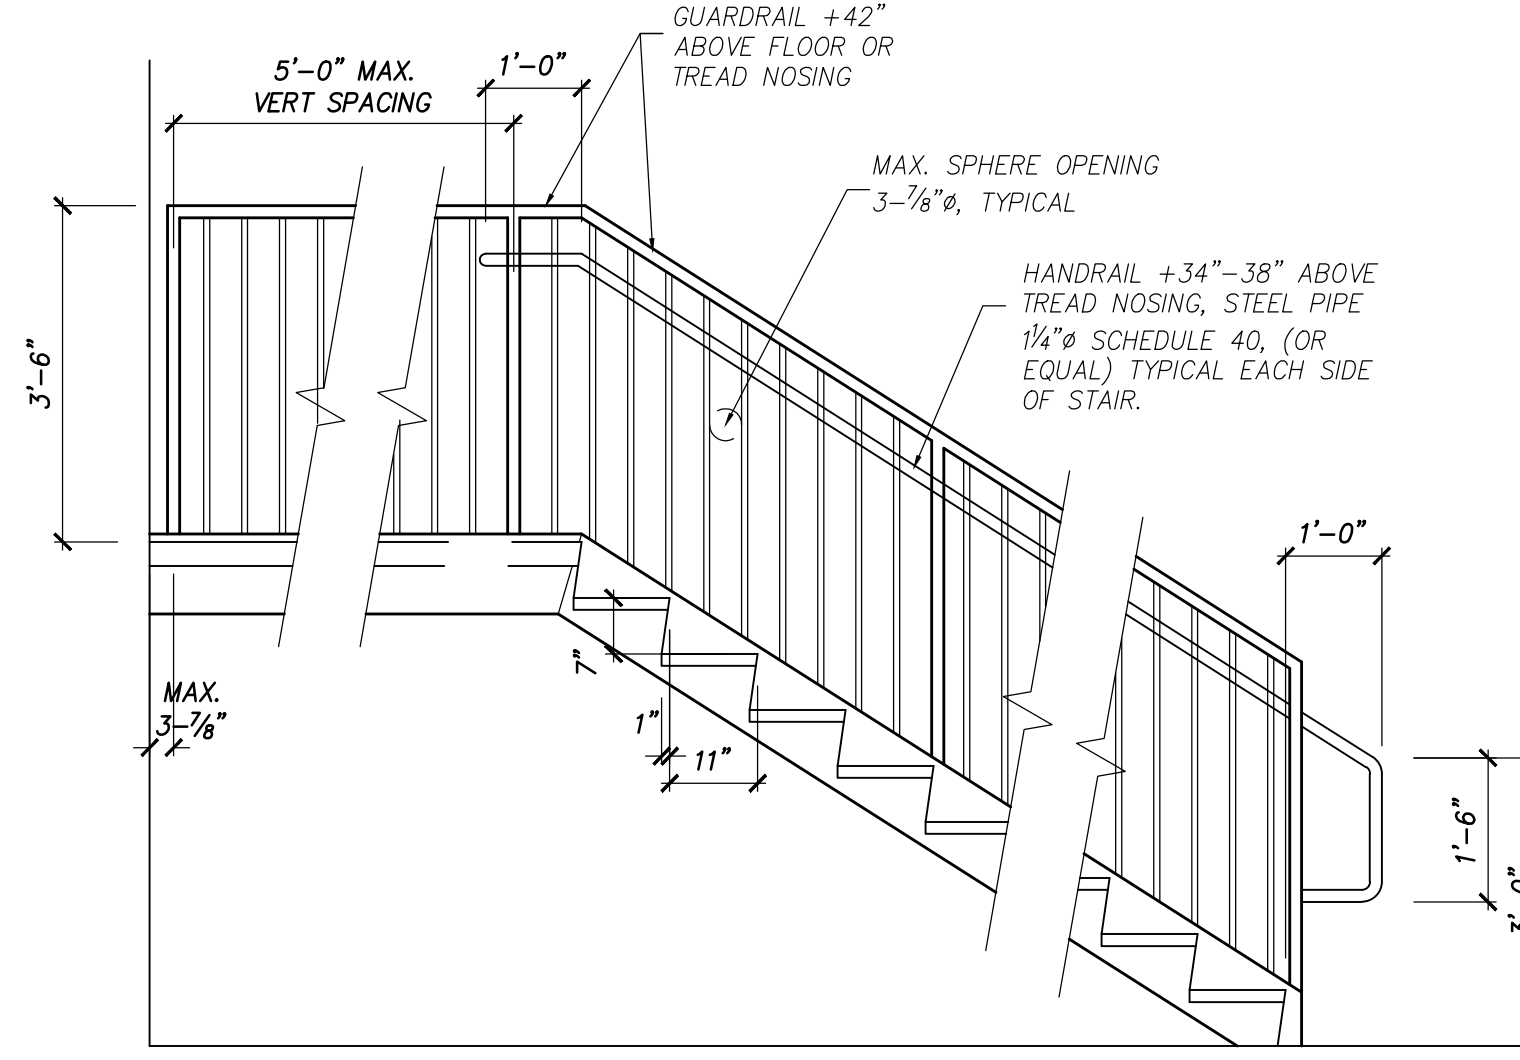

2 STAIR DETAIL A11 SCALE: 3/4"=1'-0"

SEAL

REVISIONS	
DATE	REMARKS

ISSUED FOR PERMIT 3-10-17

THIS DRAWING IS THE PROPERTY OF
S.E. Wagner, Architect
4252 MANOR DRIVE
MARSHALL, VA 20115
p.540.364.6399
f.540.364.0446
sewain@aol.com
© 2014 S.E. WAGNER, ARCHITECT



1304 SAVANNAH RD
LEWES, DE 19958
p.302.644.8884
f.302.644.8885
design@delmarva@verizon.net

CHURCH ROAD ANIMAL HOSPITAL
45441 RURITAN CIRCLE
STERLING VIRGINIA
DOOR SCHEDULE: FINISH SCHEDULE

DATE 1-17-17	SHEET NO. A11
FILE -	

©2014 DESIGN DELMARVA / S.E. WAGNER, ARCHITECT EXPRESSLY RESERVES ITS COMMON LAW COPYRIGHT AND OTHER PROPERTY RIGHTS IN THESE PLANS. THESE PLANS ARE NOT TO BE REPRODUCED, CHANGED OR COPIED IN ANY FORM OR MANNER WHATSOEVER, NOR ARE THEY TO BE ASSIGNED TO ANY THIRD PARTY WITHOUT FIRST OBTAINING THE EXPRESS WRITTEN PERMISSION AND CONSENT OF DESIGN DELMARVA / S.E. WAGNER, ARCHITECT.

WINDOW TYPES

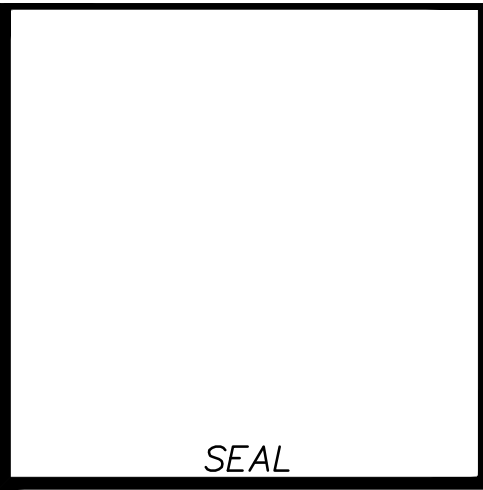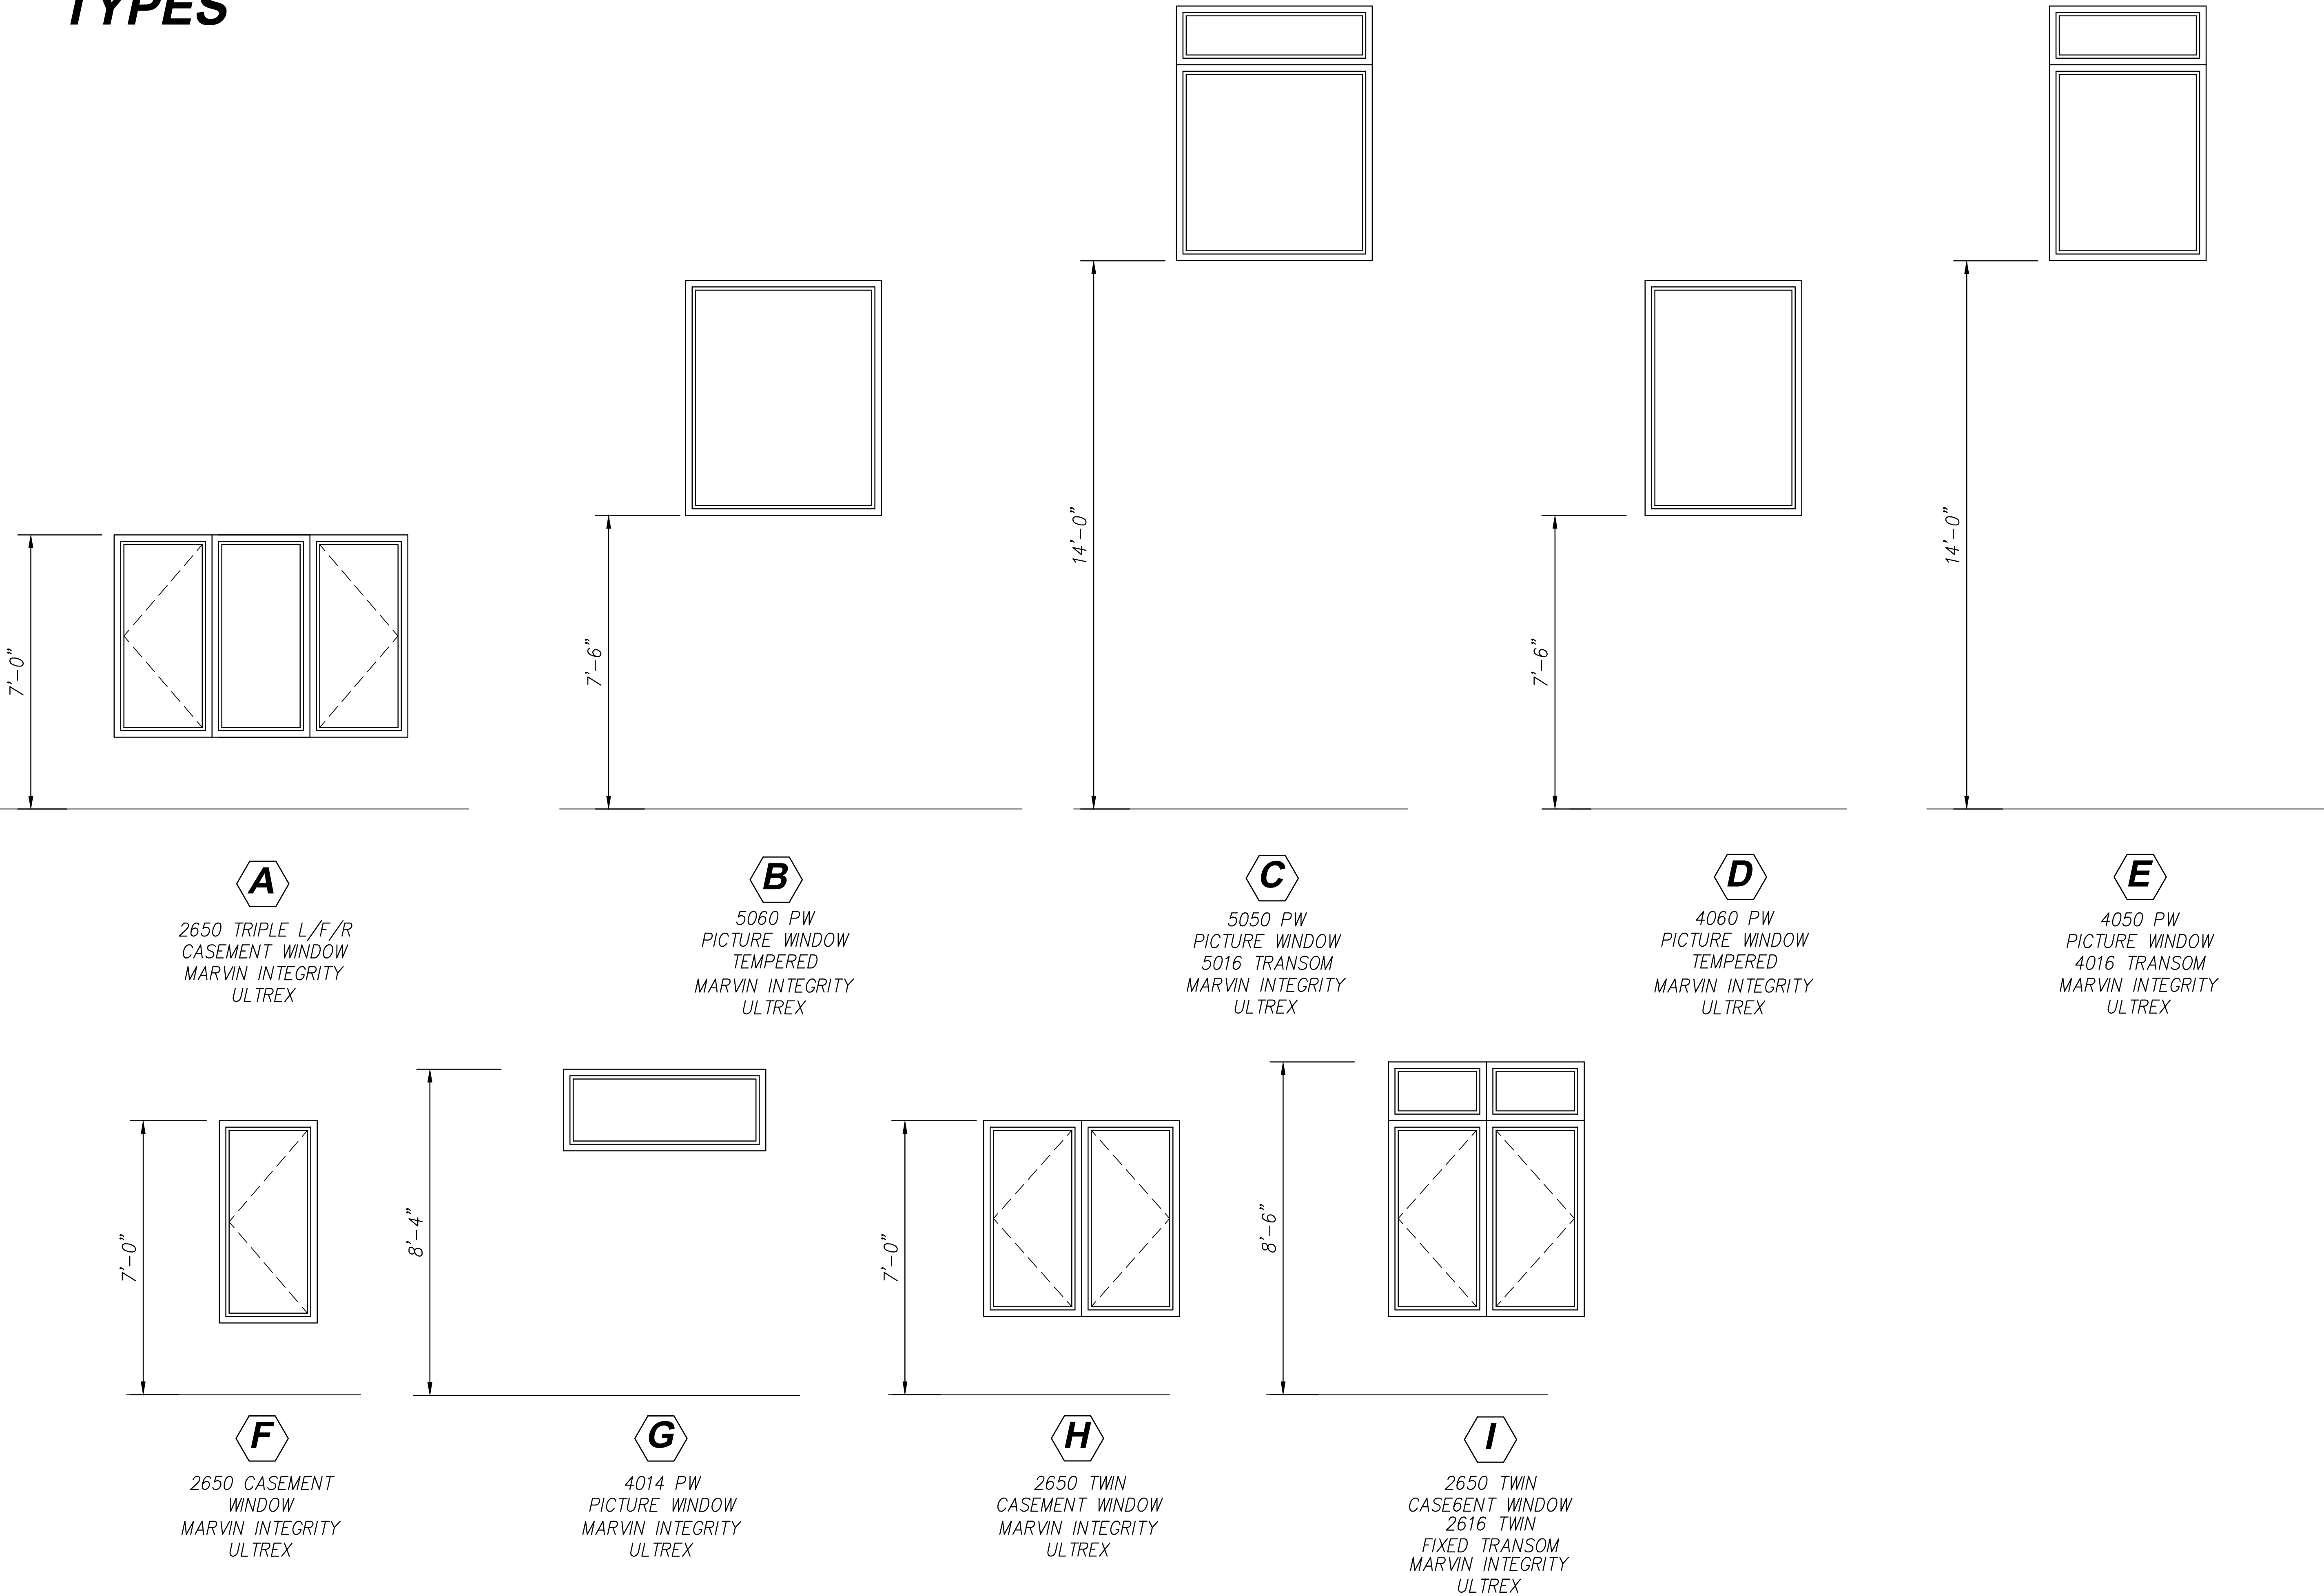

REVISIONS	
DATE	REMARKS
6-06-17	OWNER CHANGES

ISSUED FOR
PERMIT
3-10-17

THIS DRAWING IS THE PROPERTY OF

S.E. Wagner, Architect
4252 MANOR DRIVE
MARSHALL, VA 20115
p.540.364.6399
f.540.364.0446
sewain@aol.com

1304 SAVANNAH RD
LEWES, DE 19958
p.302.644.8884
f.302.644.8885
design@delmarva@verizon.net

© 2014 S.E. WAGNER, ARCHITECT

CHURCH ROAD ANIMAL HOSPITAL
45441 RURITAN CIRCLE
STERLING VIRGINIA

STOREFRONT TYPES

DATE 1-17-17	SHEET NO. A1
FILE 1	