
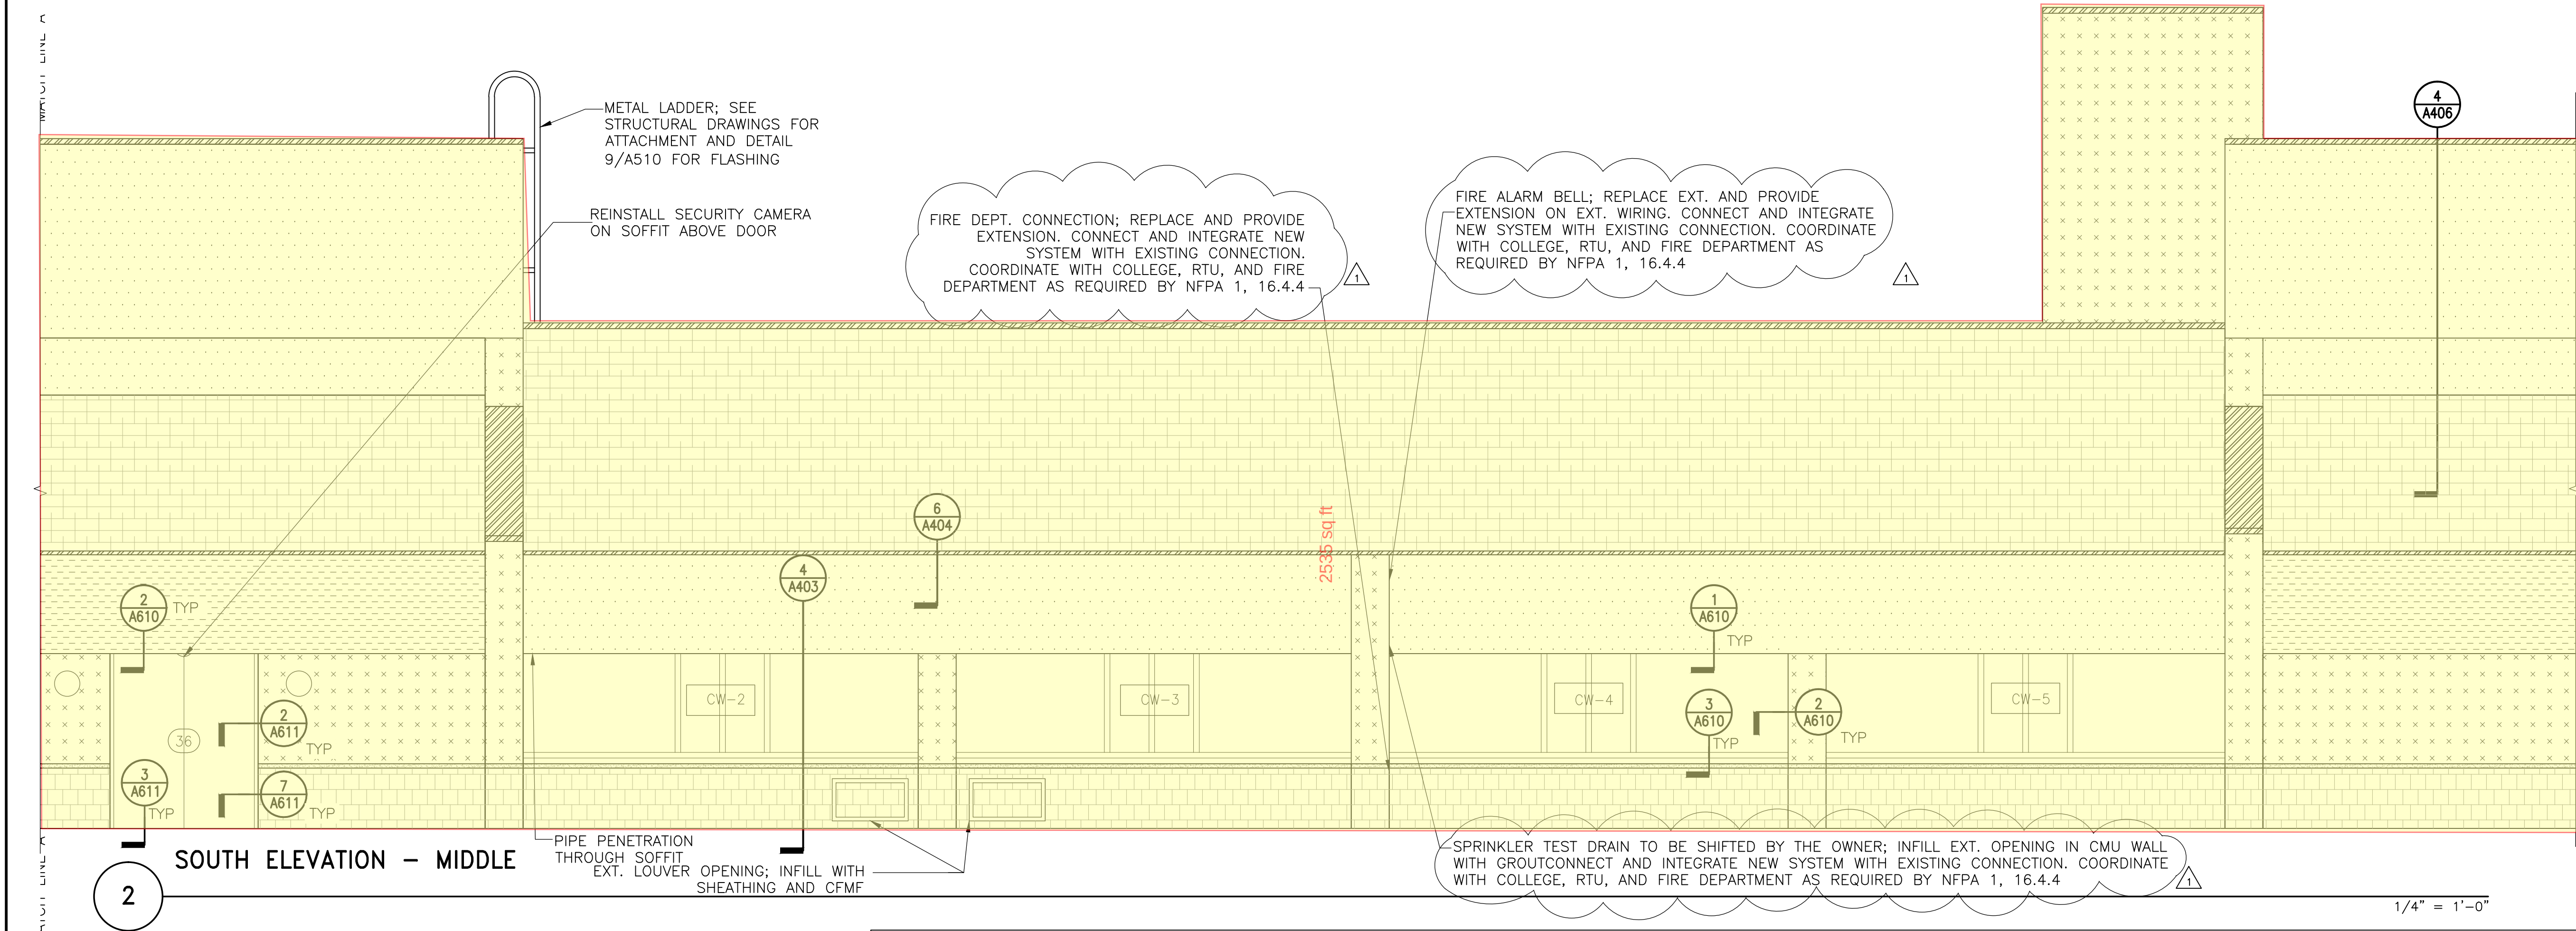


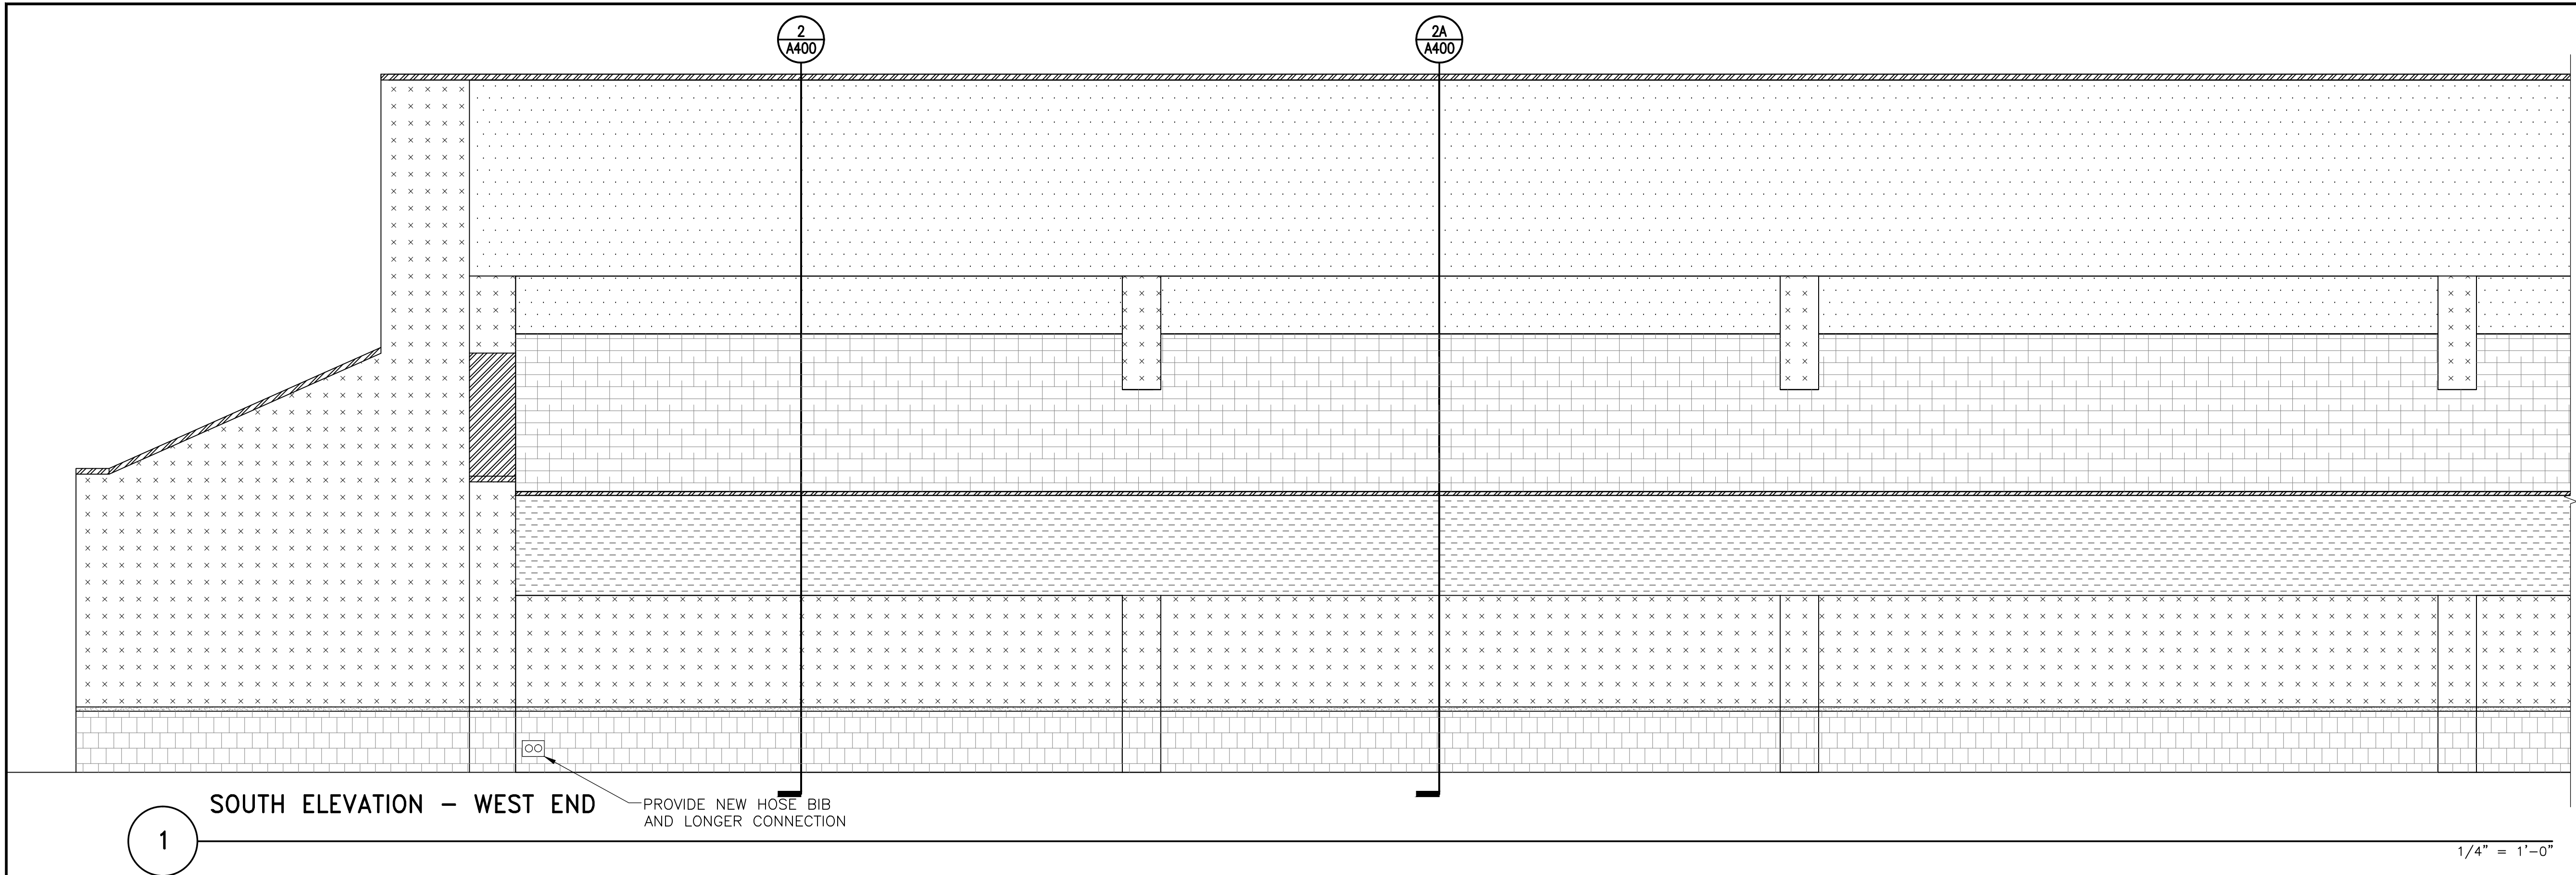

NOTE: Electrical work shown on this drawing shall be approved by an electrical engineer licensed in the State of Maryland, and shall be performed by a qualified electrician licensed in the State of Maryland.

LEGEND:

SOFFIT EIFS ASSEMBLY OVER NEW CFMF

EIFS ASSEMBLY OVER NEW SHEATHING AND CFMF BACKUP

EIFS ASSEMBLY OVER CMU BACKUP

BRICK MASONRY

CAST STONE BAND AT BRICK TO EIFS TRANSITION

METAL GRAVEL STOP OR COPING

SYNTHETIC CLAY TILE ROOF

EXT. WOOD TRELLIS ANCHORS (ANCHORS ARE ALSO ATTACHED TO BACKSIDE OF EIFS CLAD BEAM)

HOSE BIB; REPLACE AND PROVIDE LONGER CONNECTION

VENT ON UNDERSIDE OF SOFFIT; REINSTALL OR REPLACE

SCONCE; REINSTALL OR REPLACE

METAL LOUVER

NOTE: VERIFY ALL TYPES, NUMBER AND LOCATION OF MEP FIXTURES ON THE ELEVATIONS

SIMPSON GUMPERTZ & HEGER
Engineering of Structures and Building Enclosures

Simpson Gumpertz & Heger Inc.
1828 L Street NW, Suite 950
Washington, DC 20036
main: 202.239.4199 fax: 202.239.4198
www.sgh.com

Boston
Chicago
Los Angeles
New York
San Francisco
Washington, DC

Door Hardware Consultant

Security Consultant

Cost Estimating Consultant

Consultant

Erbschloe Consulting Services, Inc.
7820 Carters Run Drive
Marshall, VA 20115
540.351.0553

GHD, Inc.
14585 Avion Parkway, Suite 150
Chantilly, VA 20151
571.325.5000

Forella Group, LLC
9495 Silver King Ct., Suite A
Fairfax, VA 22031
703.560.2200

No.	Date	Description	By
1	01/22/16	Bid Set (County Response Set)	
2	11/20/15	Pricing/Permit Set	
3	08/28/15	100% Design Development	

**PHYSICAL EDUCATION BLDG
EXTERIOR RENOVATION
MONTGOMERY COLLEGE
GERMANTOWN CAMPUS
20200 OBSERVATION DRIVE
GERMANTOWN, MD 20876**

ELEVATIONS

Drawing Title

Project No. 150049.01	Checked PKF	Date 01/22/16
Drawn BSR/CEM	Approved DSS	Scale AS SHOWN

Drawing No.

A201


Professional Seal
I hereby certify that these documents were prepared or approved by me, and that I am a duly licensed professional engineer under the laws of the State of Maryland.
License No. 15494 Exp. Date 6/1/17
Seal

Drawing Title		
Project No. 150049.01	Checked PKF	Date 01/22/16
Drawn BSR/CEM	Approved DSS	Scale AS SHOWN
 Professional Engineer I hereby certify that these documents were prepared or approved by me, and that I am a duly licensed professional engineer under the laws of the State of Maryland. J. Boone, Jr., 13764 Seal Exp. Date 6/1/17		Drawing No. A202


LEGEND:

	SOFFIT EIFS ASSEMBLY OVER NEW CMF		BRICK MASONRY		SYNTHETIC CLAY TILE ROOF		HOSE BIB; REPLACE AND PROVIDE LONGER CONNECTION
	EIFS ASSEMBLY OVER NEW SHEATHING AND CMF BACKUP		CAST STONE BAND AT BRICK TO EIFS TRANSITION		EXT. WOOD TRELLIS ANCHORS (ANCHORS ARE ALSO ATTACHED TO BACKSIDE OF EIFS CLAD BEAM)		VENT ON UNDERSIDE OF SOFFIT; REINSTALL OR REPLACE
	EIFS ASSEMBLY OVER CMU BACKUP		METAL GRAVEL STOP OR COPING		SCONCE; REINSTALL OR REPLACE		METAL LOUVER

NOTE: VERIFY ALL TYPES, NUMBER AND LOCATION OF MEP FIXTURES ON THE ELEVATIONS

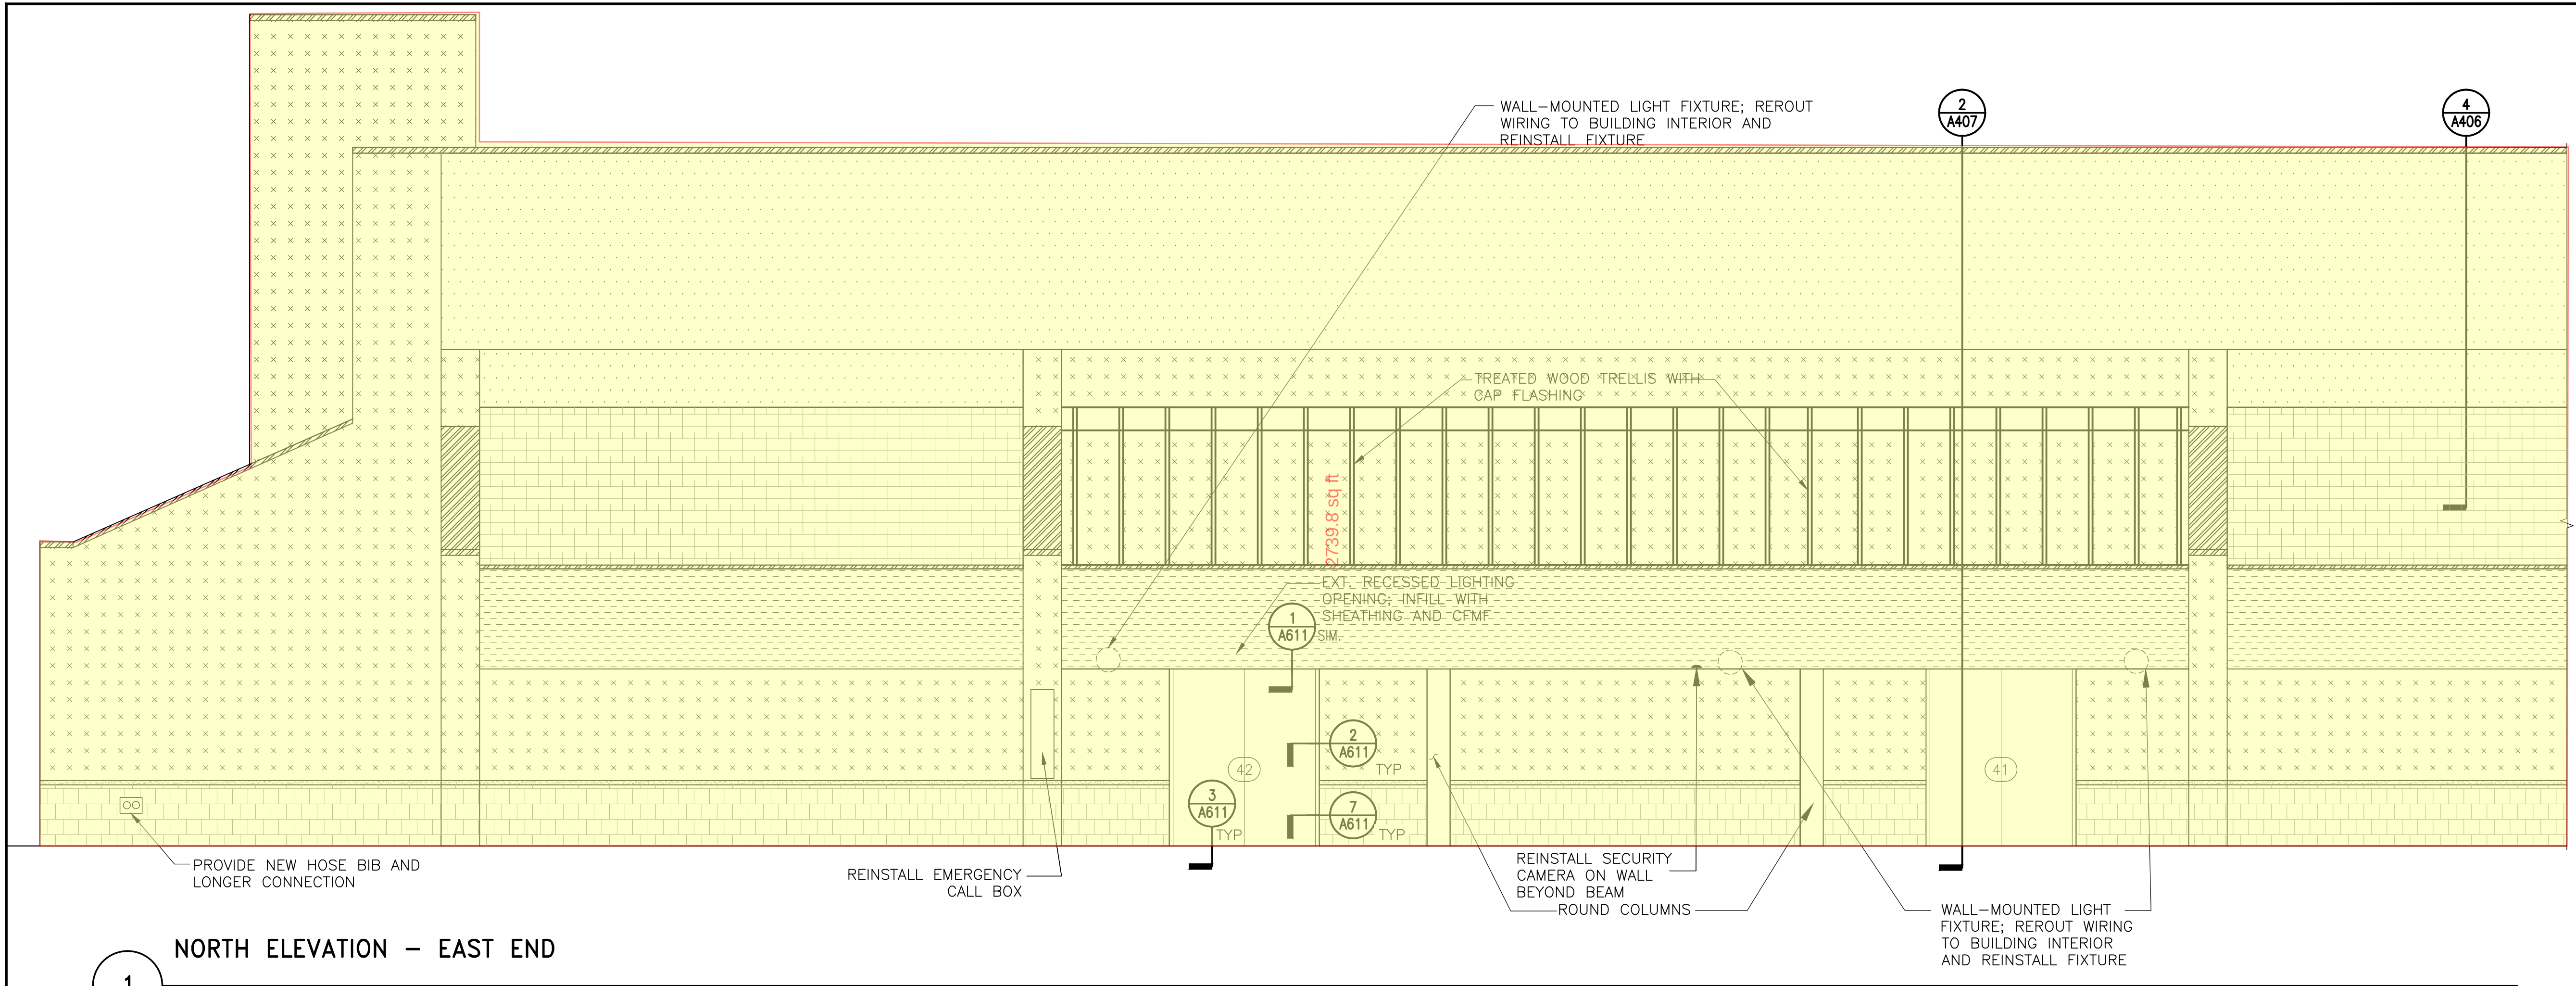

NORTH ELEVATION - EAST END

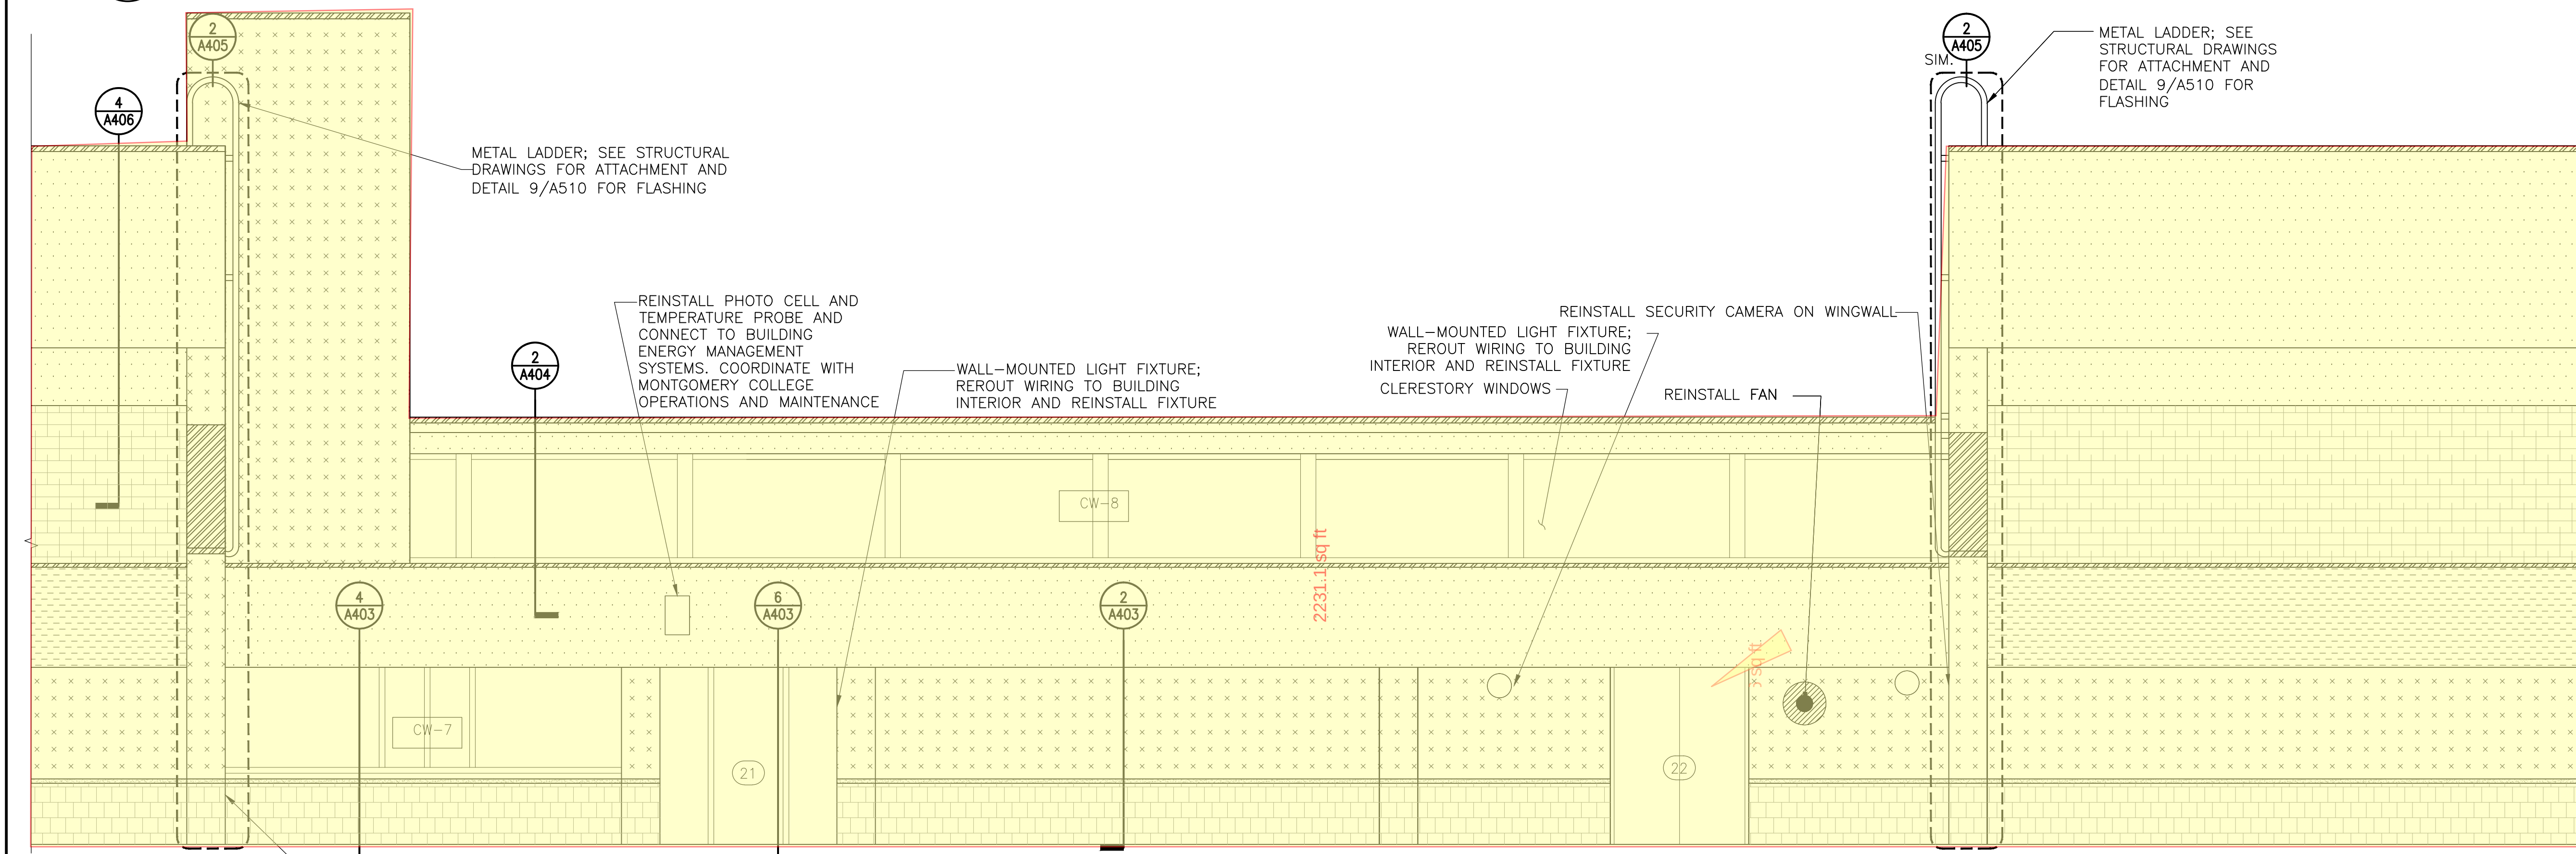

NORTH ELEVATION - MIDDLE

LEGEND:

- SOFFIT EIFS ASSEMBLY OVER NEW CFMF
- EIFS ASSEMBLY OVER NEW SHEATHING AND CFMF BACKUP
- EIFS ASSEMBLY OVER CMU BACKUP

- BRICK MASONRY
- CAST STONE BAND AT BRICK TO EIFS TRANSITION
- METAL GRAVEL STOP OR COPING

- SYNTHETIC CLAY TILE ROOF
- EXT. WOOD TRELLIS ANCHORS (ANCHORS ARE ALSO ATTACHED TO BACKSIDE OF EIFS CLAD BEAM)

- HOSE BIB; REPLACE AND PROVIDE LONGER CONNECTION
- VENT ON UNDERSIDE OF SOFFIT; REINSTALL OR REPLACE
- SCONCE; REINSTALL OR REPLACE

- METAL LOUVER

NOTE: VERIFY ALL TYPES, NUMBER AND LOCATION OF MEP FIXTURES ON THE ELEVATIONS

NOTE: Electrical work shown on this drawing shall be approved by an electrical engineer licensed in the State of Maryland, and shall be performed by a qualified electrician licensed in the State of Maryland.

SIMPSON GUMPERTZ & HEGER

Engineering of Structures and Building Enclosures

Simpson Gumpertz & Heger Inc.
1828 L Street NW, Suite 950
Washington, DC 20036
main: 202.239.4199 fax: 202.239.4198
www.sgh.com

Boston
Chicago
Los Angeles
New York
San Francisco
Washington, DC

Door Hardware
Consultant

Erbschloe Consulting Services, Inc.
7820 Carters Run Drive
Marshall, VA 20115
540.351.0553

Security
Consultant

GHD, Inc.
14585 Avion Parkway, Suite 150
Chantilly, VA 20151
571.325.5000

Cost Estimating
Consultant

Forella Group, LLC.
9495 Silver King Ct., Suite A
Fairfax, VA 22031
703.560.2200

Consultant

BID SET

	01/22/16	Bid Set/County Response Set	
	11/20/15	Pricing/Permit Set	
	08/28/15	100% Design Development	
No.	Date	Description	By


**PHYSICAL EDUCATION BLDG
EXTERIOR RENOVATION
MONTGOMERY COLLEGE
GERMANTOWN CAMPUS
20200 OBSERVATION DRIVE
GERMANTOWN, MD 20876**

Project


ELEVATIONS

Drawing Title

Project No. 150049.01	Checked PKF	Date 01/22/16
Drawn BSR/CEM	Approved DSS	Scale AS SHOWN

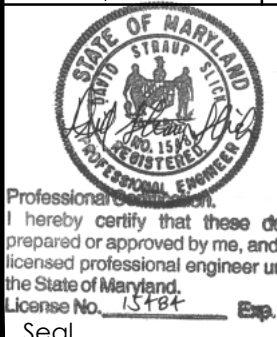

A204

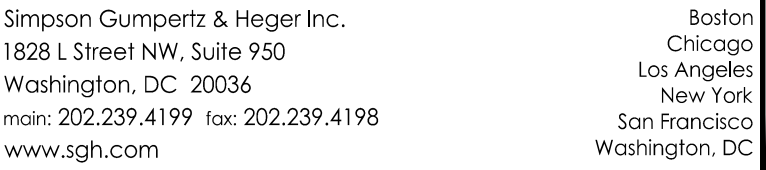


Consultant

	01/22/16	Bid Set/County Response Set	
	11/20/15	Pricing/Permit Set	
	08/28/15	100% Design Development	
No.	Date	Description	By


Project

Drawing Title

 Professional Engineer
I hereby certify that these documents were
prepared or approved by me, and that I am a duly
licensed professional engineer under the laws of
the State of Maryland.
License No. 15484 Exp. Date: 8/2/17
Seal



 1)



2

 SOFFIT EIFS ASSEMBLY OVER NEW CFM

 EIFS ASSEMBLY OVER NEW SHEATHING AND CFM BACKUP

 EIFS ASSEMBLY OVER CMU BACKUP






 COPING

EXT. WOOD TRELLIS ANCHORS
(ANCHORS ARE ALSO ATTACHED
TO BACKSIDE OF EIFS CLAD
BEAM)

○ SCONCE; REINSTALL OR REPLACE

NOTE: VERIFY ALL TYPES, NUMBER AND LOCATION OF
MEP FIXTURES ON THE ELEVATIONS

NOTE: Electrical work shown on this drawing shall be approved by an electrical engineer licensed in the State of Maryland, and shall be performed by a qualified electrician licensed in the State of Maryland.

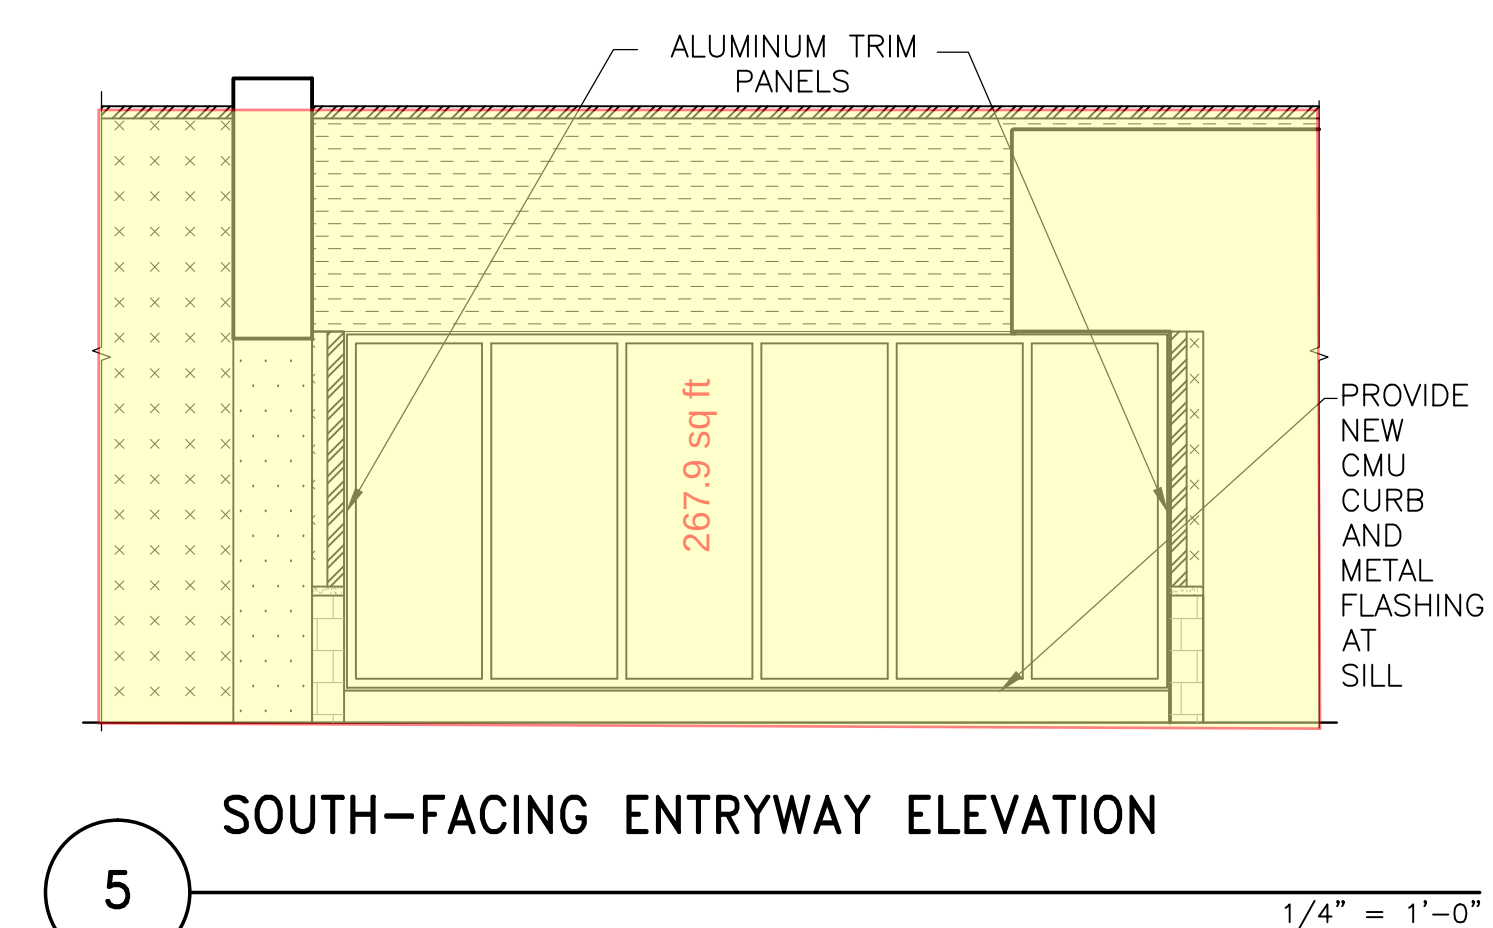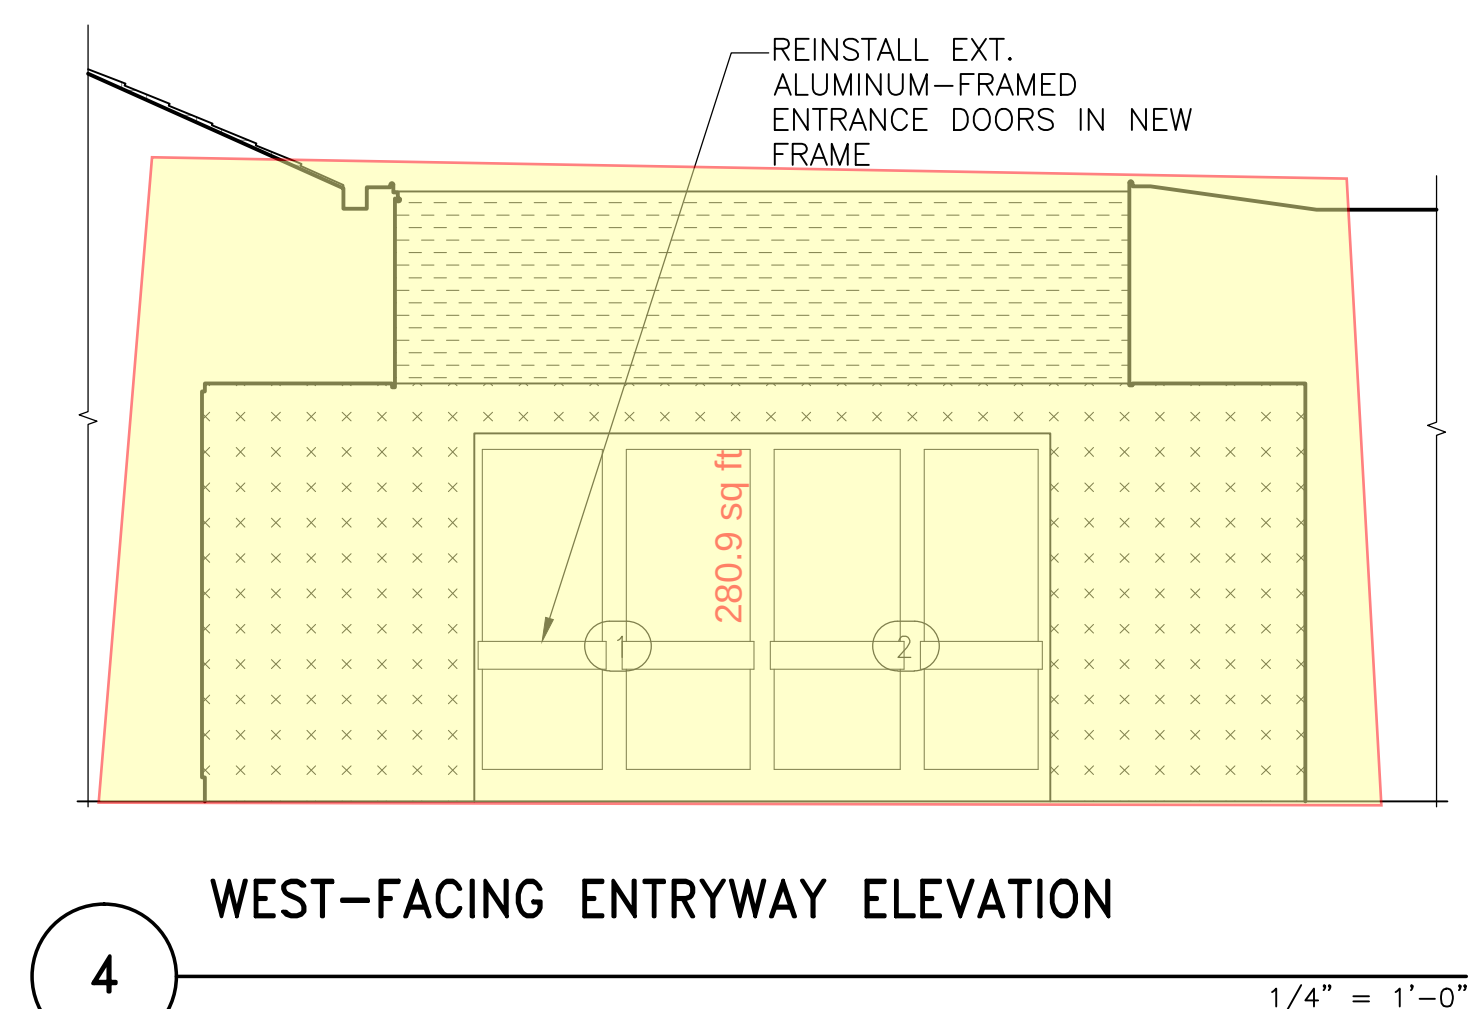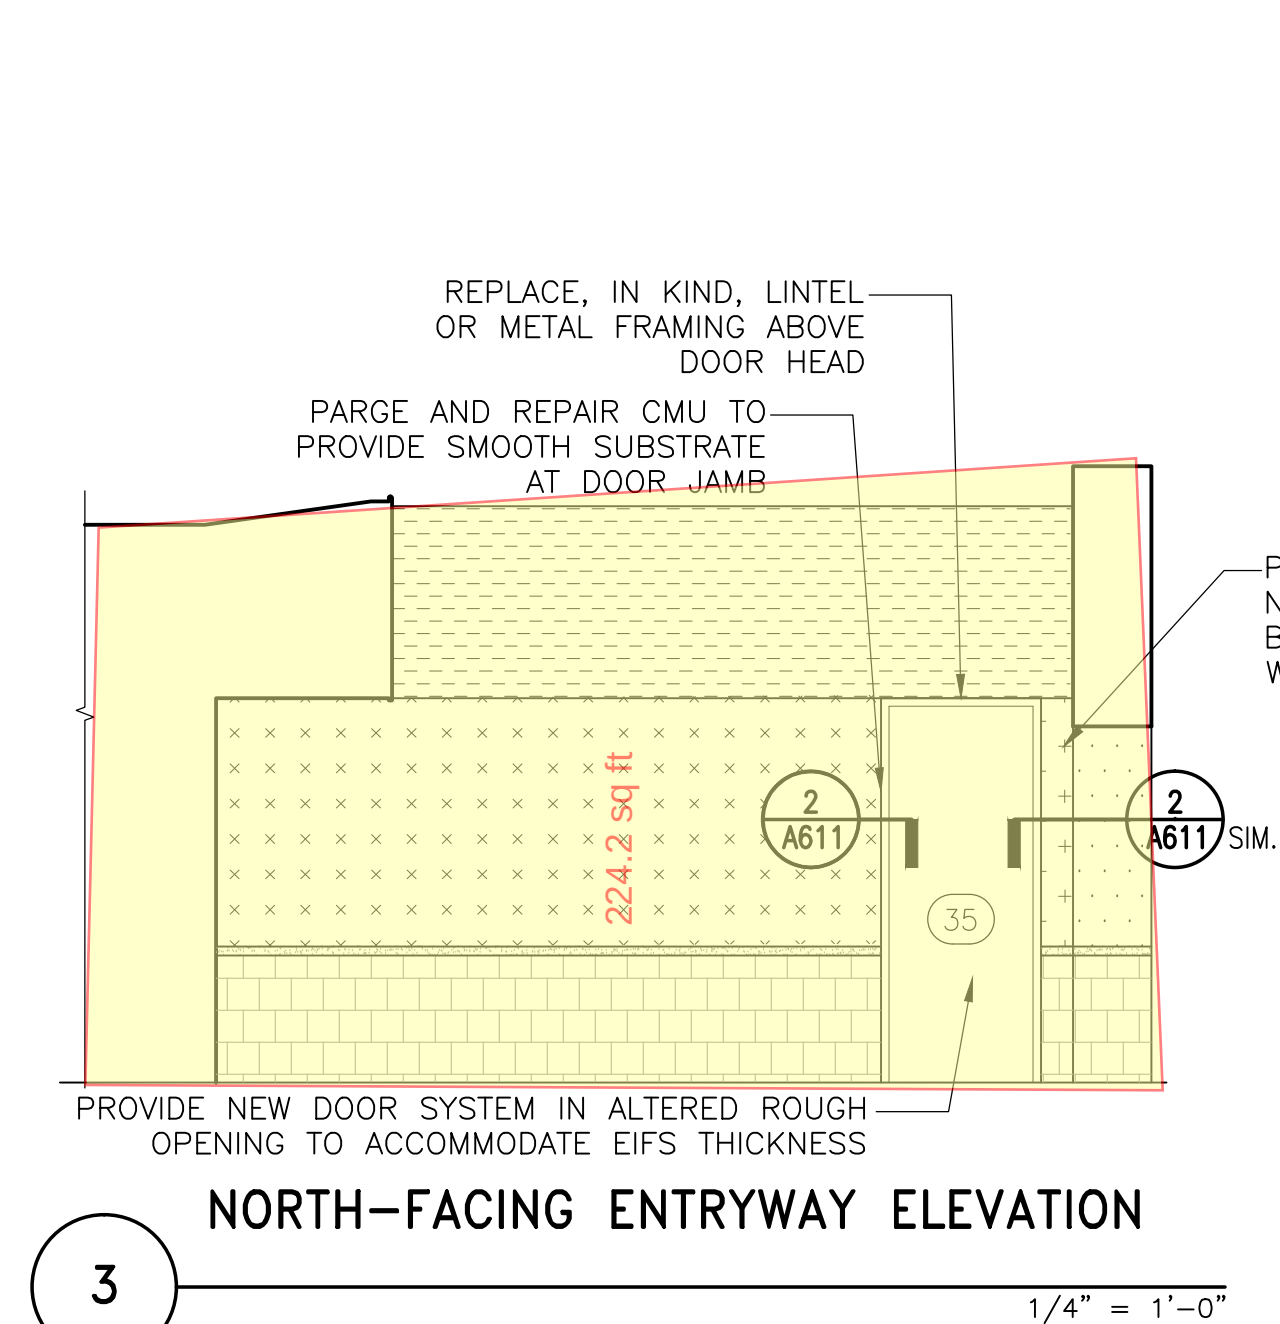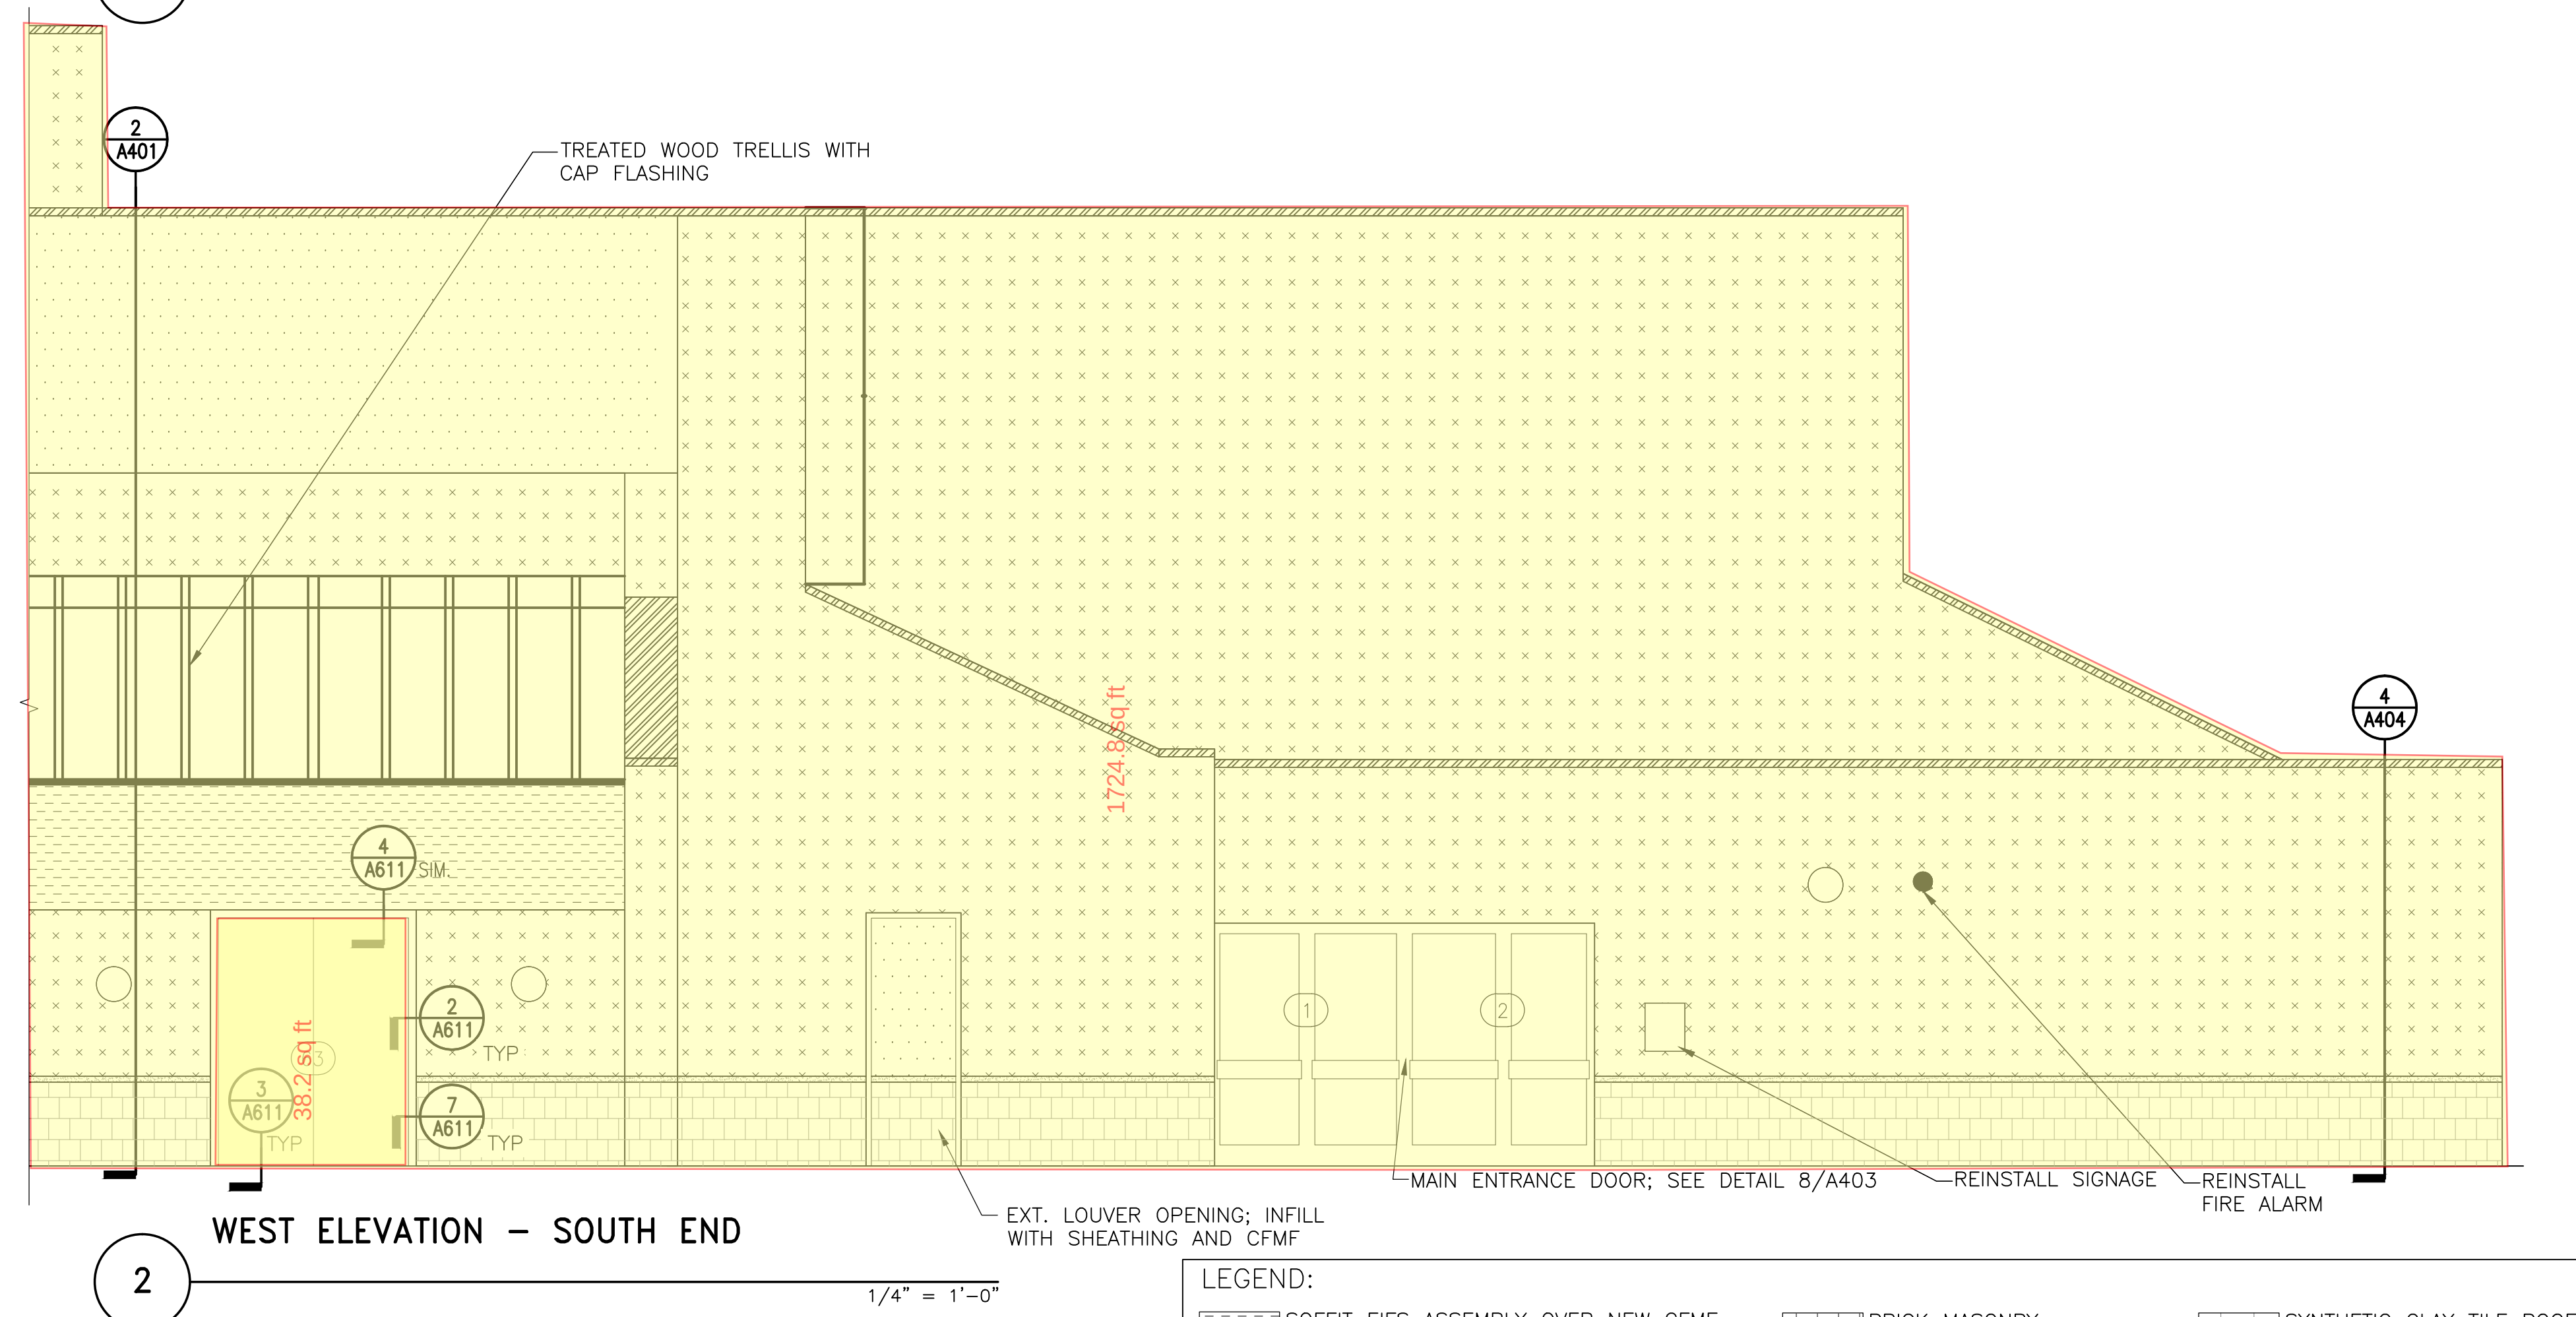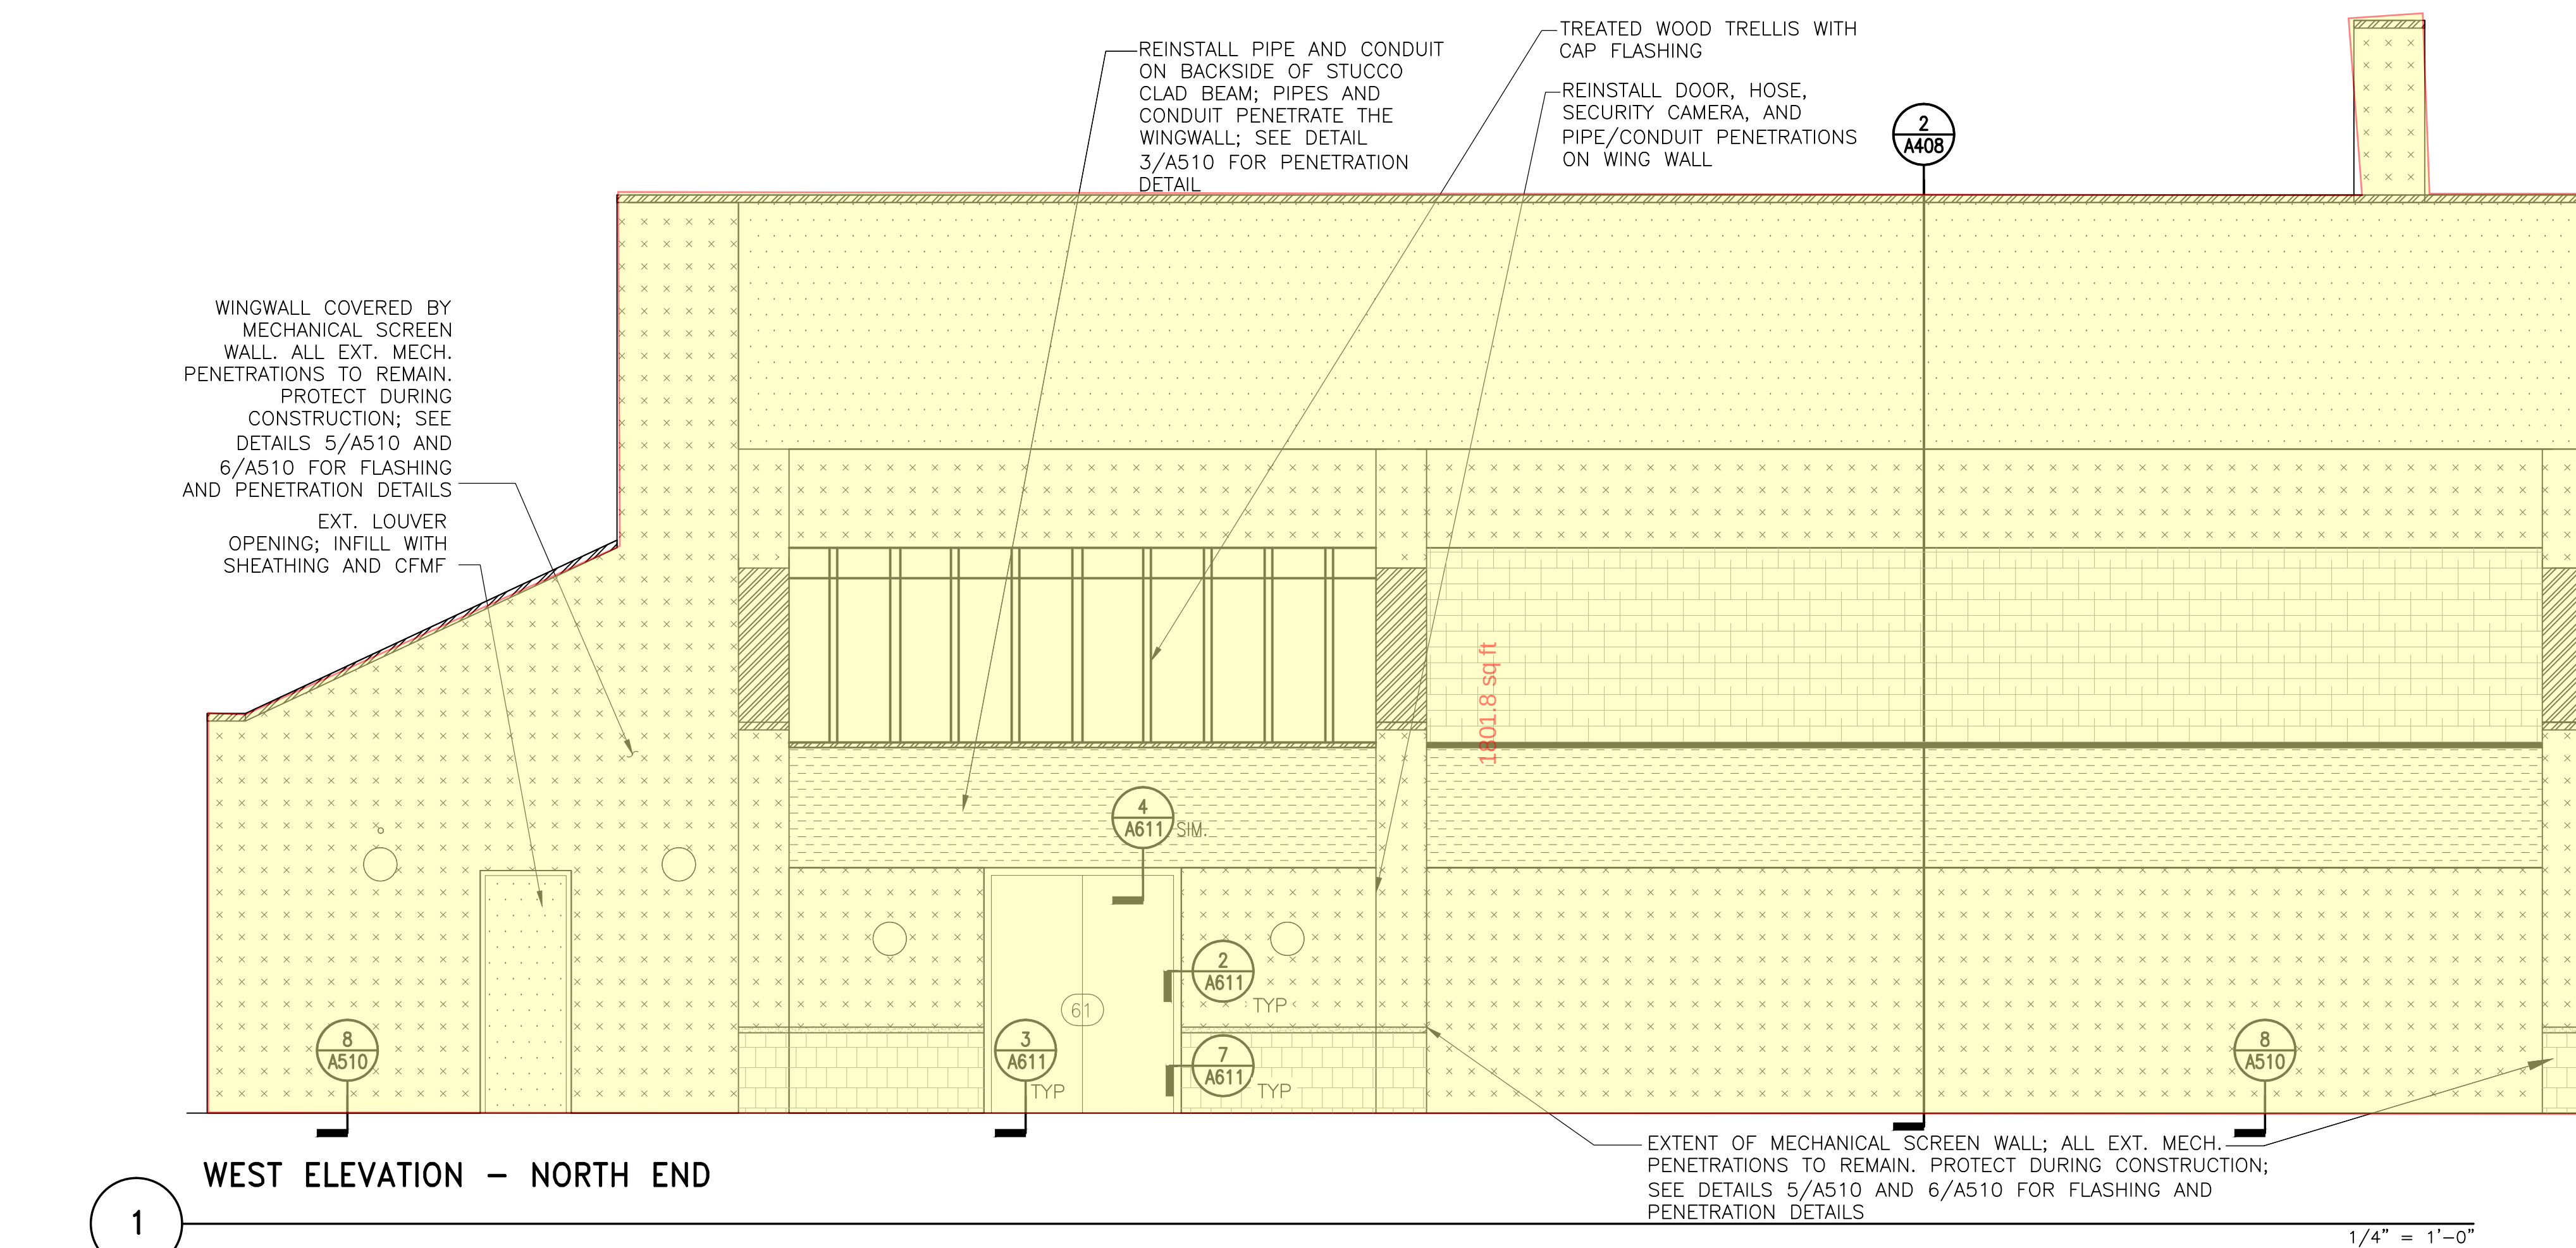

NOTE: Electrical work shown on this drawing shall be approved by an electrical engineer licensed in the State of Maryland, and shall be performed by a qualified electrician licensed in the State of Maryland.

NOTE: VERIFY ALL TYPES, NUMBER AND LOCATION OF MEP FIXTURES ON THE ELEVATIONS

Simpson Gumpertz & Heger Inc.
1828 L Street NW, Suite 950
Washington, DC 20036
main: 202.239.4199 fax: 202.239.4198
www.sgh.com

Boston
Chicago
Los Angeles
New York
San Francisco
Washington, DC

Door Hardware
Consultant

Erbschloe Consulting Services, Inc.
7820 Carters Run Drive
Marshall, VA 20115
540.351.0553

Security
Consultant

GHD, Inc.
14585 Avion Parkway, Suite 150
Chantilly, VA 20151
571.325.5000

Cost Estimating
Consultant

Forella Group, LLC.
9495 Silver King Ct., Suite A
Fairfax, VA 22031
703.560.2200

Consultant

BID SET

[illegible]

**PHYSICAL EDUCATION BLDG
EXTERIOR RENOVATION
MONTGOMERY COLLEGE
GERMANTOWN CAMPUS
20200 OBSERVATION DRIVE
GERMANTOWN, MD 20876**

Project

ELEVATIONS

Drawing Title

Project No. 150049.01	Checked PKF	Date 01/22/16
Drawn BSR/CEM	Approved DSS	Scale AS SHOWN

Professional Seal I hereby certify that these documents were prepared or approved by me, and that I am a duly licensed professional engineer under the laws of the State of Maryland. License No. 1378-C	A206 <i>Exp. Date 4/1/11</i>
--	--